



PROJECT LOCATION

PLAN INDEX	
PAGE	PAGE TITLE
1	Project Overview
2	Architectural Floor Plan
3	MEP Plan
4	Electrical Schedule
5	General Notes, Code Info, Symbols, Keys
6	Kitchen, Bar, Scullery
7	Bar Elevations
8	Kitchen Elevations
9	Kitchen Elevations
10	3D Views Kitchen, Bar & Servery
11	Living Room & Hall
12	3D Views Living & Hall
13	Primary Bath
14	3D Views Primary Bath
15	Inlaw, Flex, Maggie's Baths
16	3D Views Flex & Maggie's Baths
17	3D Views Inlaw Bath
18	Primary
19	Cabinet Schedule

PROJECT TEAM

Tyler Woodruff CR
Project Manager
Office: (682) 262-4062
Direct: (972) 971-2721



Melissa-Blassingille
Interior Designer
Office: (972) 232-7122
Direct: (214) 336-0553

3D VIEWS ARE NOT TO SCALE AND MAY NOT REFLECT EXACTLY WHAT IS AVAILABLE FOR THE PROJECT. RENDER VIEWS ARE REPRESENTATIONS OF WHAT THE VIEW COULD LOOK LIKE, NOT WHAT IT WILL LOOK LIKE. 2D VIEWS ALWAYS SUPERCEDE 3D VIEWS

Renowned Group
4848 Lemmon Ave, suite 106,
Dallas, TX, 75219
PHONE: 972-232-7122 EMAIL: info@renowned-group.com

LICENSE NUMBER:
BU118842

REMODEL PLANS FOR:
Plassick Morton
3504 Villanova St
Dallas, TX, 75225

PAGE TITLE:
Project Overview

DRAWN BY:
MB

DATE:
5/7/25

SCALE:
NA



SHEET #:
1



VICINITY MAP

RENOWNED GROUP JOBSITE RULES

1. WORK HOURS:
WORK HOURS ARE STRICTLY BETWEEN 7:00 A.M. AND 7:00 P.M., MONDAY THROUGH FRIDAY. ON SATURDAYS, WORK MAY BEGIN AT 8:00 A.M., AND NO EXTERIOR WORK IS PERMITTED ON SUNDAYS.
DURING THESE HOURS, MINIMIZE NOISE THAT COULD DISTURB THE NEIGHBORHOOD, INCLUDING LIMITING LOUD MACHINERY, RADIOS, OR EXCESSIVE CONVERSATION.
2. CLEANLINESS & DAILY SITE UPKEEP:
ALL MATERIALS AND DEBRIS MUST REMAIN WITHIN THE PROPERTY LINES. NO MATERIALS ARE TO BE LEFT ON STREETS OR NEIGHBORING PROPERTIES.
EACH CONTRACTOR IS RESPONSIBLE FOR A DAILY CLEANUP. ALL SODA CANS, CUPS, LUNCH WRAPPERS, AND OTHER TRASH MUST BE PROPERLY DISPOSED OF BEFORE LEAVING FOR THE DAY.
3. SUBSTANCE USE:
DRUGS AND ALCOHOL ARE STRICTLY PROHIBITED ON THE JOB SITE AT ALL TIMES, INCLUDING BEFORE, DURING, AND AFTER WORK HOURS.
4. SMOKING POLICY:
NO SMOKING IS ALLOWED ANYWHERE ON THE PROPERTY. IF YOU NEED TO SMOKE, PLEASE DO SO IN YOUR VEHICLE PARKED ON THE STREET.
5. SAFETY COMPLIANCE:
ALL CONTRACTORS AND VENDORS MUST FOLLOW OSHA REGULATIONS AND ANY SPECIFIC SAFETY GUIDELINES REQUIRED BY RENOWNED GROUP.
6. PROFESSIONALISM & RESPECT:
OUR JOBSITE IS A PROFESSIONAL ENVIRONMENT. RESPECT FOR CLIENTS, NEIGHBORS, AND TEAM MEMBERS IS ESSENTIAL. HANDLE ALL INTERACTIONS PROFESSIONALLY AND REFER ANY INQUIRIES FROM HOMEOWNERS OR NEIGHBORS TO RENOWNED GROUP PERSONNEL IMMEDIATELY.
7. COMMUNICATION:
ALL QUESTIONS, CONCERNS, OR COMMENTS FROM NEIGHBORS OR CLIENTS SHOULD BE DIRECTED TO THE RENOWNED GROUP SITE SUPERVISOR OR PROJECT MANAGER.

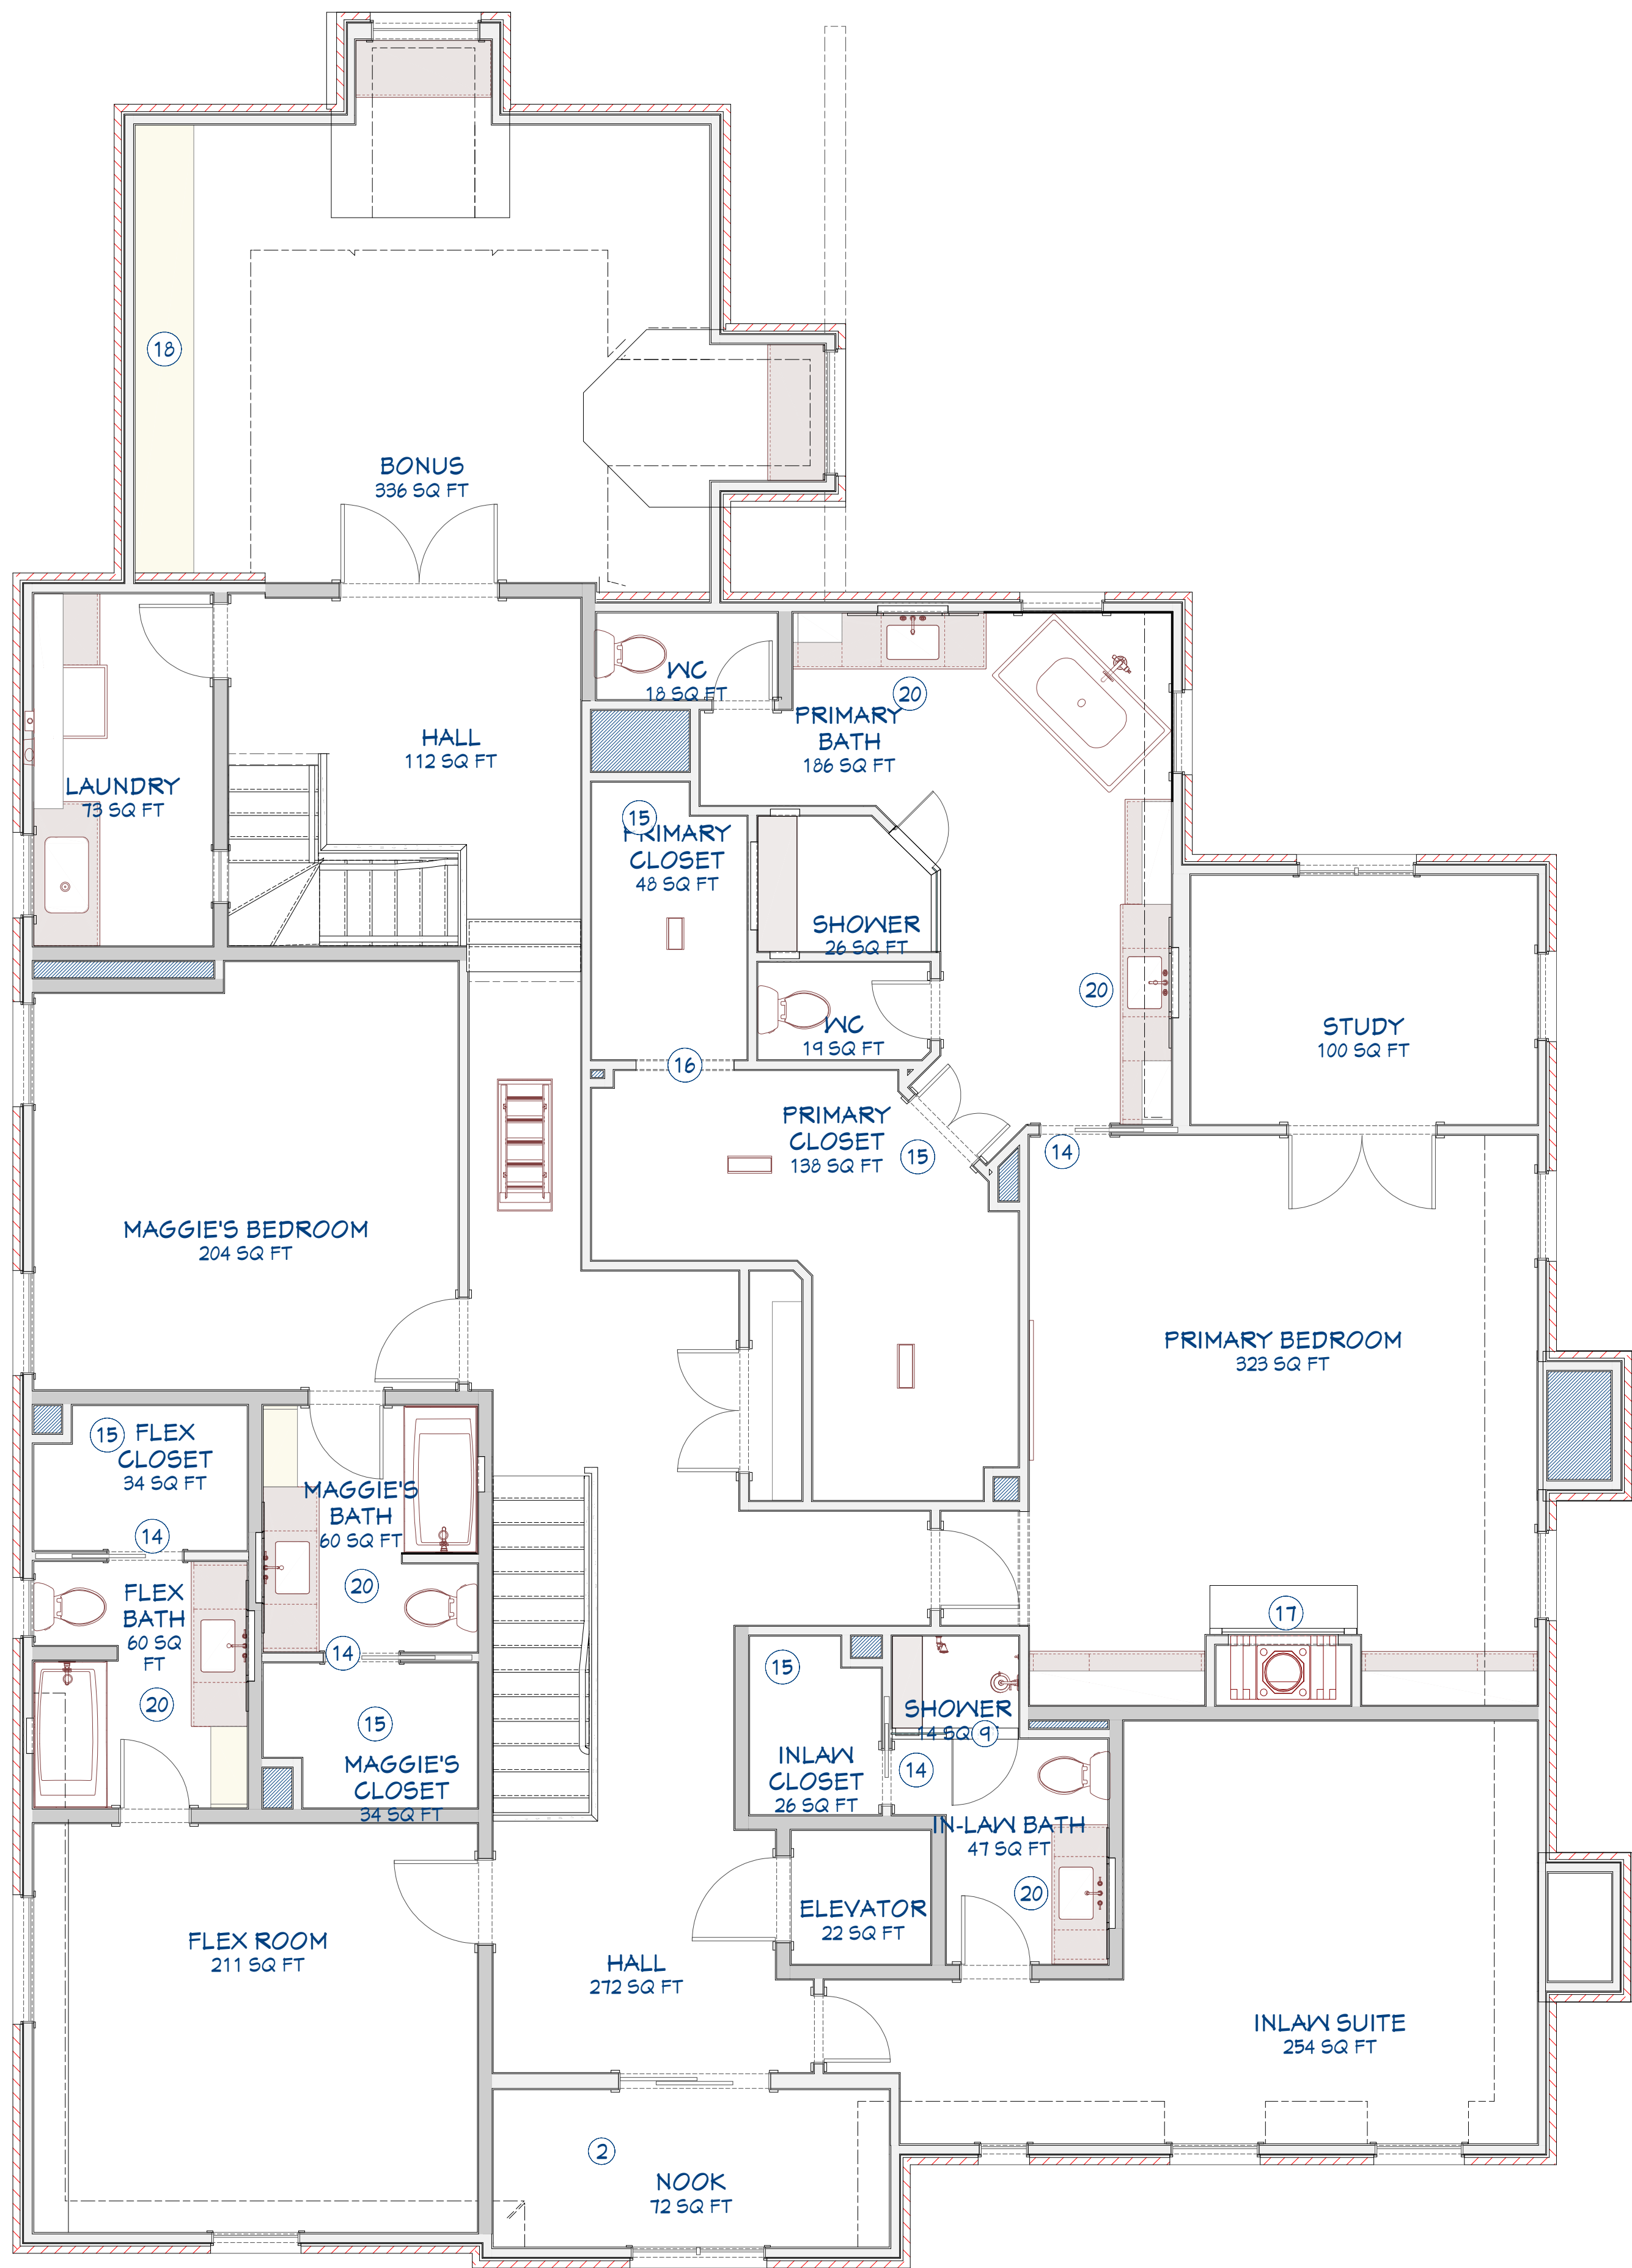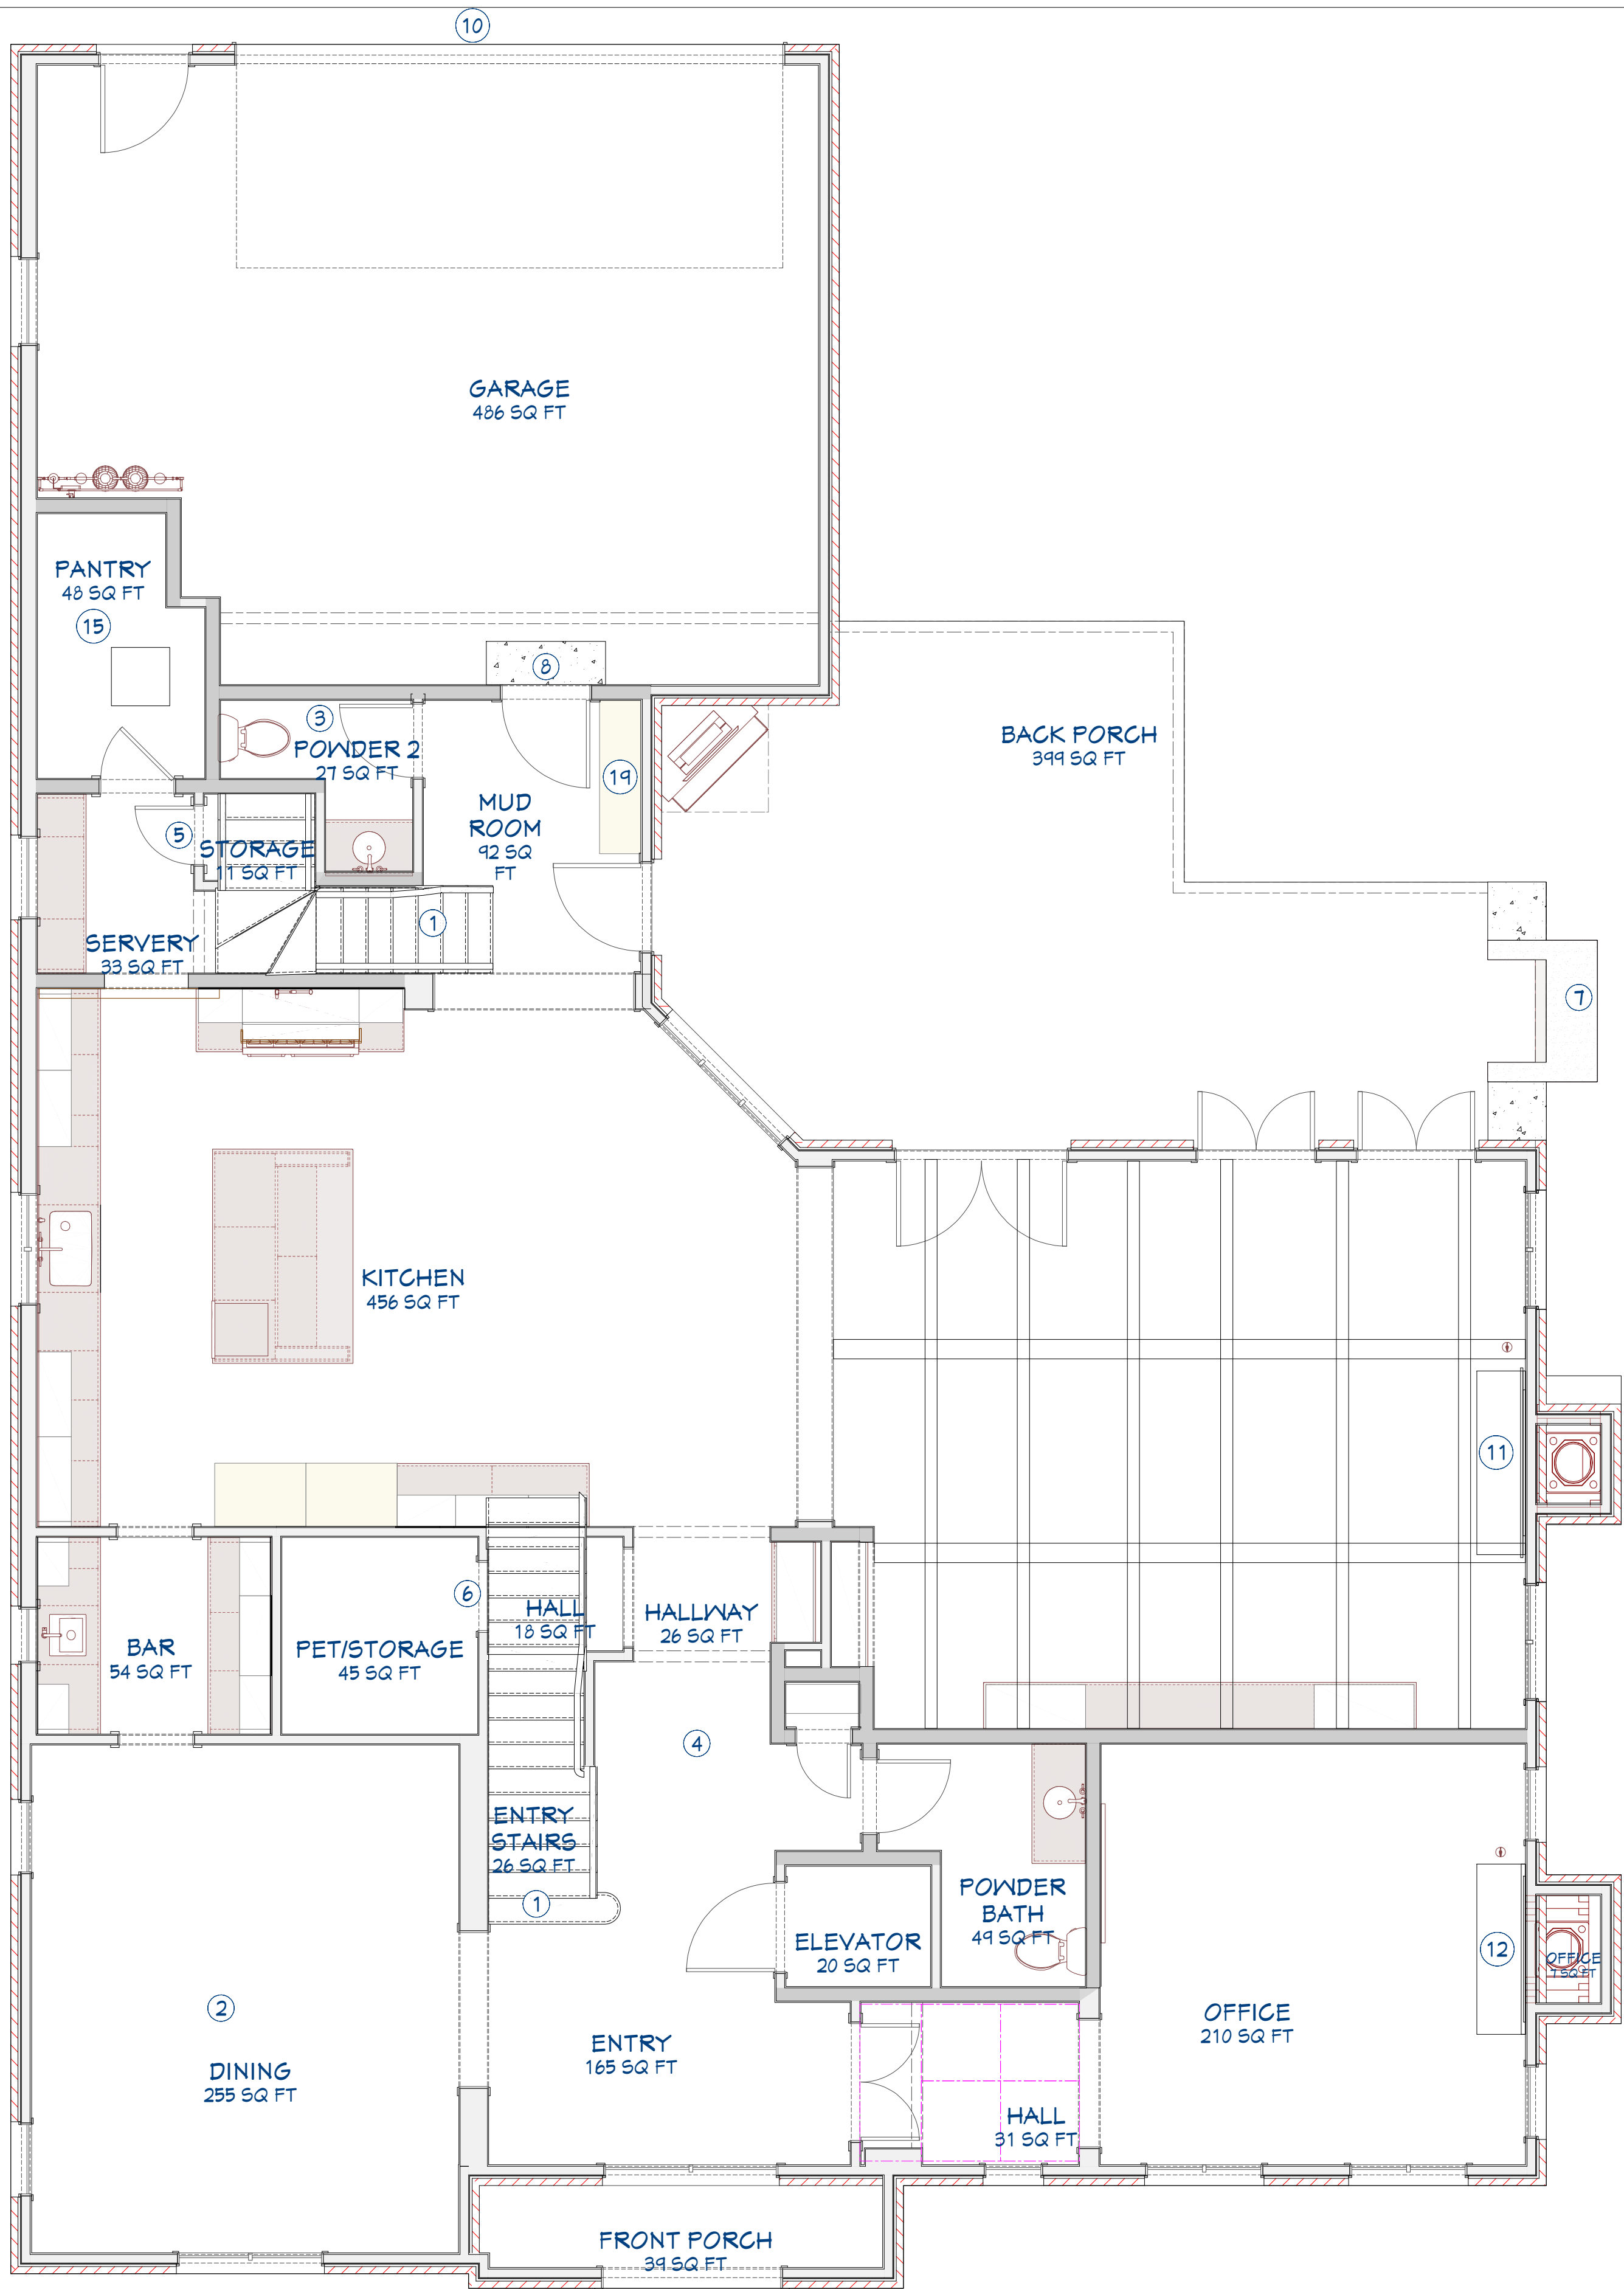

3D VIEWS ARE NOT TO SCALE AND MAY NOT REFLECT EXACTLY WHAT IS AVAILABLE FOR THE PROJECT. RENDER VIEWS ARE REPRESENTATIONS OF WHAT THE VIEW COULD LOOK LIKE, NOT WHAT IT WILL LOOK LIKE. 2D VIEWS ALWAYS SUPERCEDE 3D VIEWS

Renowned Group
4848 Lemmon Ave, suite 106,
Dallas, TX, 75219
PHONE: 972-252-7122 EMAIL: info@renowned-group.com

LICENSE NUMBER:
BU118842

REMODEL PLANS FOR:
Plasick Morton
3504 Villanova St
Dallas, TX, 75225



PAGE TITLE:
Architectural Floor Plan

DRAWN BY:
MB

DATE:
5/7/25

SCALE:
1/4" = 1'0"

SHEET #:
2

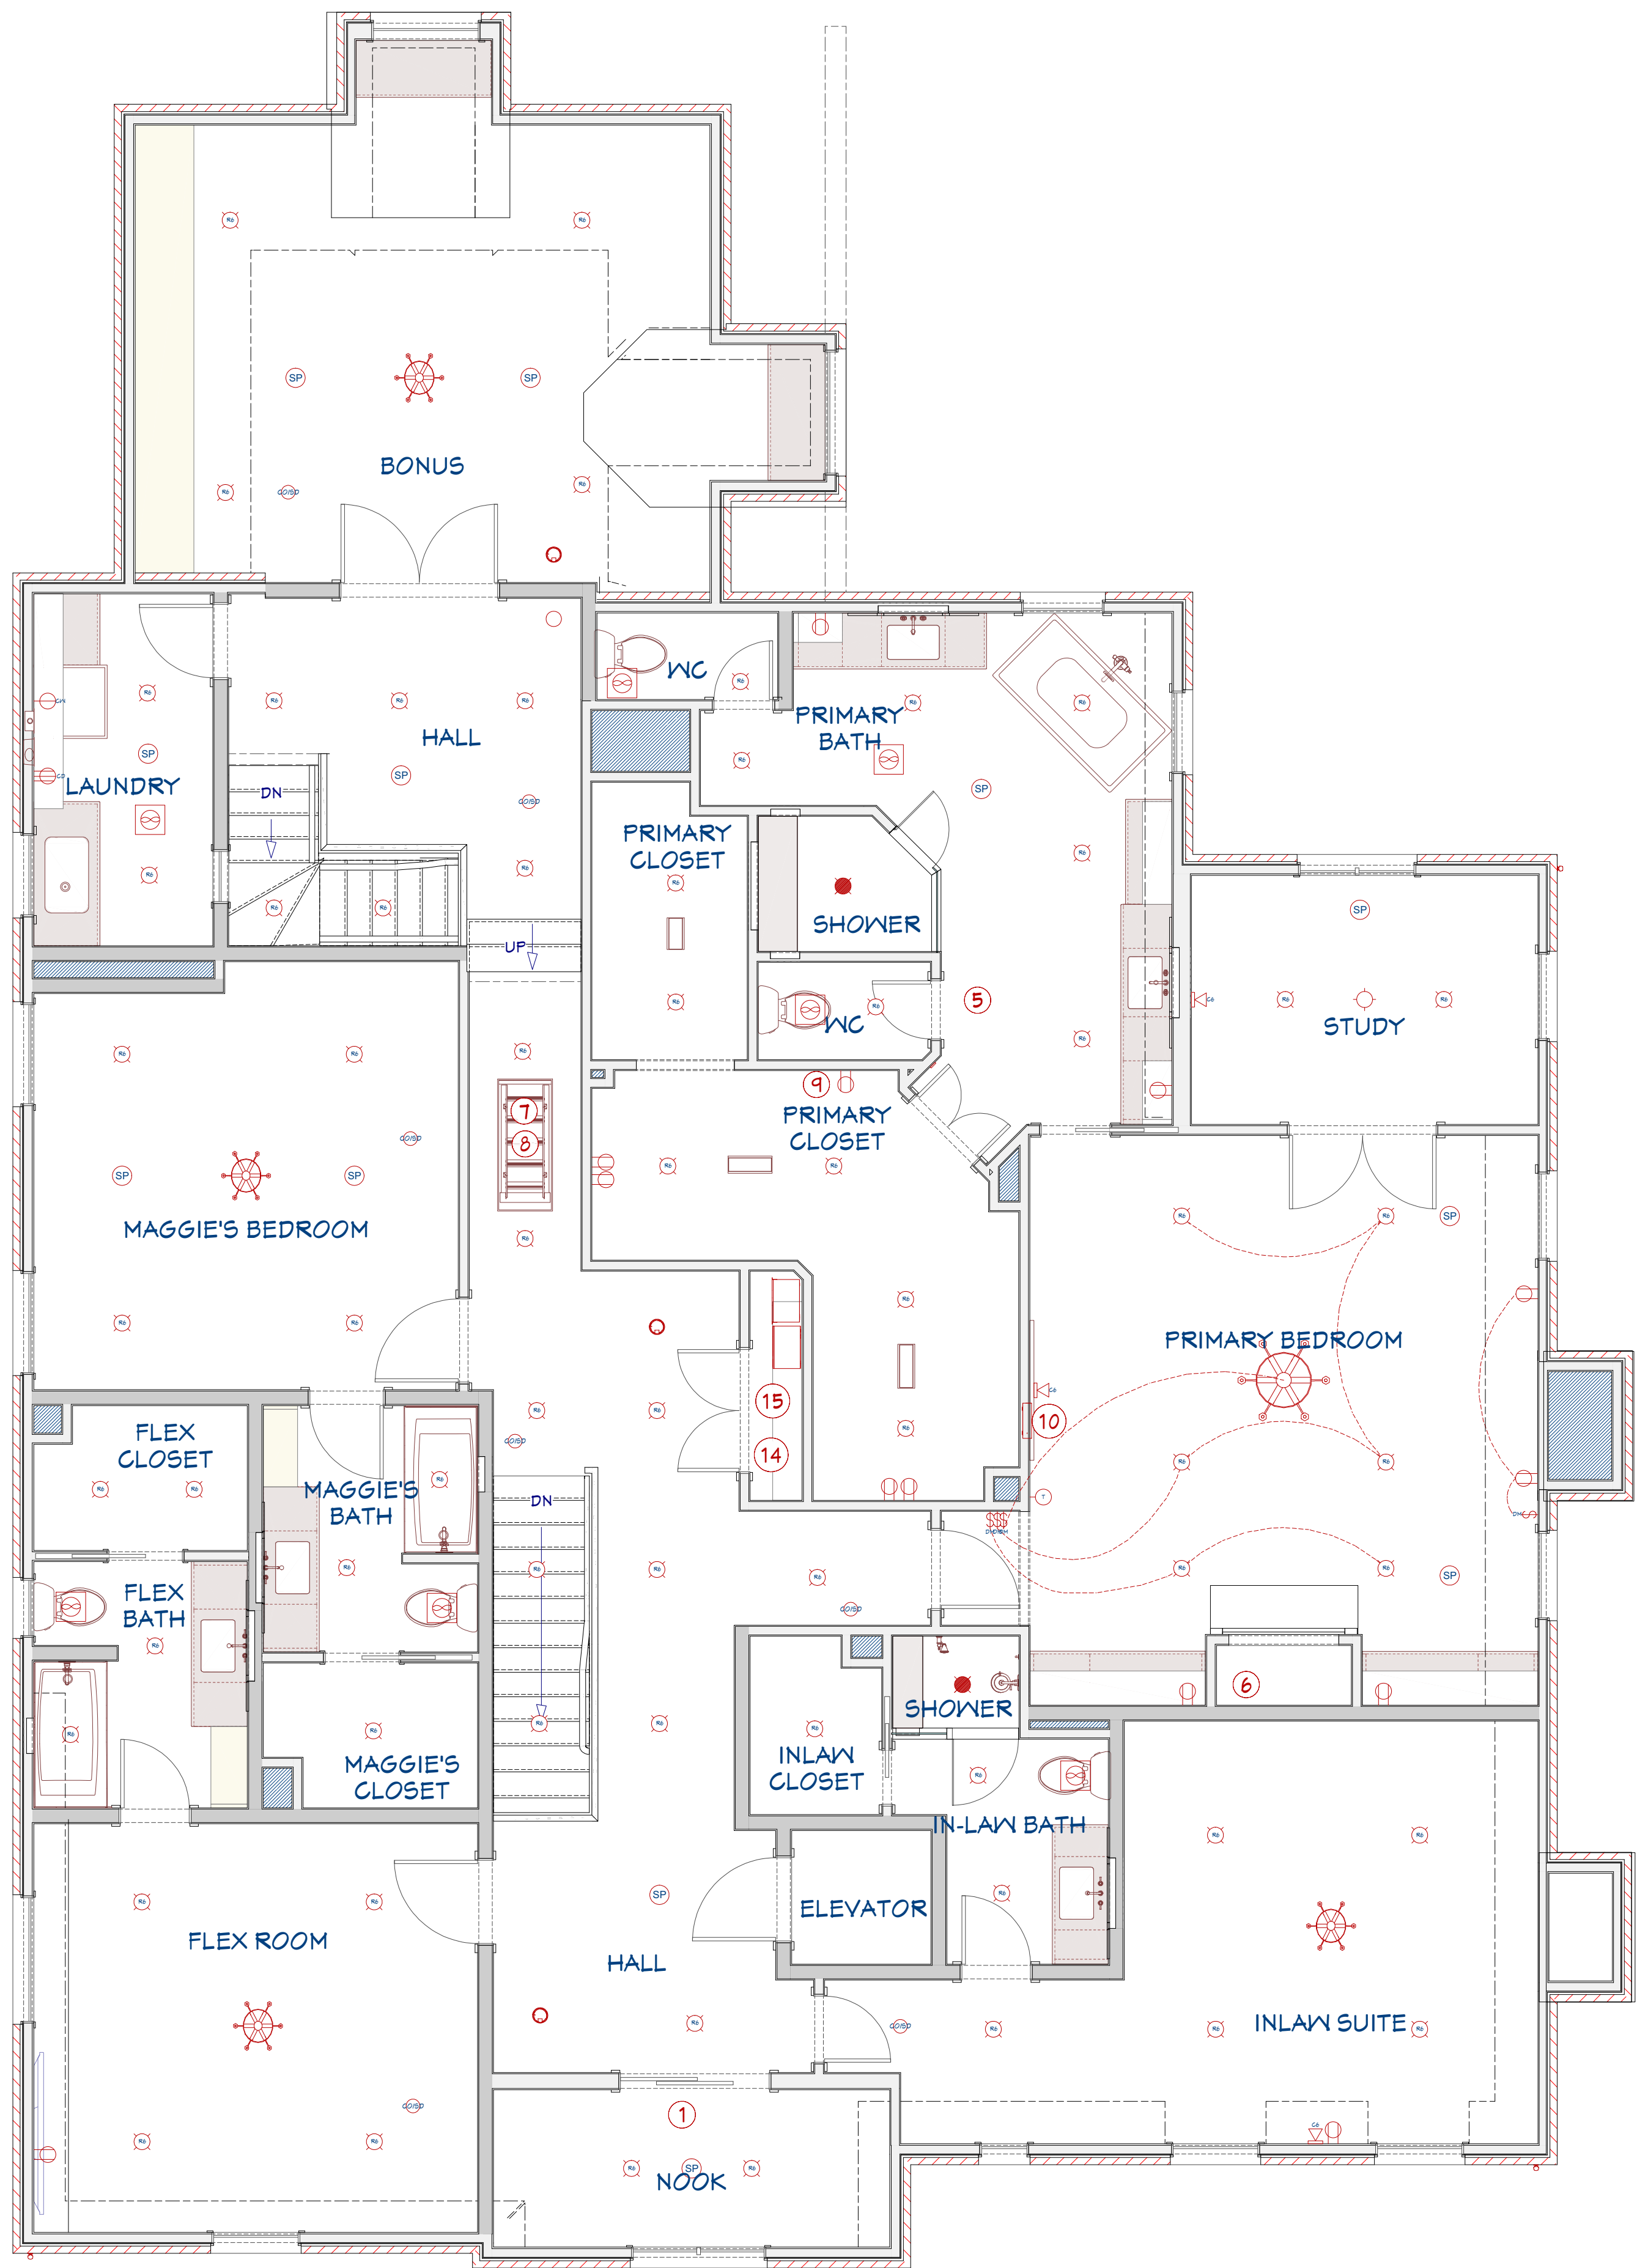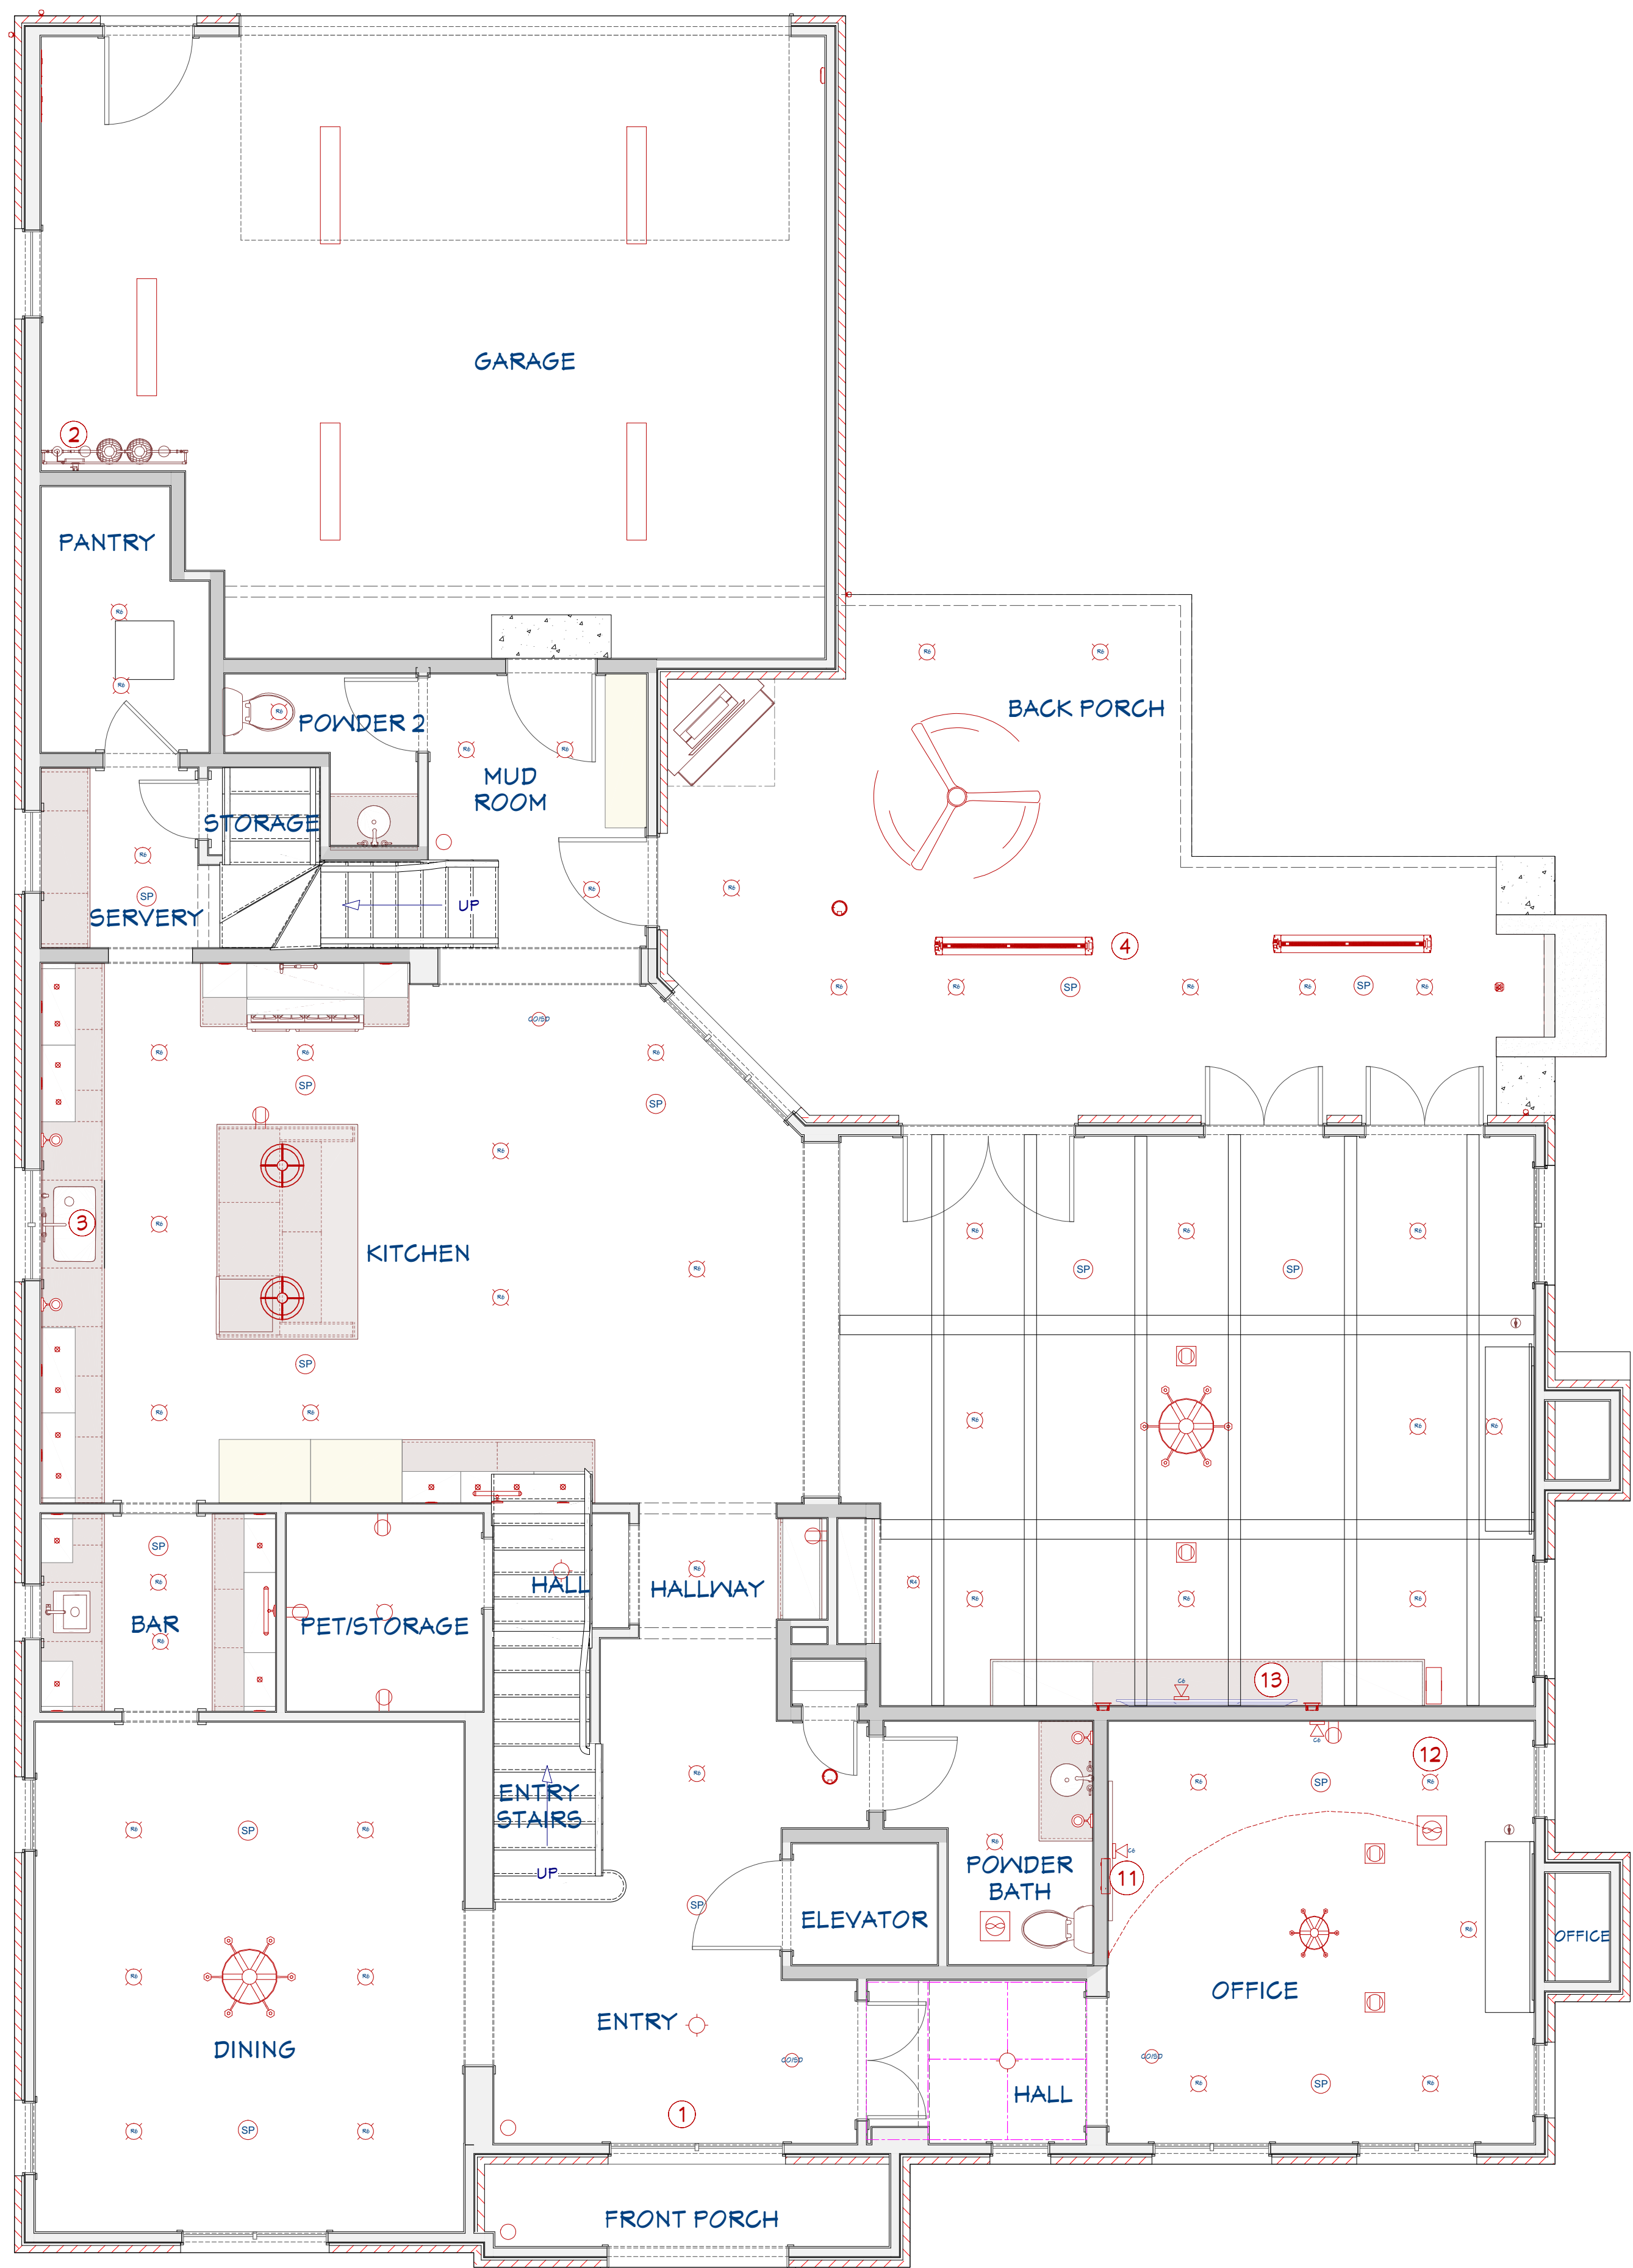

3D VIEWS ARE NOT TO SCALE AND MAY NOT REFLECT EXACTLY WHAT IS AVAILABLE FOR THE PROJECT. RENDER VIEWS ARE REPRESENTATIONS OF WHAT THE VIEW COULD LOOK LIKE, NOT WHAT IT WILL LOOK LIKE. 2D VIEWS ALWAYS SUPERCEDE 3D VIEWS

Renowned Group
4848 Lemmon Ave, suite 106,
Dallas, TX, 75219
PHONE: 972-252-7122 EMAIL: info@renowned-group.com

LICENSE NUMBER:
BU118842

REMODEL PLANS FOR:
Plassick Morton
3504 Villanova St
Dallas, TX, 75225

PAGE TITLE:
MEP Plan

DRAWN BY:
MB

DATE:
5/7/25

SCALE:
1/4" = 1'0"

SHEET #:
3

ELECTRICAL SCHEDULE

ROOM NAME	NUMBER	QTY	DESCRIPTION	COMMENTS	FLOOR ATTACHED TO	MANUFACTURER
BACK PORCH	E01	3	SECURITY CAMERA 1 WALL MOUNT		1	WALL
BACK PORCH	E02	9	SECURITY CAMERA 1 WALL MOUNT		2	WALL
BACK PORCH	E03	1	SECURITY CAMERA 1 WALL MOUNT		1	WALL
BACK PORCH	E04	6	SECURITY CAMERA 1 WALL MOUNT	EXISTING 1 BOX IN BLANK PLATE EXISTING TO REMAIN UNLESS DAMAGED OR DISCOLORED.	1	CEILING
BACK PORCH	E05	1	SECURITY CAMERA 1 WALL MOUNT	REPLACE WITH NEW TBD	1	CEILING
BACK PORCH	E06	2	HEATSCOPE VISION3200	220 - 240V AC, 50/60 HZ, 13 A1A	1	CEILING
BACK PORCH	E07	2	SECURITY CAMERA 1 WALL MOUNT	NEW	1	CEILING
BACK PORCH	E08	1	SECURITY CAMERA 1 WALL MOUNT		1	WALL
BACK PORCH	E09	1	UT PRO MAP		1	CEILING
BACK PORCH	E10	2	6" LED DOWNLIGHT	EXISTING TO REMAIN UNLESS DAMAGED OR DISCOLORED.	1	CEILING
BACK PORCH	E11	1	ART LIGHT SCORGE	NEW SCORGE TBD	1	WALL
BACK PORCH	E12	4	LED FLOOR LIGHT		1	WALL
BACK PORCH	E13	4	DUPLEX RECEPTACLE, 15A	40" OFF FF, CENTER ON WALL CAB. HORIZONTAL.	1	WALL
BONUS	E14	4	6" LED DOWNLIGHT	EXISTING TO REMAIN UNLESS DAMAGED OR DISCOLORED.	2	CEILING
BONUS	E15	1	CHANDIELIER	REPLACE WITH NEW TBD. CHECK FOR CENTER ON DOORWAY	2	CEILING
BONUS	E16	1	CO/SMOKE DETECTOR	EXISTING SMOKE/CO2	2	CEILING
BONUS	E17	1	UT PRO MAP		2	CEILING
BONUS	E18	6	6" LED DOWNLIGHT	EXISTING TO REMAIN UNLESS DAMAGED OR DISCOLORED.	1	CEILING
DINING	E19	1	SECURITY CAMERA 1 WALL MOUNT	REPLACE WITH NEW TBD	1	CEILING
ENTRY	E20	1	6" LED DOWNLIGHT	CENTER EXISTING ON ENTRY LIGHT	1	CEILING
ENTRY	E21	1	CO/SMOKE DETECTOR	EXISTING SMOKE/CO2	1	CEILING
ENTRY	E22	1	EXISTING PENDANT	EXISTING TO REMAIN	1	CEILING
ENTRY	E23	1	DOME CAMERA		1	FLOOR
ENTRY	E24	4	6" LED DOWNLIGHT	EXISTING TO REMAIN UNLESS DAMAGED OR DISCOLORED.	2	CEILING
ENTRY STAIRS	E25	2	6" LED DOWNLIGHT	REPLACE WITH NEW PANASONIC WHISPER QUIET (3000K), DIMMABLE	2	CEILING
FLEX BATH	E26	1	EXHAUST FAN	PL PORTRAY CABINET, 24" X 36"	2	CEILING
FLEX BATH	E27	1	6" LED DOWNLIGHT	EXISTING TO REMAIN UNLESS DAMAGED OR DISCOLORED.	2	CEILING
FLEX BATH	E28	1	3D SOLID	VESPER LIGHTING, 2-3/4" X 3/8" X 4-9/16", MIDLINE, WARM WHITE (3000K), DIMMABLE	2	CEILING
FLEX BATH	E29	1	3D SOLID	PL PORTRAY CABINET, 24" X 36"	2	CEILING
FLEX CLOSET	E30	2	6" LED DOWNLIGHT	EXISTING TO REMAIN UNLESS DAMAGED OR DISCOLORED.	2	CEILING
FLEX ROOM	E31	2	6" LED DOWNLIGHT	EXISTING TO REMAIN UNLESS DAMAGED OR DISCOLORED.	2	CEILING
FLEX ROOM	E32	1	CHANDIELIER	REPLACE WITH NEW TBD	2	CEILING
FLEX ROOM	E33	1	CO/SMOKE DETECTOR	EXISTING SMOKE/CO2	2	CEILING
FLEX ROOM	E34	1	CHANDIELIER	REPLACE WITH NEW TBD	2	CEILING
FLEX ROOM	E35	1	CHANDIELIER	REPLACE WITH NEW TBD	2	CEILING
FLEX ROOM	E36	1	CHANDIELIER	REPLACE WITH NEW TBD	2	CEILING
FRONT PORCH	E37	1	DOME CAMERA		2	WALL
GARAGE	E38	2	ELECTRICAL PANEL - RECESSED		2	WALL
GARAGE	E39	5	EXISTING FLUORESCENT LIGHT	EXISTING TO REMAIN	1	WALL
GARAGE	E40	1	WATER VALVE		1	WALL
HALL	E41	10	WATER VALVE	EXISTING TO REMAIN UNLESS DAMAGED OR DISCOLORED.	1	WALL
HALL	E42	1	CO/SMOKE DETECTOR	EXISTING SMOKE/CO2	1	CEILING
HALL	E43	1	EXISTING PENDANT	WITH NEW TBD	1	CEILING
HALL	E44	2	6" LED DOWNLIGHT	RELOCATE EXISTING	2	CEILING
HALL	E45	1	DOME CAMERA		2	CEILING
HALL	E46	1	6" LED DOWNLIGHT	CENTER EXISTING ON ENTRY LIGHT	1	CEILING
HALLWAY	E47	1	6" LED DOWNLIGHT	EXISTING TO REMAIN UNLESS DAMAGED OR DISCOLORED.	1	FLOOR
HALLWAY	E48	1	DECORATOR	OUTLET FOR 40M 24V PLUG IN DRIVER. HORIZONTAL.	1	WALL
IN-LAN BATH	E49	2	6" LED DOWNLIGHT	EXISTING TO REMAIN UNLESS DAMAGED OR DISCOLORED.	2	CEILING
IN-LAN BATH	E50	1	EXHAUST FAN	RELOCATE AS NEEDED TO ALIGN WITH CENTER OF FRIDGE/ FREEZER	2	CEILING
IN-LAN BATH	E51	2	3D SOLID	VESPER LIGHTING, 2-3/4" X 3/8" X 4-9/16", MIDLINE, WARM WHITE (3000K), DIMMABLE	2	CEILING
IN-LAN BATH	E52	1	3D SOLID	PL PORTRAY CABINET, 24" X 36"	2	CEILING
IN-LAN CLOSET	E53	1	6" LED DOWNLIGHT	EXISTING TO REMAIN UNLESS DAMAGED OR DISCOLORED.	2	CEILING
IN-LAN SUITE	E54	2	6" LED DOWNLIGHT	EXISTING TO REMAIN UNLESS DAMAGED OR DISCOLORED.	2	CEILING
IN-LAN SUITE	E55	1	CHANDIELIER	REPLACE WITH NEW TBD	2	CEILING
IN-LAN SUITE	E56	1	CHANDIELIER	REPLACE WITH NEW TBD	2	CEILING
IN-LAN SUITE	E57	3	6" LED DOWNLIGHT	RELOCATE EXISTING	2	CEILING
IN-LAN SUITE	E58	1	CAT6		2	WALL
IN-LAN SUITE	E59	1	DUPLEX RECEPTACLE, 15A		2	WALL
KITCHEN	E60	1	DECORATOR	RECESSED TV PLUG	2	WALL
KITCHEN	E61	6	6" LED DOWNLIGHT	EXISTING TO REMAIN UNLESS DAMAGED OR DISCOLORED.	1	CEILING
KITCHEN	E62	1	6" LED DOWNLIGHT	RELOCATE AS NEEDED TO ALIGN WITH CENTER OF FRIDGE/ FREEZER	1	CEILING
KITCHEN	E63	1	ART LIGHT SCORGE	NEW SCORGE TBD	1	WALL
KITCHEN	E64	1	CO/SMOKE DETECTOR	EXISTING SMOKE/CO2	1	CEILING
KITCHEN	E65	10	DUPLEX		1	WALL
KITCHEN	E66	1	LED FLOOR LIGHT	NEW SCORGE TBD	1	WALL
KITCHEN	E67	1	SCORGE	NEW TBD	1	CEILING
KITCHEN	E68	2	PENDANT	NEW TBD	1	CEILING
KITCHEN	E69	1	LED FLOOR LIGHT	RELOCATE EXISTING	1	CEILING
KITCHEN	E70	1	6" LED DOWNLIGHT	CENTER EXISTING ON ENTRY LIGHT	1	CEILING
KITCHEN	E71	1	DUPLEX RECEPTACLE, 15A	40" OFF FF, CENTER ON WALL CAB. HORIZONTAL.	1	WALL
KITCHEN	E72	8	DECORATOR		1	WALL
LAUNDRY	E73	1	CLOTHES DRYER RECEPTACLE		2	WALL
LAUNDRY	E74	1	CLOTHES WASHER RECEPTACLE		2	WALL
LAUNDRY	E75	1	EXHAUST FAN	REPLACE WITH NEW PANASONIC WHISPER QUIET	2	CEILING
LAUNDRY	E76	1	6" LED DOWNLIGHT	REPLACE WITH NEW UNLESS DAMAGED OR DISCOLORED.	2	CEILING
LIVING	E77	1	6" LED DIRECTIONAL DOWNLIGHT	REPLACE WITH NEW	2	CEILING
LIVING	E78	8	6" LED DOWNLIGHT	EXISTING TO REMAIN UNLESS DAMAGED OR DISCOLORED.	1	CEILING
LIVING	E79	1	CHANDIELIER	REPLACE WITH NEW TBD	1	CEILING
LIVING	E80	1	DIRECTIONAL DOWN LIGHT 4		1	FLOOR
LIVING	E81	2	DUPLEX FLOOR MOUNTED		1	FLOOR
LIVING	E82	2	SONOS INWALL SPEAKER		1	FLOOR
LIVING	E83	1	SONOS-SUB		1	FLOOR
LIVING	E84	1	CAT6		1	FLOOR
MAGGIE'S BATH	E85	1	6" LED DOWNLIGHT	EXISTING TO REMAIN UNLESS DAMAGED OR DISCOLORED.	2	CEILING
MAGGIE'S BATH	E86	1	6" LED DOWNLIGHT	RELOCATE EXISTING PANASONIC WHISPER QUIET	2	CEILING
MAGGIE'S BATH	E87	1	3D SOLID	PL PORTRAY CABINET, 24" X 36"	2	CEILING
MAGGIE'S BATH	E88	1	3D SOLID	VESPER LIGHTING, 2-3/4" X 3/8" X 4-9/16", MIDLINE, WARM WHITE (3000K), DIMMABLE	2	CEILING
MAGGIE'S BATH	E89	2	3D SOLID	EXISTING TO REMAIN UNLESS DAMAGED OR DISCOLORED.	2	CEILING
MAGGIE'S BEDROOM	E90	4	6" LED DOWNLIGHT	EXISTING TO REMAIN UNLESS DAMAGED OR DISCOLORED.	2	CEILING
MAGGIE'S BEDROOM	E91	1	CO/SMOKE DETECTOR	EXISTING SMOKE/CO2	2	CEILING
MAGGIE'S BEDROOM	E92	1	CHANDIELIER	RELOCATE EXISTING	2	CEILING
MAGGIE'S CLOSET	E93	1	6" LED DOWNLIGHT	EXISTING TO REMAIN UNLESS DAMAGED OR DISCOLORED.	2	CEILING
MUD ROOM	E94	3	6" LED DOWNLIGHT	EXISTING TO REMAIN UNLESS DAMAGED OR DISCOLORED.	1	CEILING
MUD ROOM	E95	1	DOME CAMERA		1	FLOOR
NOOK	E96	2	6" LED DOWNLIGHT	EXISTING TO REMAIN UNLESS DAMAGED OR DISCOLORED.	2	CEILING
OFFICE	E97	4	6" LED DOWNLIGHT	EXISTING TO REMAIN UNLESS DAMAGED OR DISCOLORED.	1	CEILING
OFFICE	E98	1	DUPLEX FLOOR MOUNTED		1	CEILING
OFFICE	E99	1	RECEPTACLE	EXISTING FLOOR PLUG - REPLACE WITH NEW	1	FLOOR
OFFICE	E100	1	6" LED DIRECTIONAL DOWNLIGHT	REPLACE WITH NEW	1	CEILING
OFFICE	E101	1	CHANDIELIER	ADD J BOX FOR NEW CHANDIELIER	1	CEILING
OFFICE	E102	1	EXHAUST FAN	VENT TO EXTERIOR	1	CEILING
OFFICE	E103	1	DUPLEX FLOOR MOUNTED	EXISTING FLOOR PLUG - REPLACE WITH NEW. ADD CAT6	1	FLOOR
OFFICE	E104	1	CAT6		1	CABINET
OFFICE	E105	1	RECESSED MEDIA ENCLOSURE		1	WALL
OFFICE	E106	1	RECESSED SINGLE DIMMER		1	WALL
OFFICE	E107	1	CAT6		1	WALL
OFFICE	E108	1	DUPLEX RECEPTACLE, 15A	RECESSED TV PLUG	1	WALL
OFFICE	E109	1	DECORATOR	EXISTING TO REMAIN UNLESS DAMAGED OR DISCOLORED.	2	CEILING
OFFICE	E110	2	6" LED DOWNLIGHT	EXISTING TO REMAIN UNLESS DAMAGED OR DISCOLORED.	1	CEILING
PANTRY	E111	2	6" LED DOWNLIGHT	REPLACE WITH NEW TBD	1	CEILING
PET STORAGE	E112	3	DUPLEX RECEPTACLE, 15A	EXISTING TO REMAIN UNLESS DAMAGED OR DISCOLORED.	1	WALL
PET STORAGE	E113	1	DECORATOR	EXISTING TO REMAIN UNLESS DAMAGED OR DISCOLORED.	1	CEILING
PONDER 2	E114	1	6" LED DOWNLIGHT	EXISTING TO REMAIN UNLESS DAMAGED OR DISCOLORED.	1	CEILING
PONDER BATH	E115	1	6" LED DOWNLIGHT	REPLACE WITH NEW PANASONIC WHISPER QUIET	1	CEILING
PONDER BATH	E116	1	EXHAUST FAN	REPLACE WITH NEW PANASONIC WHISPER QUIET	1	CEILING
PRIMARY BATH	E117	1	EXHAUST FAN	REPLACE WITH NEW PANASONIC WHISPER QUIET	2	CEILING
PRIMARY BATH	E118	1	CHANDIELIER	REPLACE WITH NEW PANASONIC WHISPER QUIET	2	CEILING
PRIMARY BATH	E119	1	CHANDIELIER	REPLACE WITH NEW PANASONIC WHISPER QUIET	2	CEILING
PRIMARY BATH	E120	5	6" LED DOWNLIGHT	RELOCATE EXISTING	2	WALL
PRIMARY BATH	E121	2	DUPLEX RECEPTACLE, 15A	EXISTING TO REMAIN UNLESS DAMAGED OR DISCOLORED.	2	CEILING
PRIMARY BATH	E122	2	DECORATOR	50" OFF FF HORIZONTAL	2	WALL
PRIMARY BATH	E123	4	3D SOLID	PL PORTRAY CABINET, 24" X 36"	2	WALL
PRIMARY BATH	E124	1	CHANDIELIER	VESPER LIGHTING, 2-3/4" X 3/8" X 4-9/16", MIDLINE, WARM WHITE (3000K), DIMMABLE	2	CEILING
PRIMARY BEDROOM	E125	1	THERMOSTAT		2	CEILING
PRIMARY BEDROOM	E126	2	6" LED DOWNLIGHT	RELOCATE EXISTING	2	CEILING
PRIMARY BEDROOM	E127	1	SWITCH DECOR DIMMER		2	WALL
PRIMARY BEDROOM	E128	2	DUPLEX RECEPTACLE, 15A	CONTROLS BOTTOM PLUG ON DUPLEX OUTLETS	2	WALL
PRIMARY BEDROOM	E129	2	DECORATOR		2	WALL
PRIMARY BEDROOM	E130	2	DUPLEX RECEPTACLE, 15A	OUTLET FOR 40M 24V PLUG IN DRIVER. HORIZONTAL.	2	WALL
PRIMARY BEDROOM	E131	4	6" LED DOWNLIGHT	EXISTING TO REMAIN UNLESS DAMAGED OR DISCOLORED.	2	CEILING
PRIMARY BEDROOM	E132	1	CAT6		2	CABINET
PRIMARY BEDROOM	E133	1	RECESSED MEDIA ENCLOSURE		2	WALL
PRIMARY CLOSET	E134	6	6" LED DOWNLIGHT	EXISTING TO REMAIN UNLESS DAMAGED OR DISCOLORED.	2	CEILING
PRIMARY CLOSET	E135	1	MAG SLO 4 LIGHT	SLO MULTIPLE LED 4 - POSITIONING, DEPENDANT ON JOIST SPACE	2	CEILING
PRIMARY CLOSET	E136	1	MAG SLO 4 LIGHT	SLO MULTIPLE LED 3 - POSITIONING, DEPENDANT ON JOIST SPACE	2	CEILING
PRIMARY CLOSET	E137	1	MAG SLO 4 LIGHT	SLO MULTIPLE LED 4 - POSITIONING, DEPENDANT ON JOIST SPACE	2	CEILING
PRIMARY CLOSET	E138	1	DUPLEX RECEPTACLE, 15A	SEE CLOSET PLAN FOR OUTLET LOCATION	2	WALL
PRIMARY CLOSET	E139	4	DECORATOR		2	WALL
PRIMARY CLOSET	E140	1	DUPLEX RECEPTACLE, 15A	OUTLET FOR COSMETICS FRIDGE - HEIGHT TBD	2	WALL
PRIMARY CLOSET	E141	1	DECORATOR	EXISTING TO REMAIN UNLESS DAMAGED OR DISCOLORED.	1	CEILING
PRIMARY CLOSET	E142	2	6" LED DOWNLIGHT	RELOCATE EXISTING	2	CEILING
PRIMARY CLOSET	E143	1	EXISTING SEMI-FLUSH MOUNT	WITH NEW TBD	2	CEILING
PRIMARY CLOSET	E144	1	CAT6		2	WALL
PRIMARY CLOSET	E145	1	UNFI DREAM MACHINE PRO / US		2	FLOOR
UNSPECIFIED	E146	1	UNFI DREAM MACHINE PRO / US		2	FLOOR
UNSPECIFIED	E147	2	6" LED DOWNLIGHT	EXISTING TO REMAIN UNLESS DAMAGED OR DISCOLORED.	2	CEILING
UNSPECIFIED	E148	2	EXHAUST FAN	REPLACE WITH NEW PANASONIC WHISPER QUIET	2	CEILING

MEP NOTE SCHEDULE	
①	REPLACE ALL PLUGS AND SWITCHES
②	MAIN WATER LOOP FOR WATER FILTER & SOFTNER
③	REVERSE OSMOSIS WITH WATER LINES TO POT FILLER, FREEZER, AND ICE MAKER
④	220 FOR HEATSCOPE HEATERS SEE SPECS
⑤	SCHLUTER DITRA HEATED FLOOR
⑥	GAS LINE FOR FIRE ROCK VENT-LESS MASONRY FIREPLACE. SEE SPECS
⑦	DEMO AND REPLACE 50 GALLON WATER HEATERS WITH (2) NAVIEN NPE-180A2 150,000 BTU CONDENSING PREMIUM GAS TANKLESS WATER HEATER
⑧	DEMO AND REPLACE 2-5 TON A/C GAS HEAT 1-3 TON A/C GAS HEAT SUPPLY AND RETURN PLENUM WITH FILTER RACK WITH TRANE UNITS
⑨	16 SEER 2 STAGE COOL AND HEAT
⑩	RELOCATE FIBER, DATA, AND SPEAKER WIRE. ELIMINATE COAX.
⑪	2 SONOS AMPS IN MEDIA BOX
⑫	1 SONOS AMP IN MEDIA BOX
⑬	CIGAR ROOM EXHAUST & VENT FAN SEE BUILDER/TREND DOCUMENTS/ HVAC & AIR PURIFICATION/ OFFICE CIGAR SMOKE EXTRACTOR
⑭	SPEAKER WIRE FOR ALL DOWNSTAIRS SPEAKERS EXPECT STUDY RUN TO BASE CABINETS
⑮	SPEAKER WIRE FOR ALL UPSTAIRS SPEAKERS EXPECT PRIMARY.
⑯	AV HUB - DATA, INTERNET, & CAMERA WIRES

Electrical Schedule

DRAWN BY:

MB

DATE:

5/7/25

SCALE:

NA

SHEET #:

4

REMODEL PLANS FOR:

Plassick Morton
3504 Villanova St
Dallas, TX, 75225

LICENSE NUMBER:

BU118842

3D VIEWS ARE NOT TO SCALE AND MAY NOT REFLECT EXACTLY WHAT IS AVAILABLE FOR THE PROJECT. RENDER VIEWS ARE REPRESENTATIONS OF WHAT THE VIEW COULD LOOK LIKE, NOT WHAT IT WILL LOOK LIKE. 2D VIEWS ALWAYS SUPERCEDE 3D VIEWS

Renowned Group

4848 Lemmon Ave, suite 106,
Dallas, TX, 75219

PHONE: 972-232-7122 EMAIL: info@renowned-group.com

NOTE SCHEDULE	
①	NEW RAILING AND BALLUSTERS PER INSPIRATION
②	WALLPAPER TO REMAIN. BRUSH TRIM.
③	ALL FINISHES TO REMAIN. BRUSH TRIM.
④	FIX SQUEAKING IN ENTRY BEFORE STAINING. CHECK ALL LEVELS
⑤	FRAME STORAGE ROOM & INSTALL FLUSH DOOR
⑥	ADD HINGED DOOR TO MATCH EXISTING
⑦	REDUCE OUTDOOR BAR TO COUNTER HEIGHT. COUNTERTOP TBD
⑧	REMOVE WOODEN STEP AND REPLACE WITH MASONRY BLOCK. PREP FOR EPOXY FLOORING BY OTHERS.
⑨	ZERO THRESHOLD SHOWER W/ 1/2" CAMBRIA SHOWER DOOR SWEEP
⑩	FASTEN GARAGE DOOR HEADER TRIM
⑪	EXISTING ISOKERN STANDARD 48" CAMBRIA HERMITAGE HEARTH. REPLACE FIRE BRICK AND SURROUND W/ STANDARD BOND IN LIGHT COLOR LIGHT MORTAR. AGAR 1 PIECE MANTLE & PILLASTER UNIT.
⑫	EXISTING ISOKERN STANDARD 48" FIREPLACE CAMBRIA HERMITAGE SURROUND & HEARTH. ALDINE 1 PIECE MANTLE & PILLASTER UNIT
⑭	FRAME AND INSTALL POCKET DOOR. CAVITY SLIDER.
⑮	DEMO ORG & WHITE BOX IN PREPARATION FOR CALIFORNIA CLOSETS
⑯	FRAME OPENING PER CLOSET SPECS.
⑰	NEW ISOKERN STANDARD 36" FIREPLACE CAMBRIA HALEY SURROUND & HEARTH. ALDINE 1 PIECE MANTLE & PILLASTER UNIT
⑱	REMOVE TV & INSTALL SHELF TO MATCH EXISTING
⑲	ADD INSET DOORS TO UPPER AND LOWER OPENINGS
⑳	FRAME NICHE FOR ROBERN MEDICINE CABINET AND RECESSED LIGHTS. 28 3/4" W X 35 1/4 H



7 OUTDOOR BAR



19 MUD / GARAGE ENTRY




8 GARAGE



SFP
5 Study FP
3/4 in = 1 ft



18 PLAYROOM

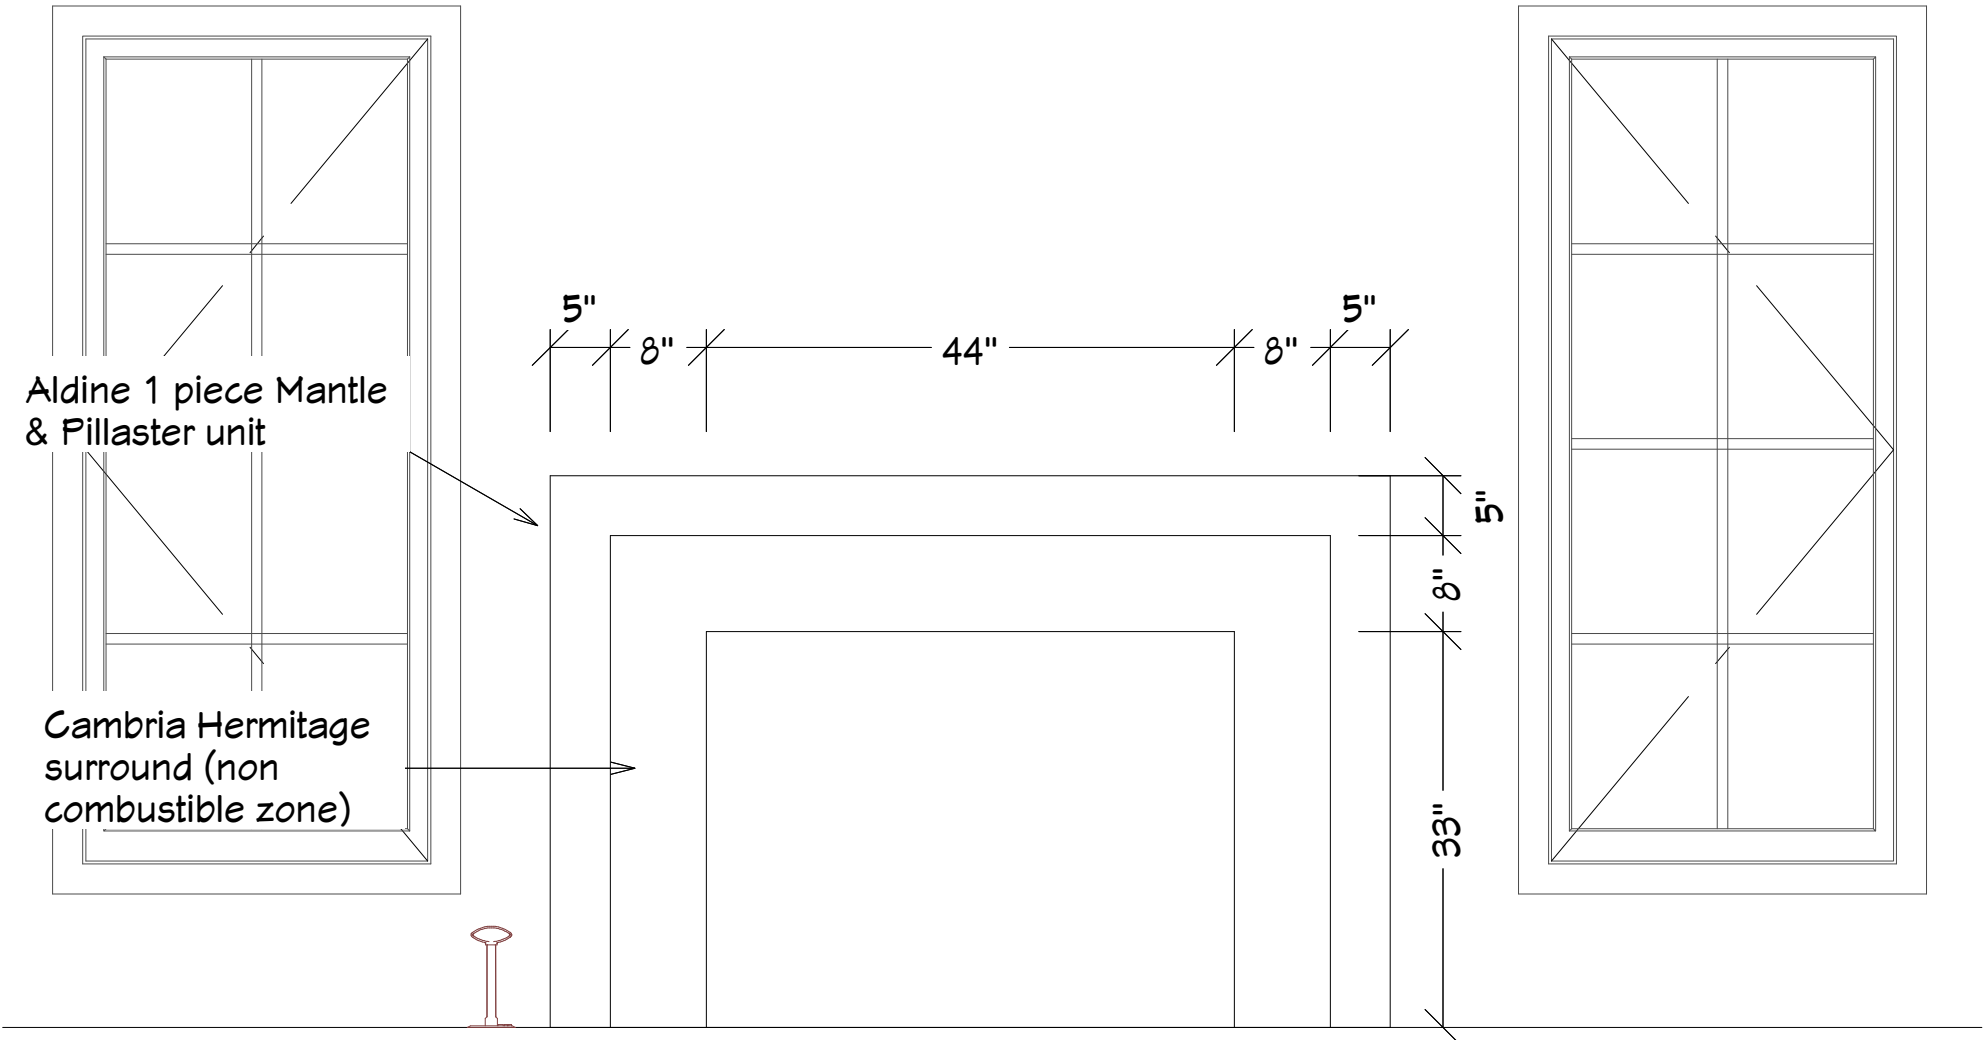

12 STUDY FIREPLACE



11 LIVING ROOM

3D VIEWS ARE NOT TO SCALE AND MAY NOT REFLECT EXACTLY WHAT IS AVAILABLE FOR THE PROJECT. RENDER VIEWS ARE REPRESENTATIONS OF WHAT THE VIEW COULD LOOK LIKE, NOT WHAT IT WILL LOOK LIKE. 2D VIEWS ALWAYS SUPERCEDE 3D VIEWS

Renowned Group
4848 Lemmon Ave, suite 106,
Dallas, TX, 75219
PHONE: 972-252-7122 EMAIL: info@renowned-group.com

LICENSE NUMBER:
BU118842

REMODEL PLANS FOR:
Plassick Morton
3504 Villanova St
Dallas, TX, 75225


PAGE TITLE:
**General Notes, Code Info,
Symbols, Keys**

DRAWN BY:
MB

DATE:
5/7/25

SCALE:
NA

SHEET #:
5

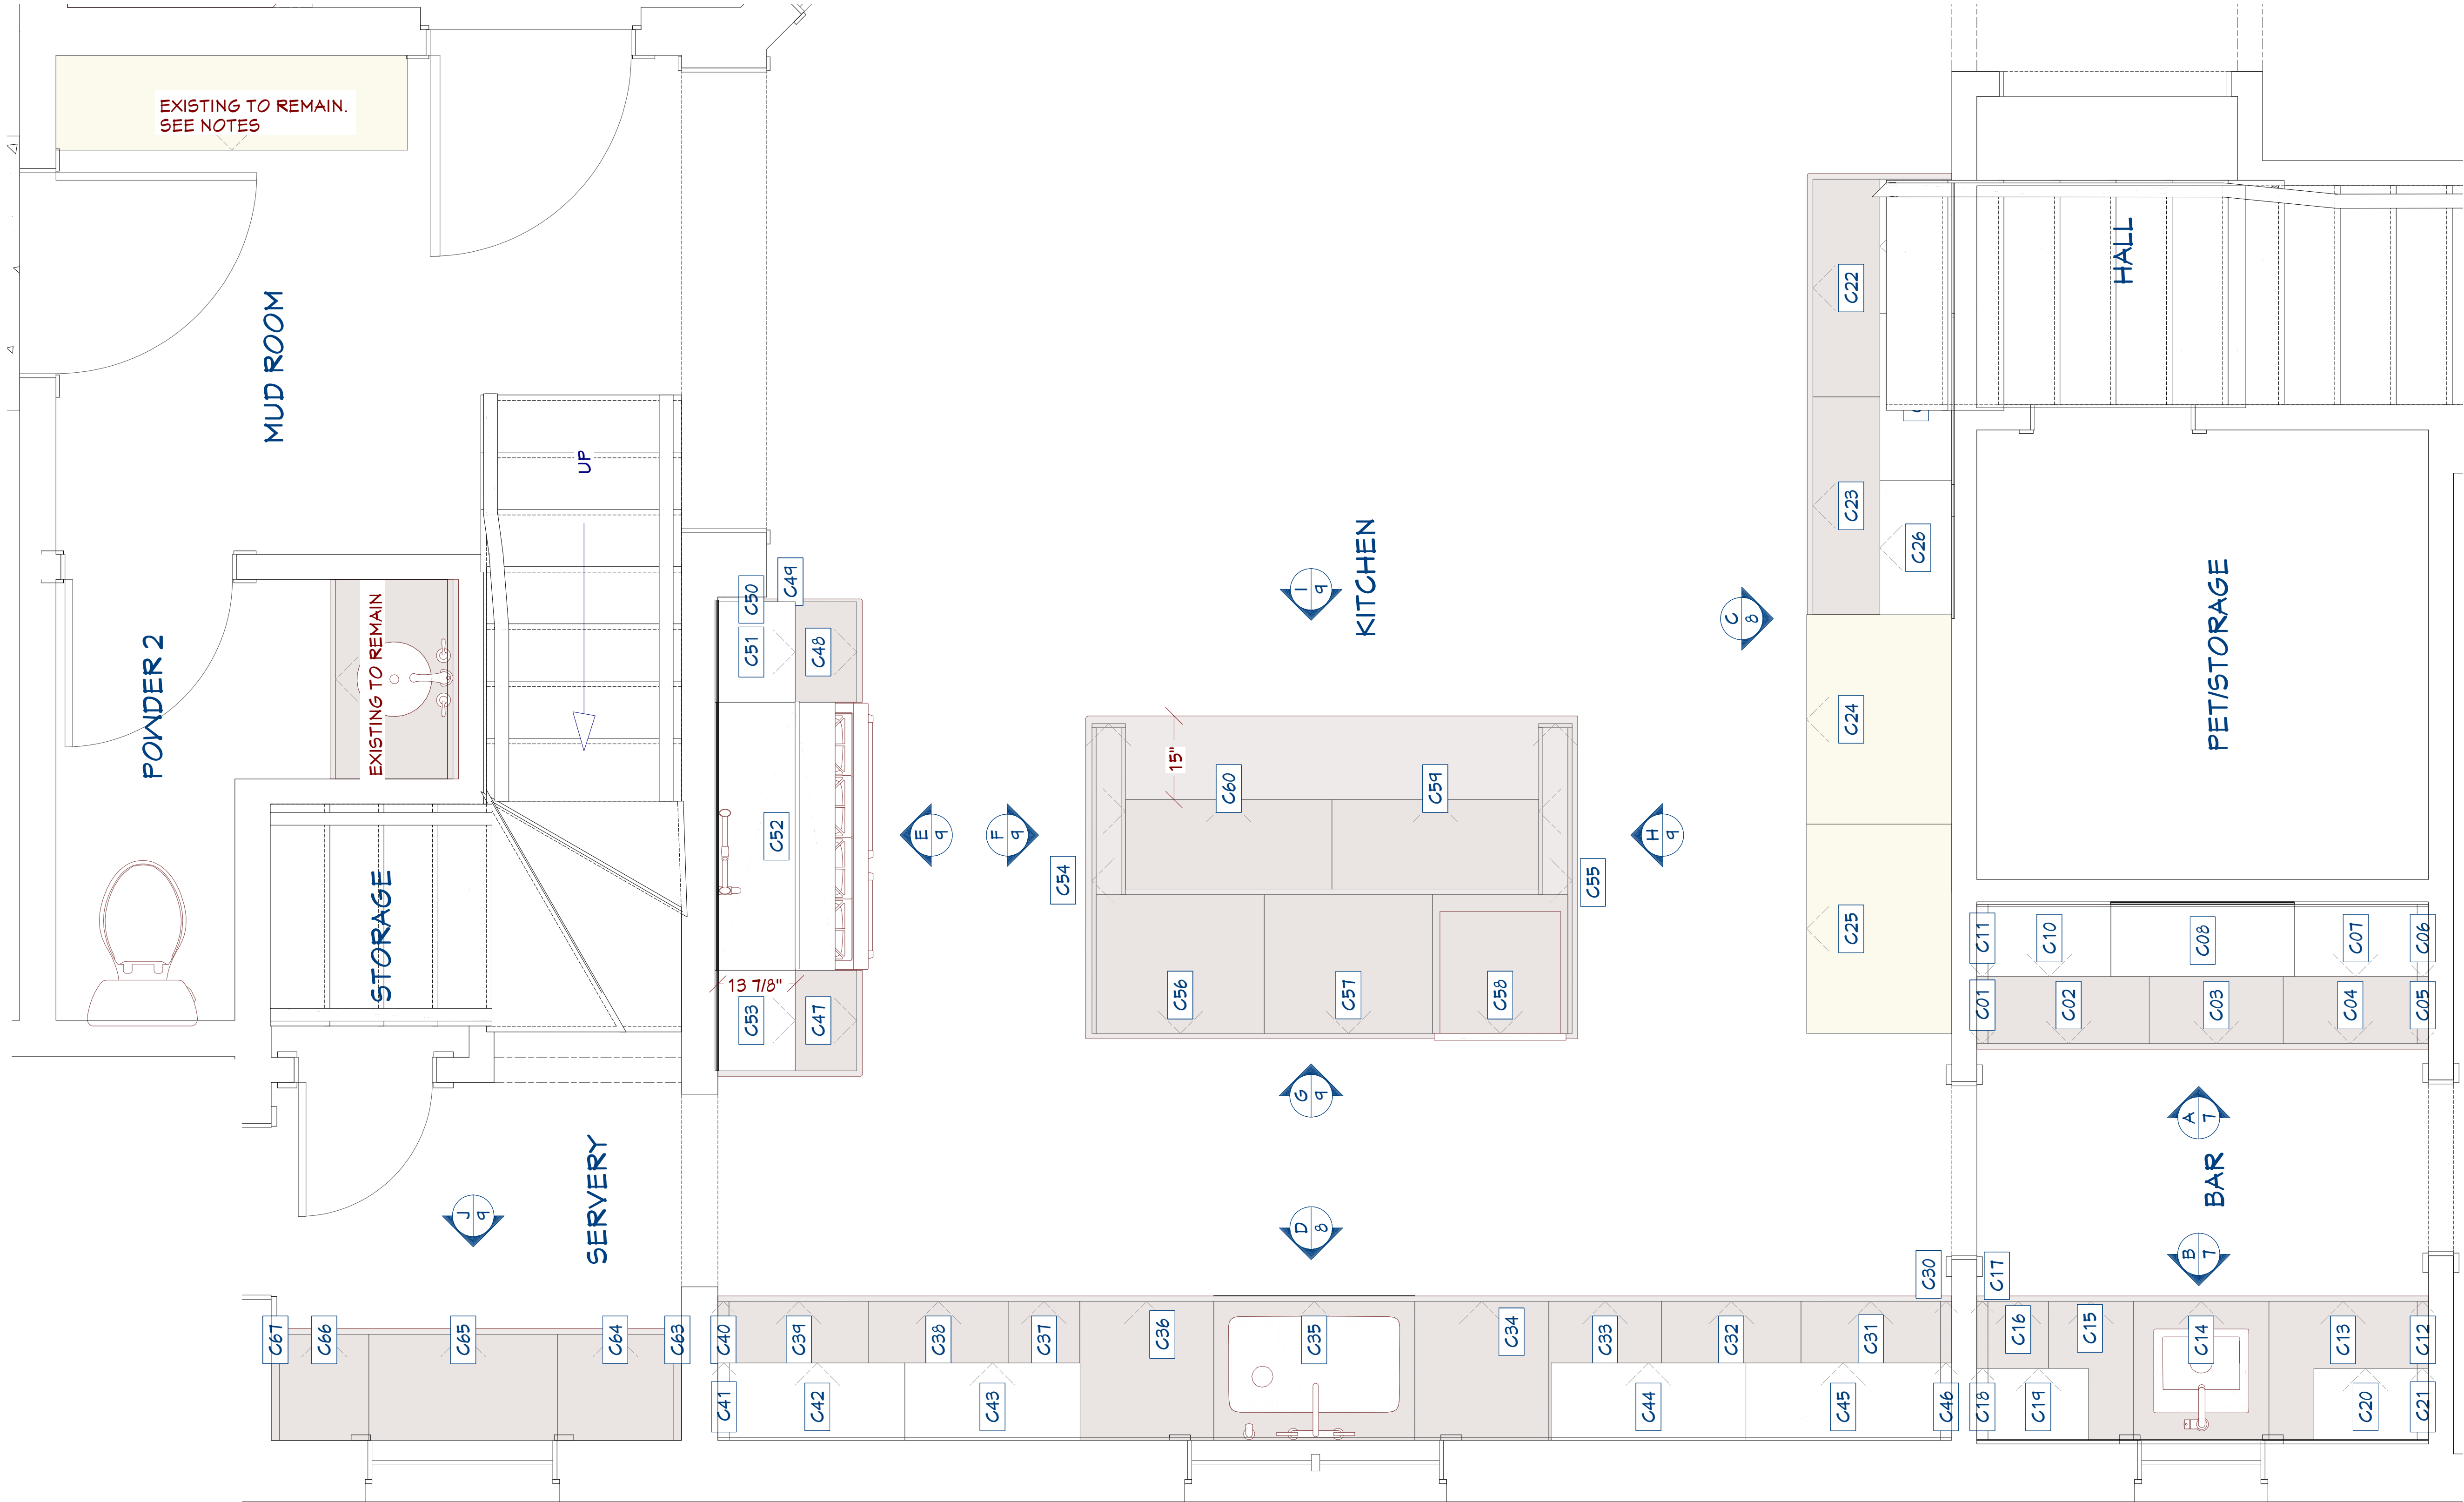

3D VIEWS ARE NOT TO SCALE AND MAY NOT REFLECT EXACTLY WHAT IS AVAILABLE FOR THE PROJECT. RENDER VIEWS ARE REPRESENTATIONS OF WHAT THE VIEW COULD LOOK LIKE, NOT WHAT IT WILL LOOK LIKE. 2D VIEWS ALWAYS SUPERCEDE 3D VIEWS

Renowned Group
4848 Lemmon Ave, suite 106,
Dallas, TX, 75219
PHONE: 972-232-7122 EMAIL: info@renowned-group.com

LICENSE NUMBER:
BU118842

REMODEL PLANS FOR:
Plassick Morton
3504 Villanova St
Dallas, TX, 75225


PAGE TITLE:
Kitchen, Bar, Scullery

DRAWN BY:
MB


DATE:
5/7/25

SCALE:
3/4" = 1'0"

SHEET #:
6

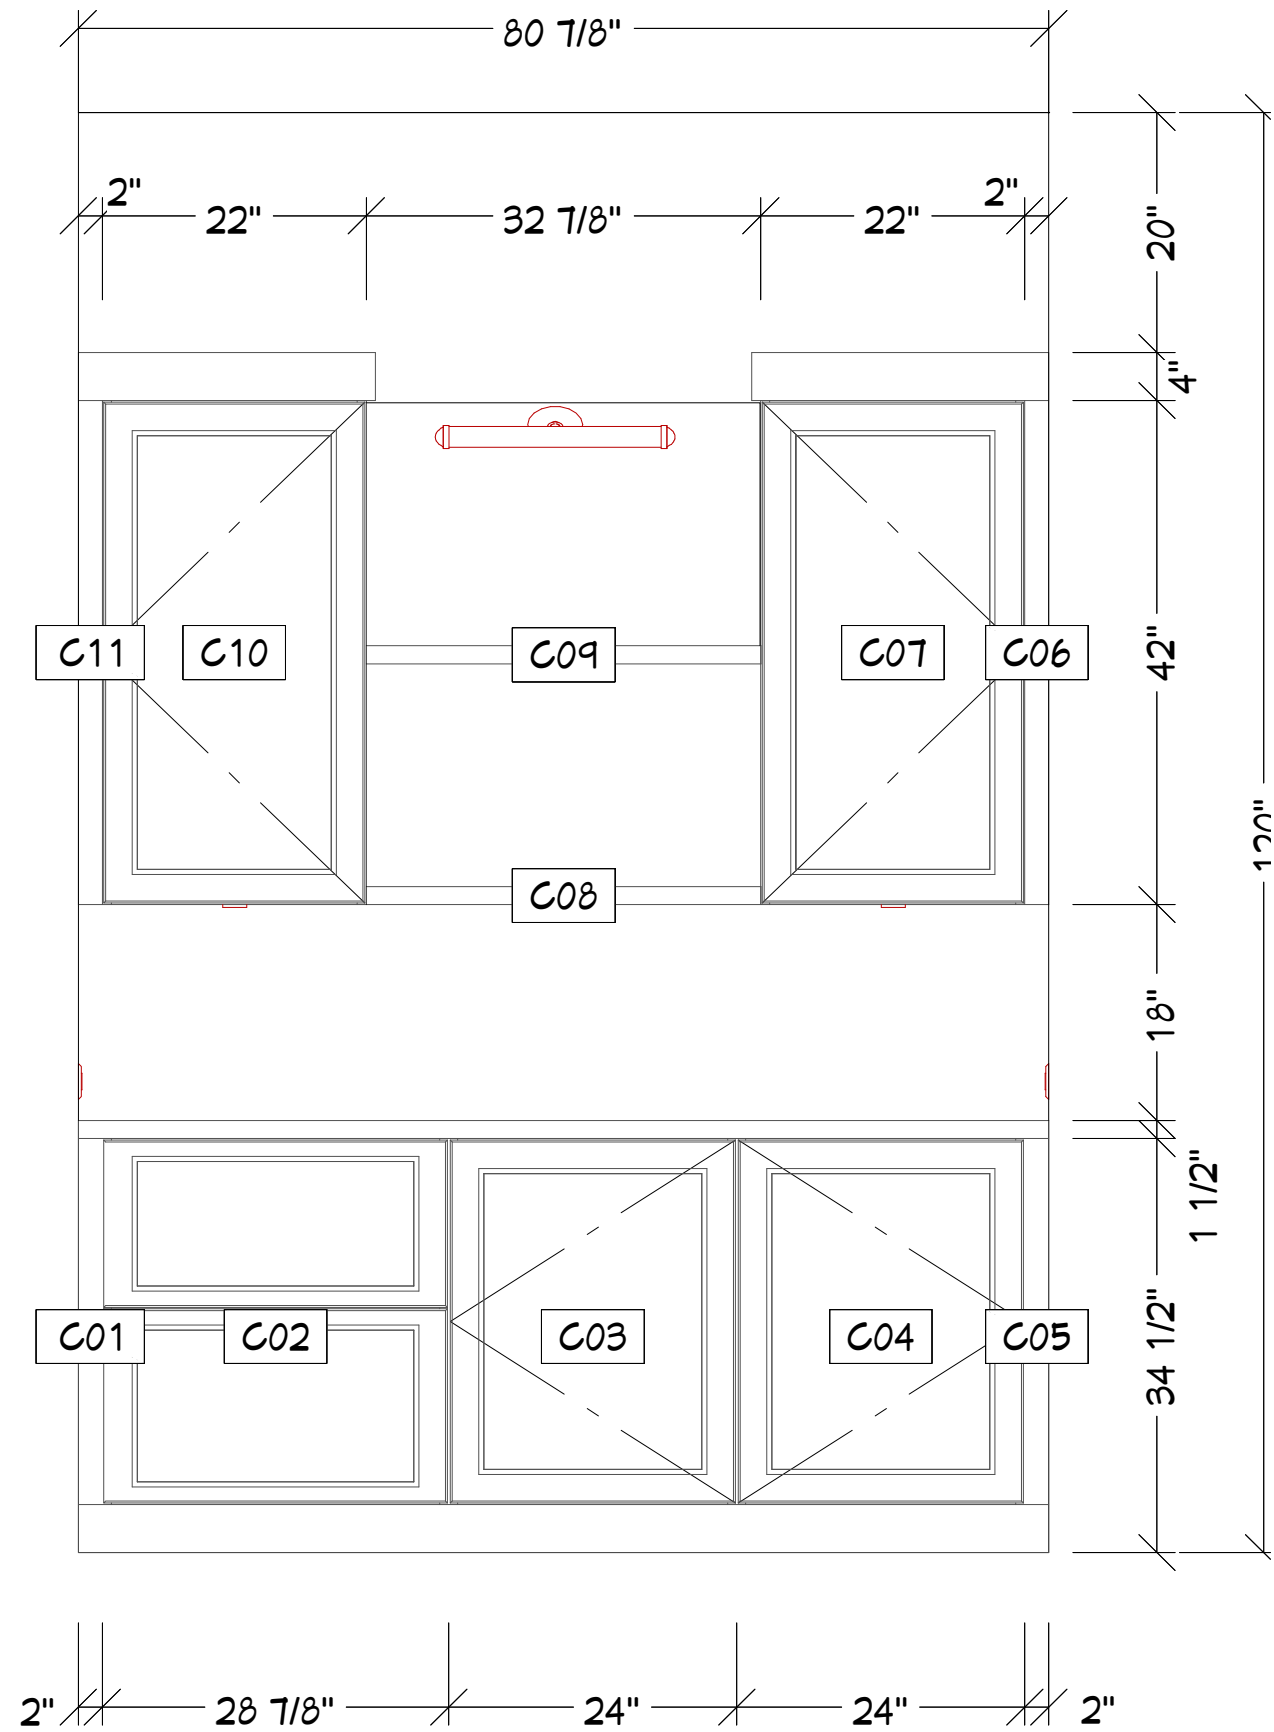

A
7 Bar- Wine/Bev Fridge Side
3/4 in = 1 ft

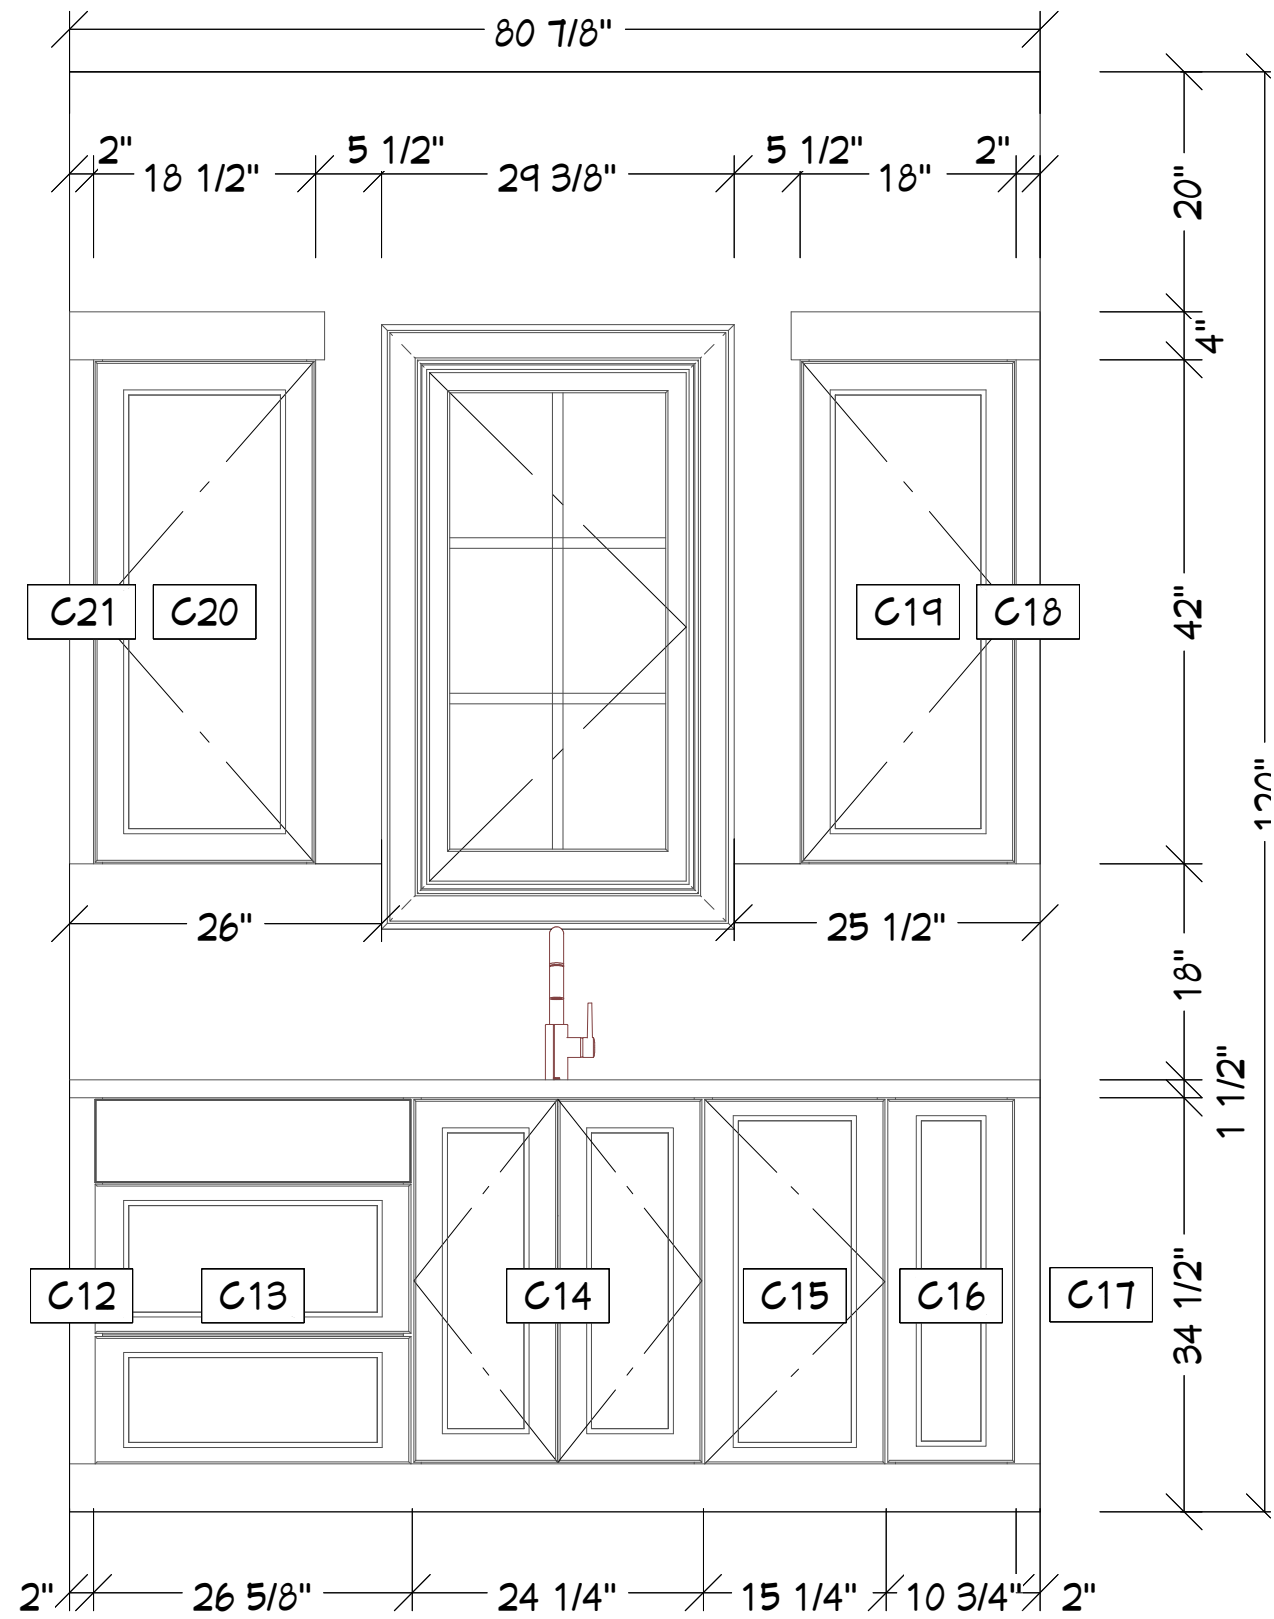

B
7 Bar Window Side
3/4 in = 1 ft

3D VIEWS ARE NOT TO SCALE AND MAY NOT REFLECT EXACTLY WHAT IS AVAILABLE FOR THE PROJECT. RENDER VIEWS ARE REPRESENTATIONS OF WHAT THE VIEW COULD LOOK LIKE, NOT WHAT IT WILL LOOK LIKE. 2D VIEWS ALWAYS SUPERCEDE 3D VIEWS

Renowned Group
4848 Lemmon Ave, suite 106,
Dallas, TX, 75219
PHONE: 972-232-7122 EMAIL: info@renowned-group.com

LICENSE NUMBER:
BU118842

REMODEL PLANS FOR:
Plassick Morton
3504 Villanova St
Dallas, TX, 75225

PAGE TITLE:
Bar Elevations

DRAWN BY:
MB

DATE:
5/7/25

SCALE:
3/4"=1'0"

SHEET #:
7

3D VIEWS ARE NOT TO SCALE AND MAY NOT REFLECT EXACTLY WHAT IS AVAILABLE FOR THE PROJECT. RENDER VIEWS ARE REPRESENTATIONS OF WHAT THE VIEW COULD LOOK LIKE, NOT WHAT IT WILL LOOK LIKE. 2D VIEWS ALWAYS SUPERCEDE 3D VIEWS

Renowned Group
4848 Lemmon Ave, suite 106,
Dallas, TX, 75219
PHONE: 972-252-7122 EMAIL: info@renowned-group.com

LICENSE NUMBER:

BU118842

REMODEL PLANS FOR:

Plassick Morton
3504 Villanova St
Dallas, TX, 75225

PAGE TITLE:

Kitchen Elevations

DRAWN BY:

MB

DATE:


5/7/25

SCALE:


3/4" = 1'0"

SHEET #:


8

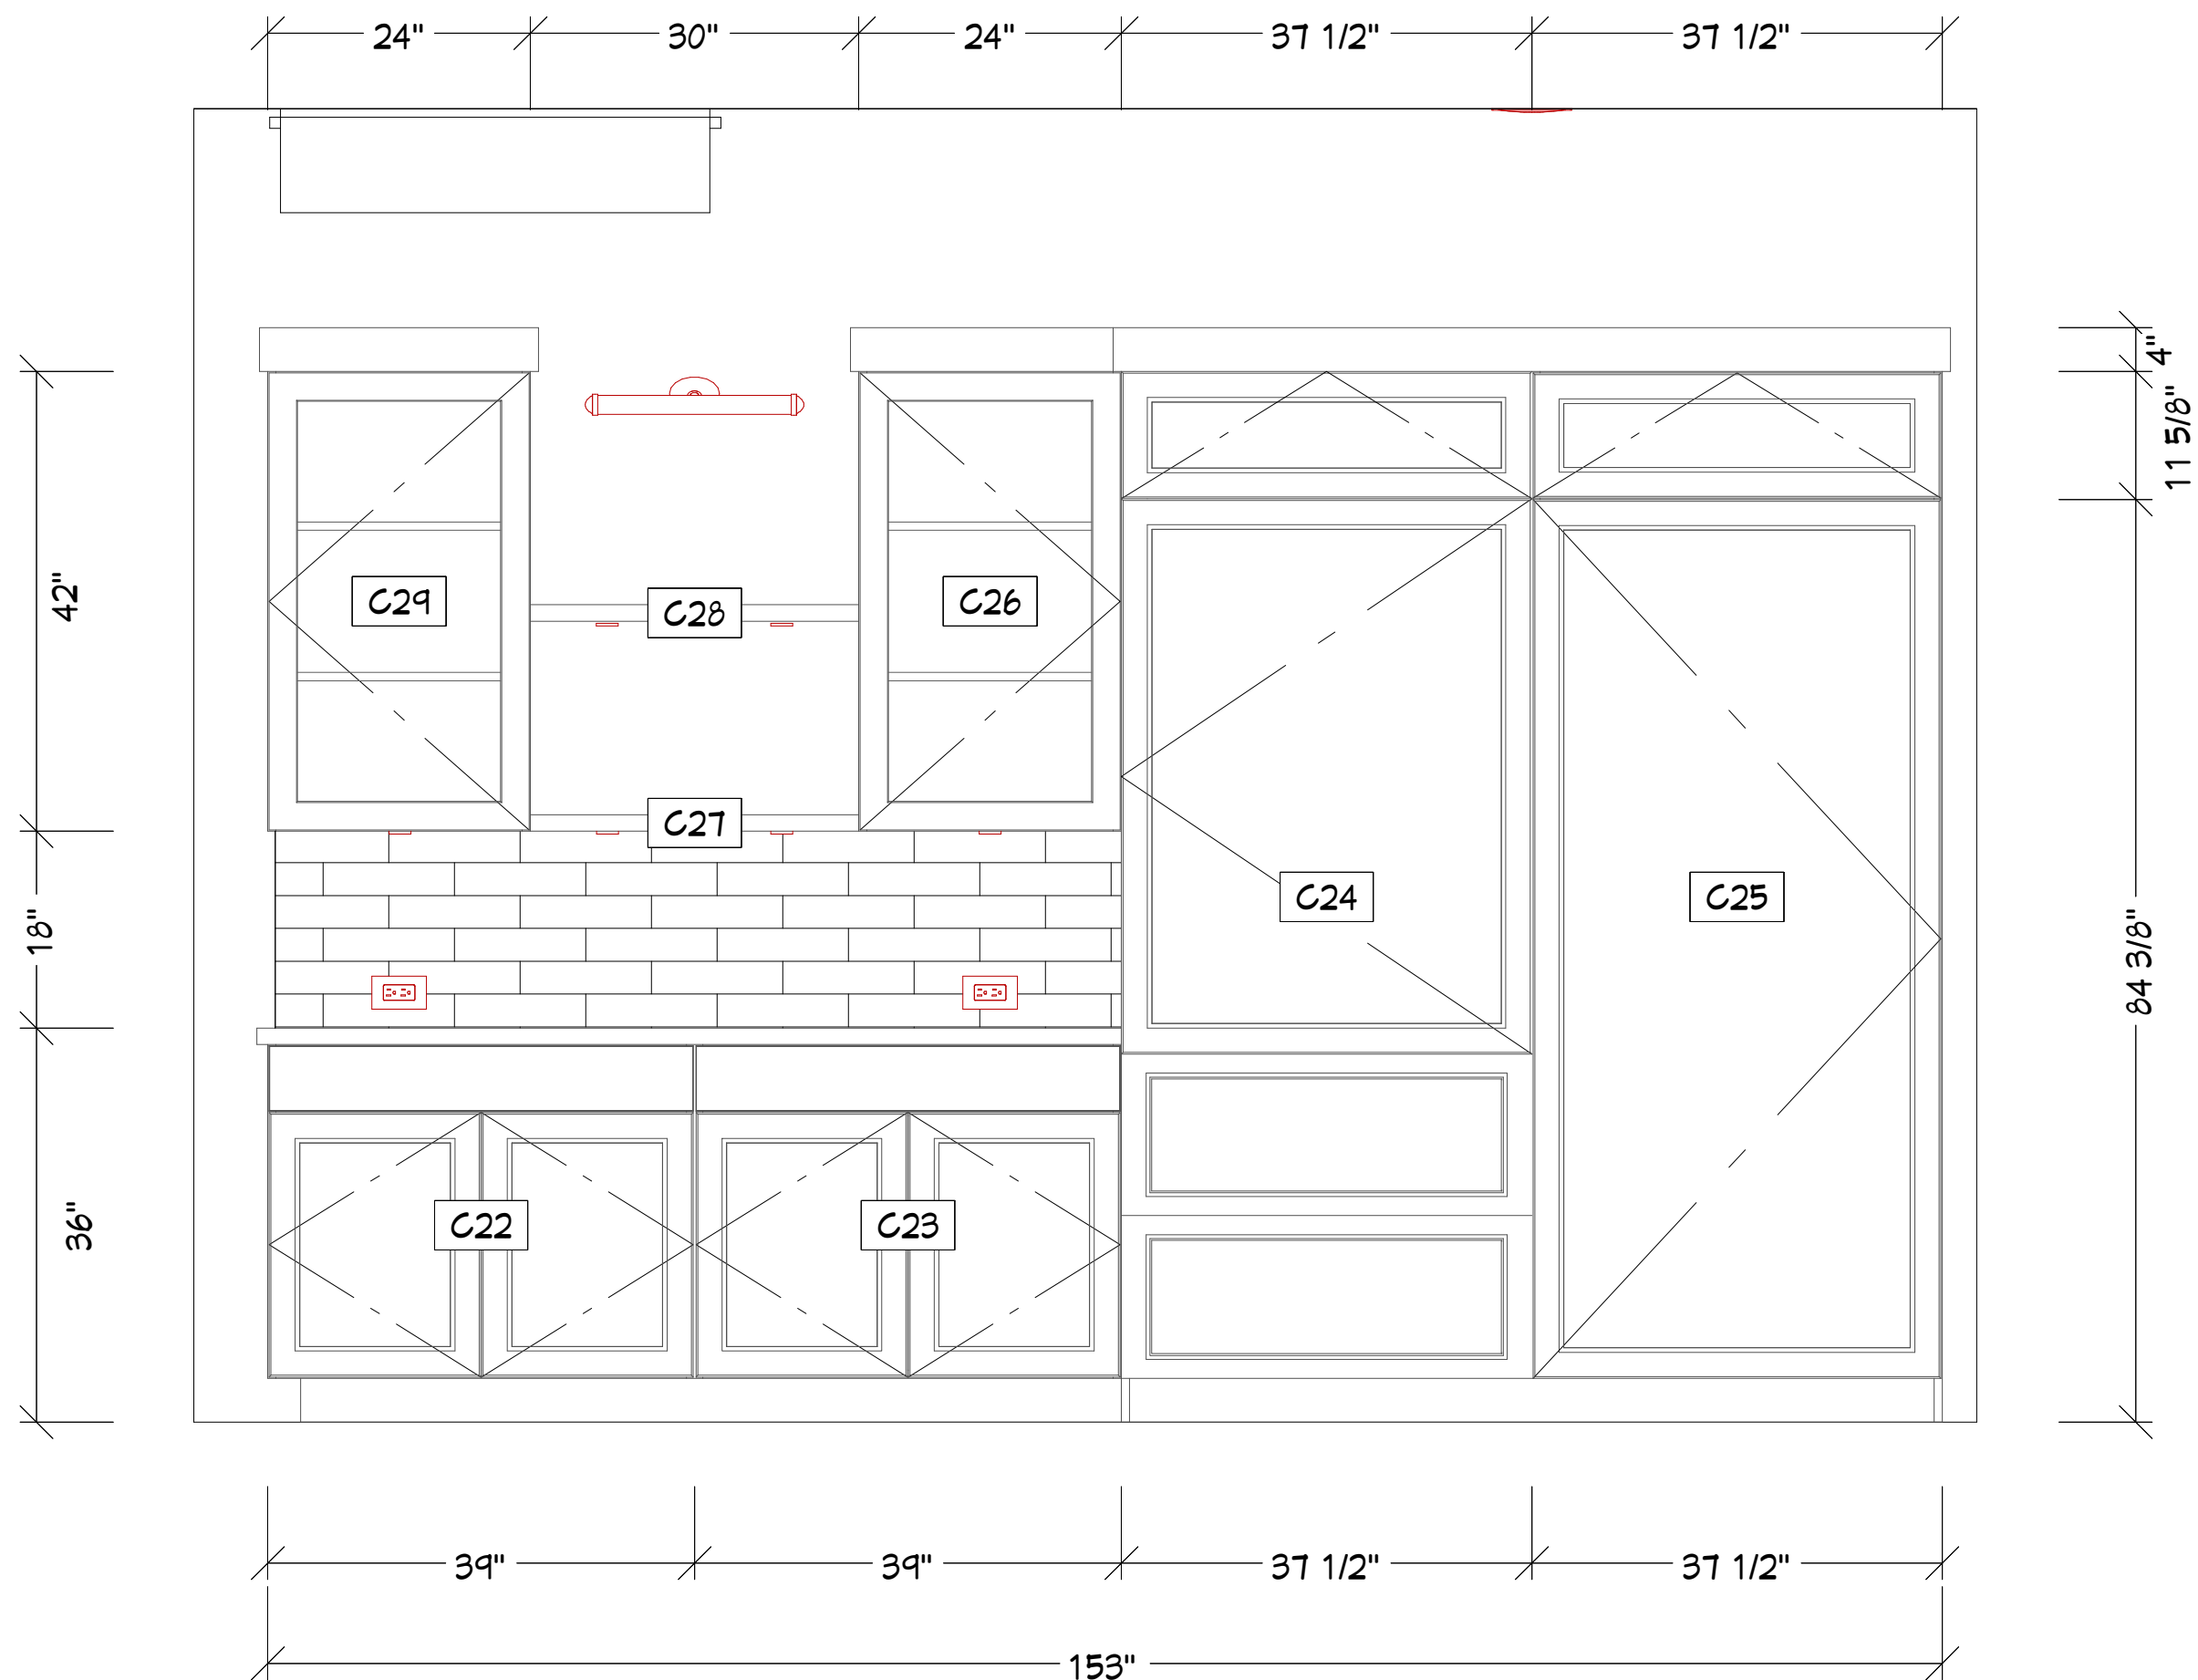


C
8 Refrigerator Wall Side
3/4 in = 1 ft

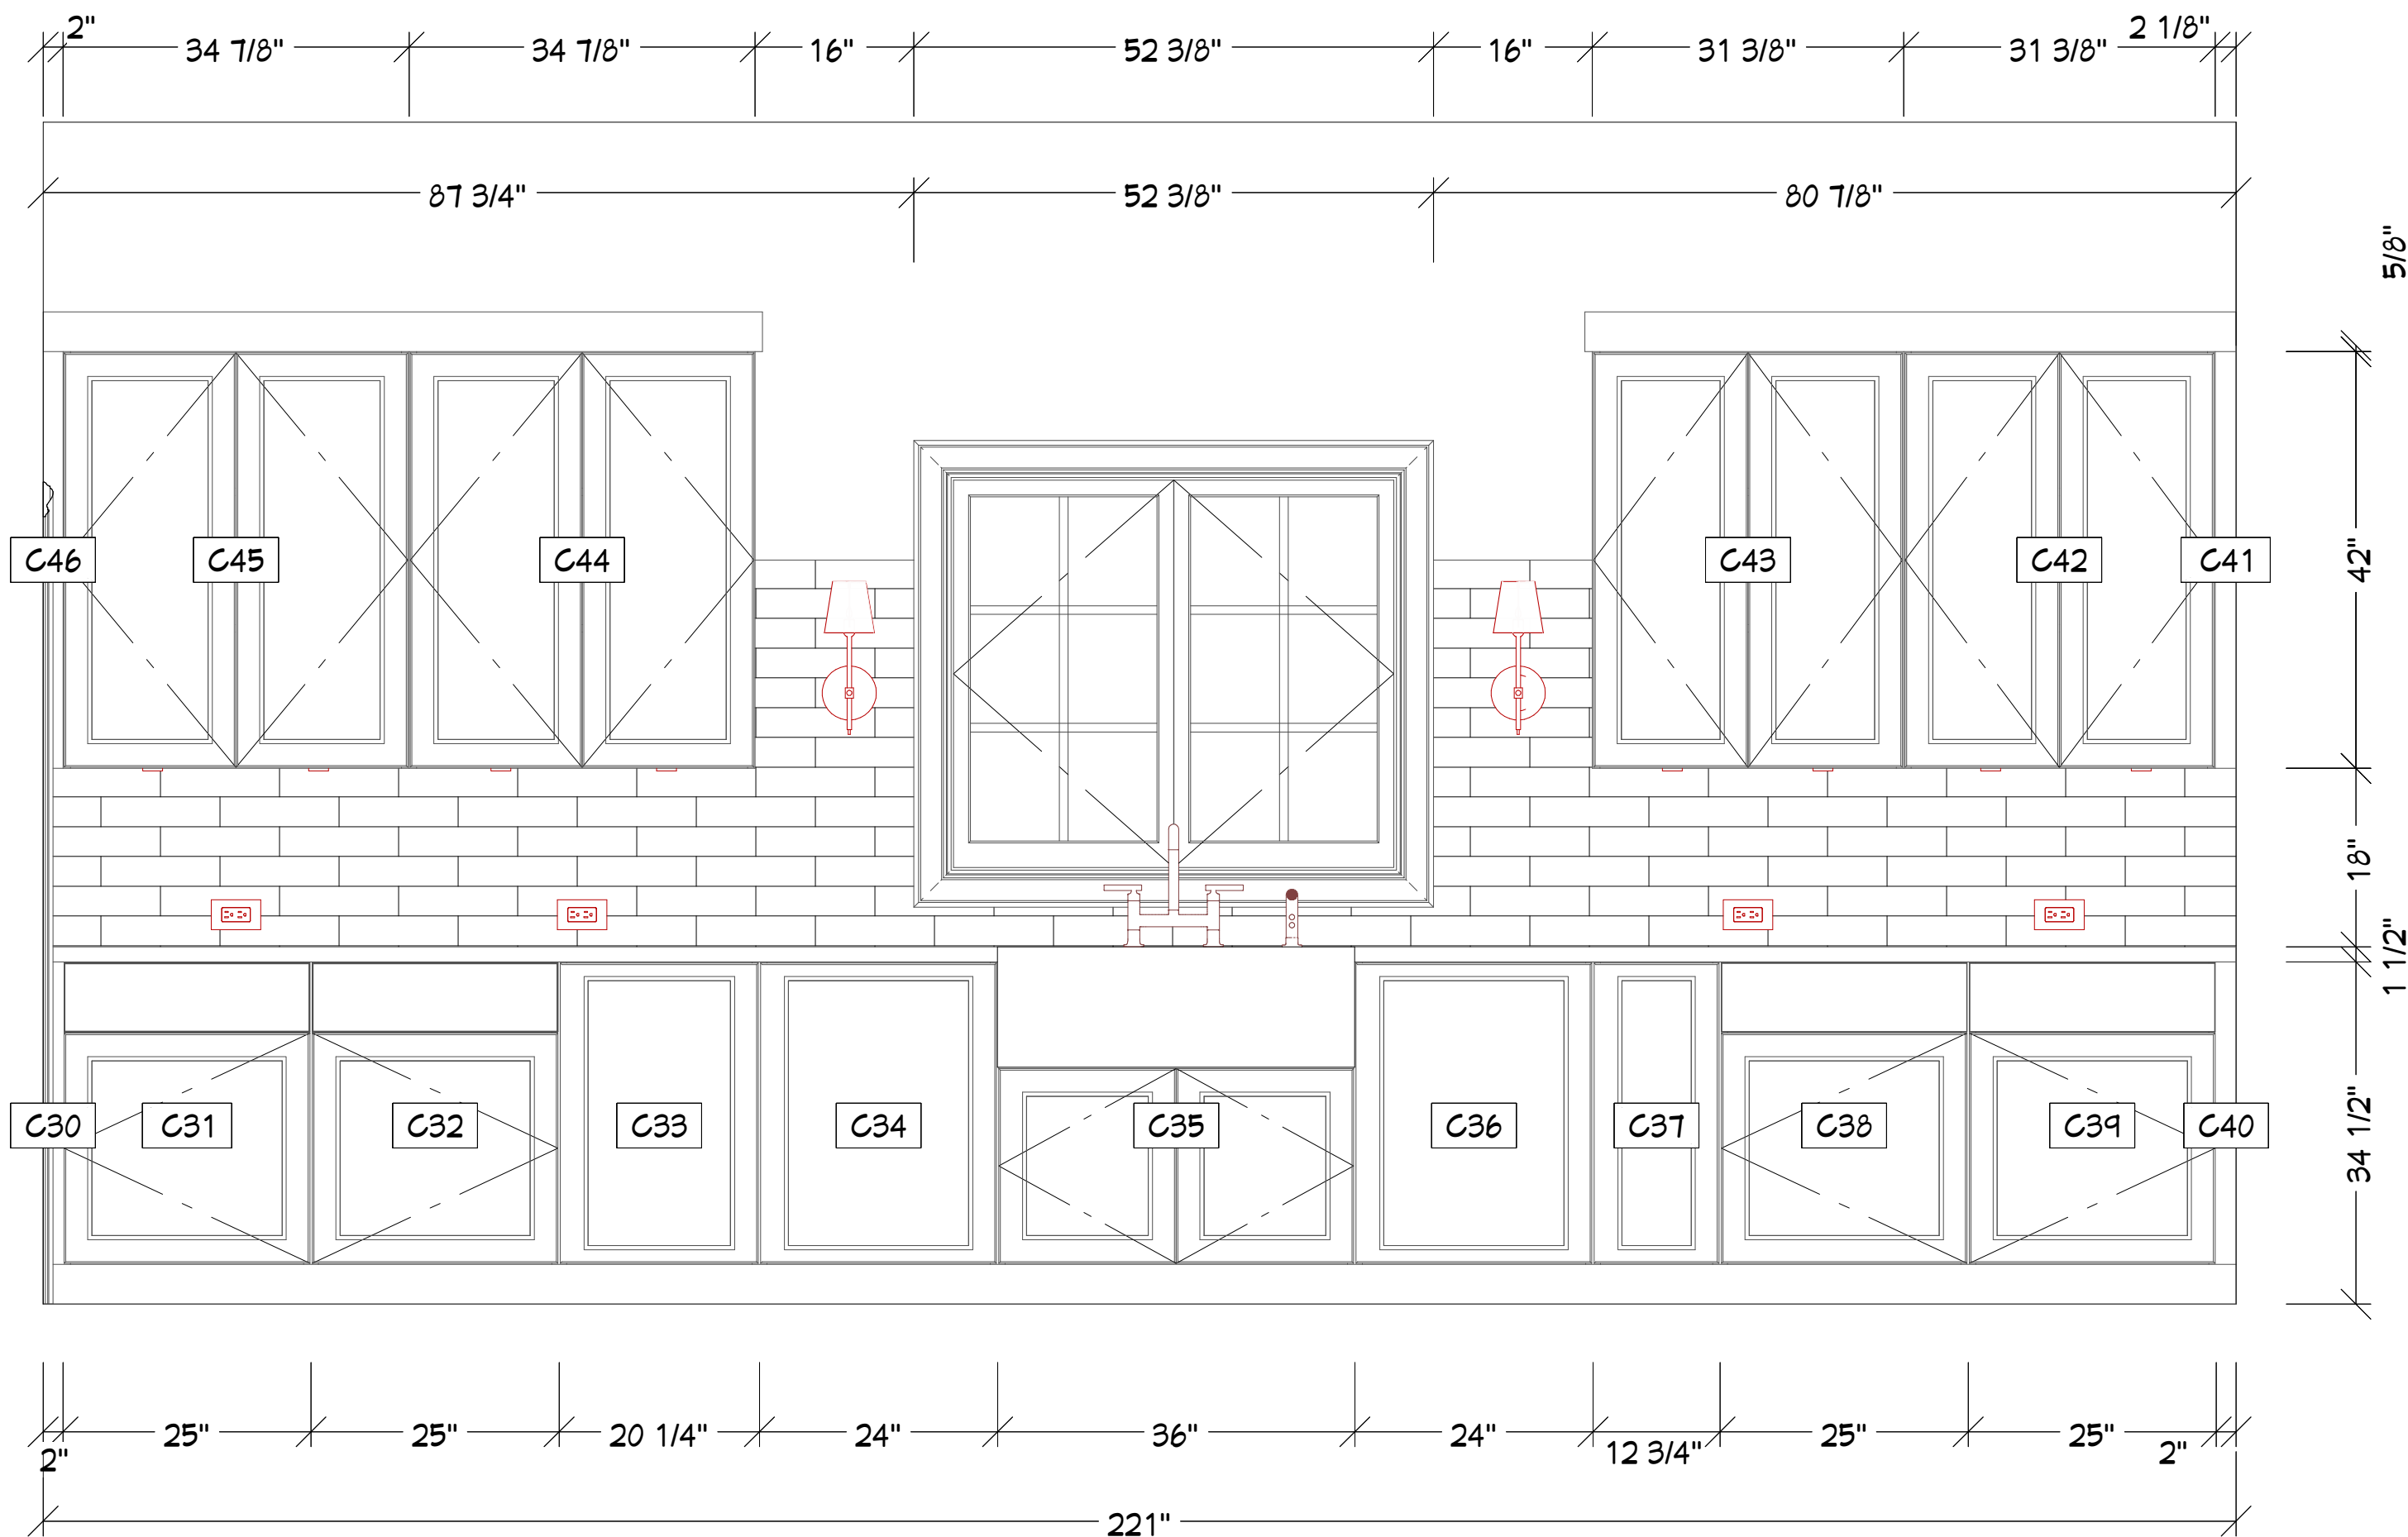


D
8 Kitchen Sink Wall
3/4 in = 1 ft

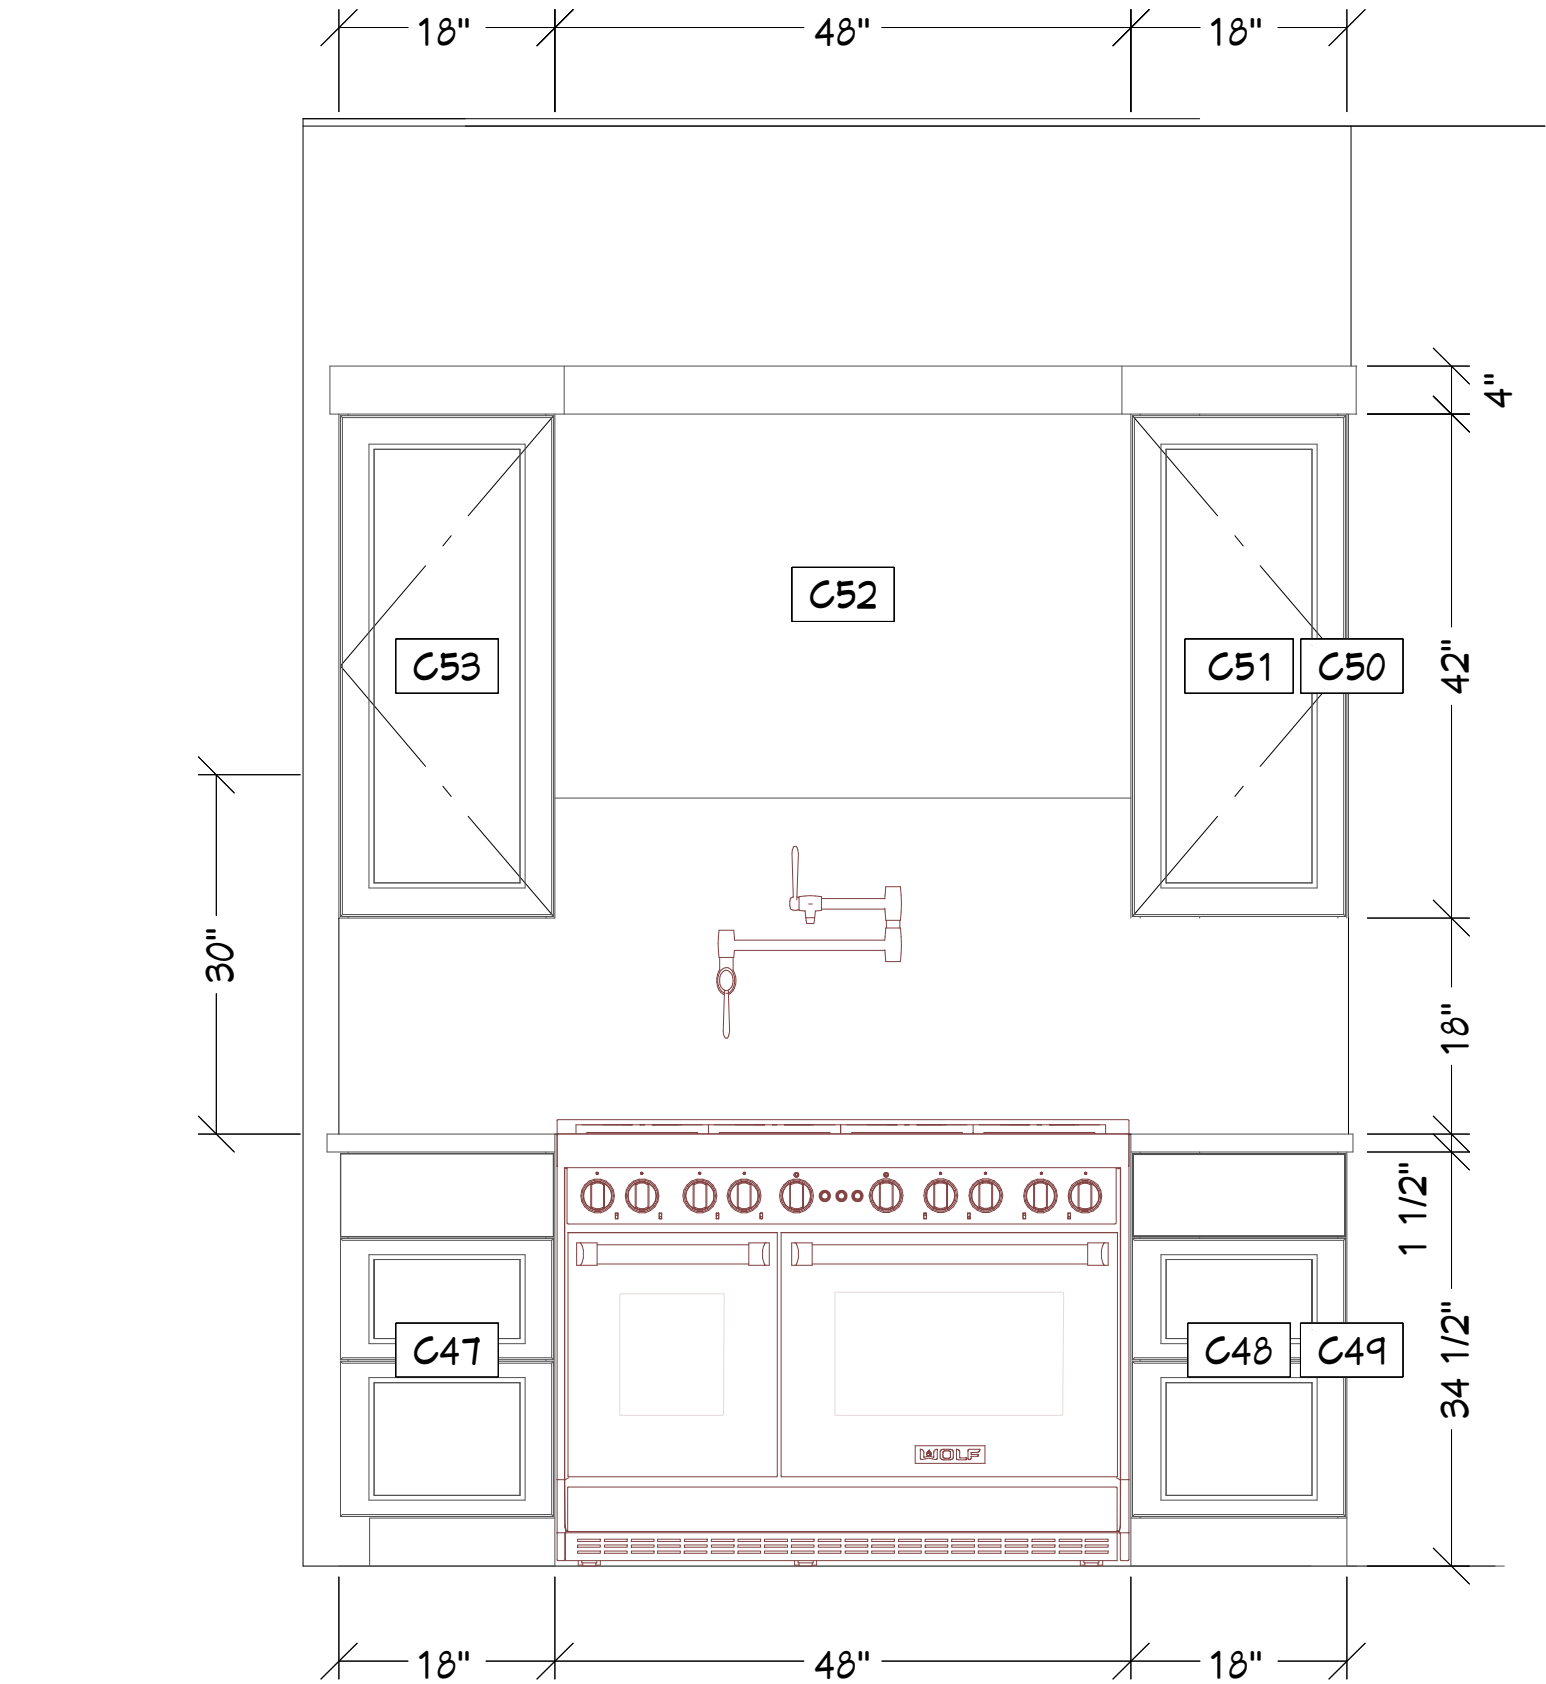


E
9 Range Wall
3/4 in = 1 ft

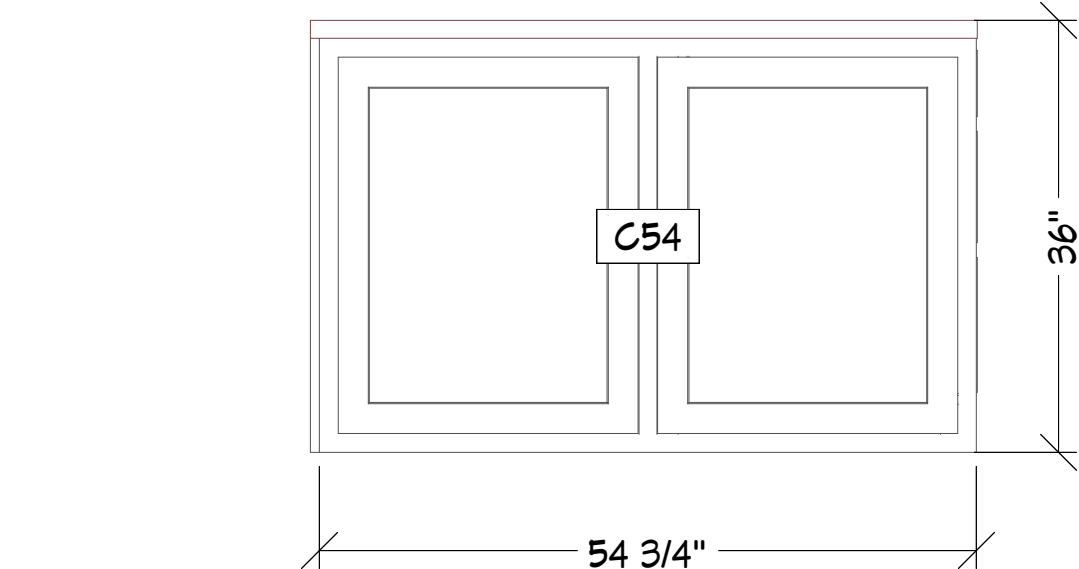


F
9 Side of Island R
3/4 in = 1 ft

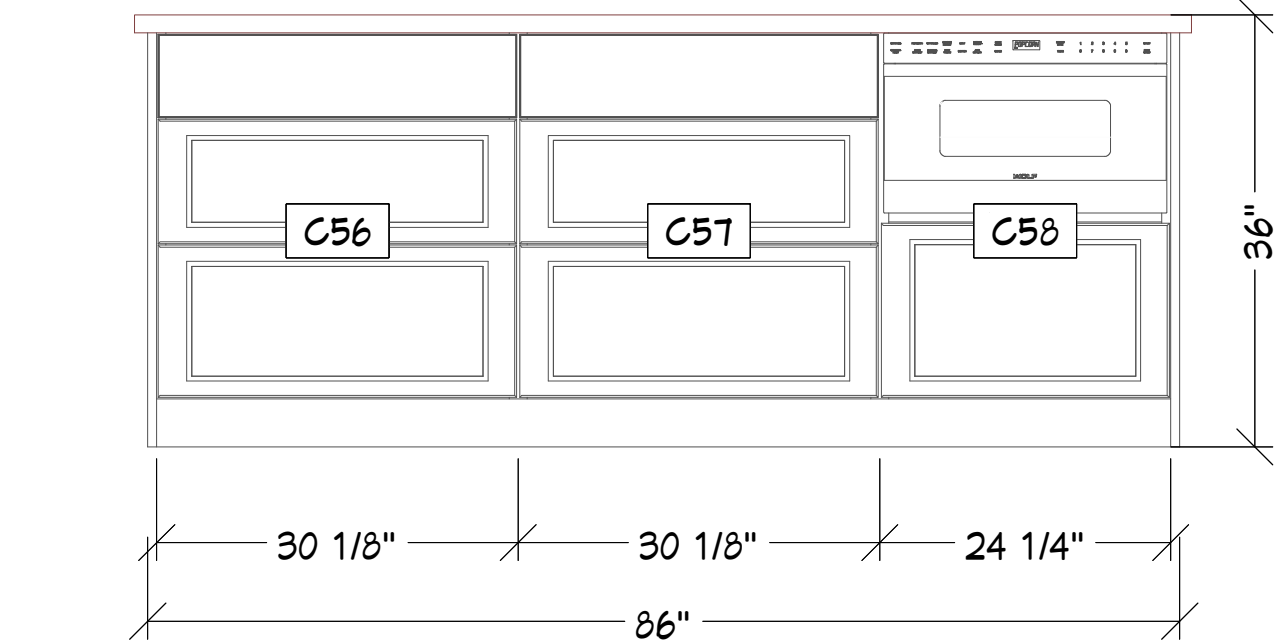


G
9 Sink Side of Island
3/4 in = 1 ft

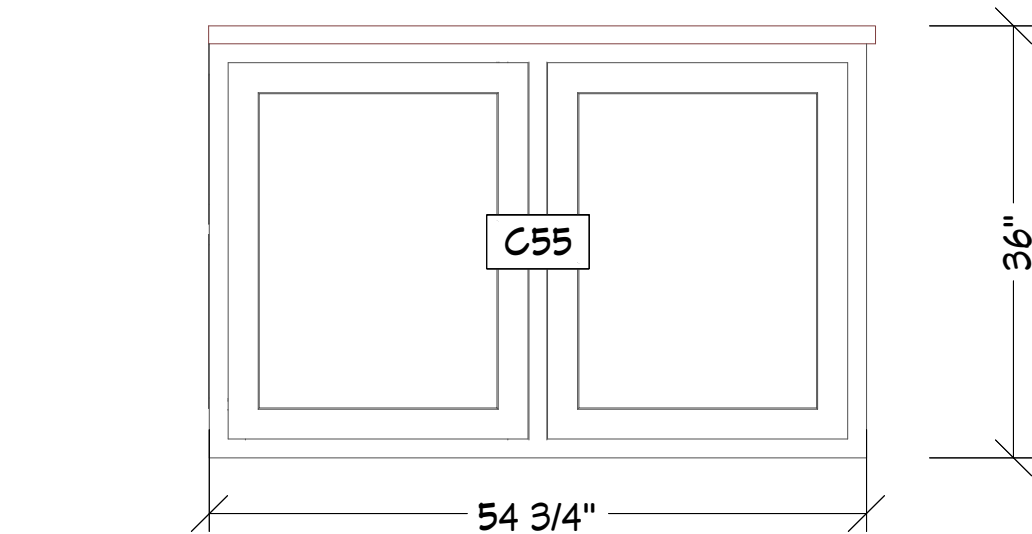

H
9 Side of Island L
3/4 in = 1 ft

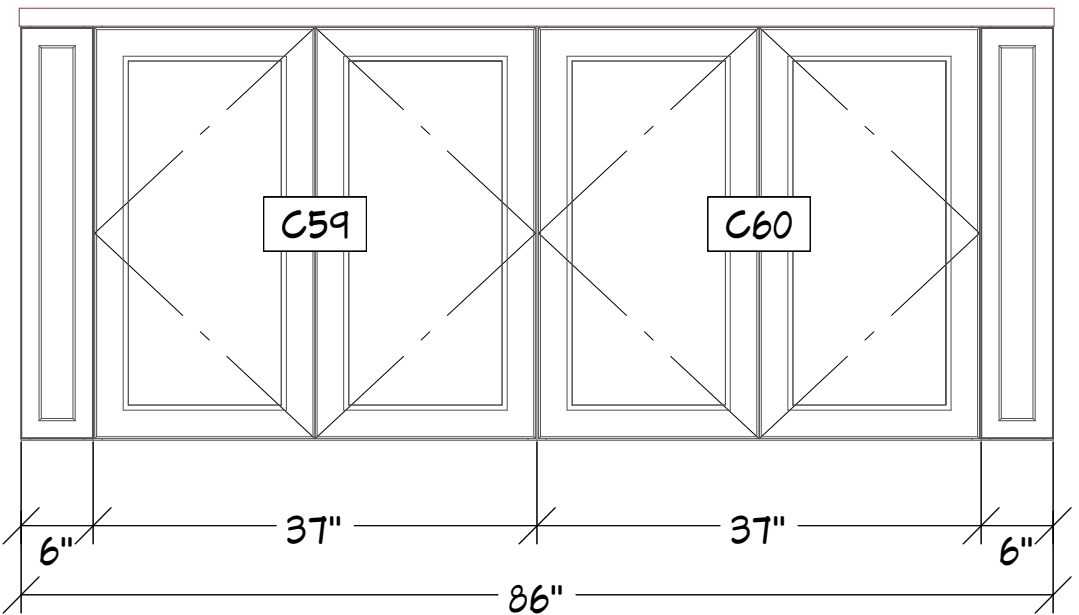

I
9 Back of Island
3/4 in = 1 ft

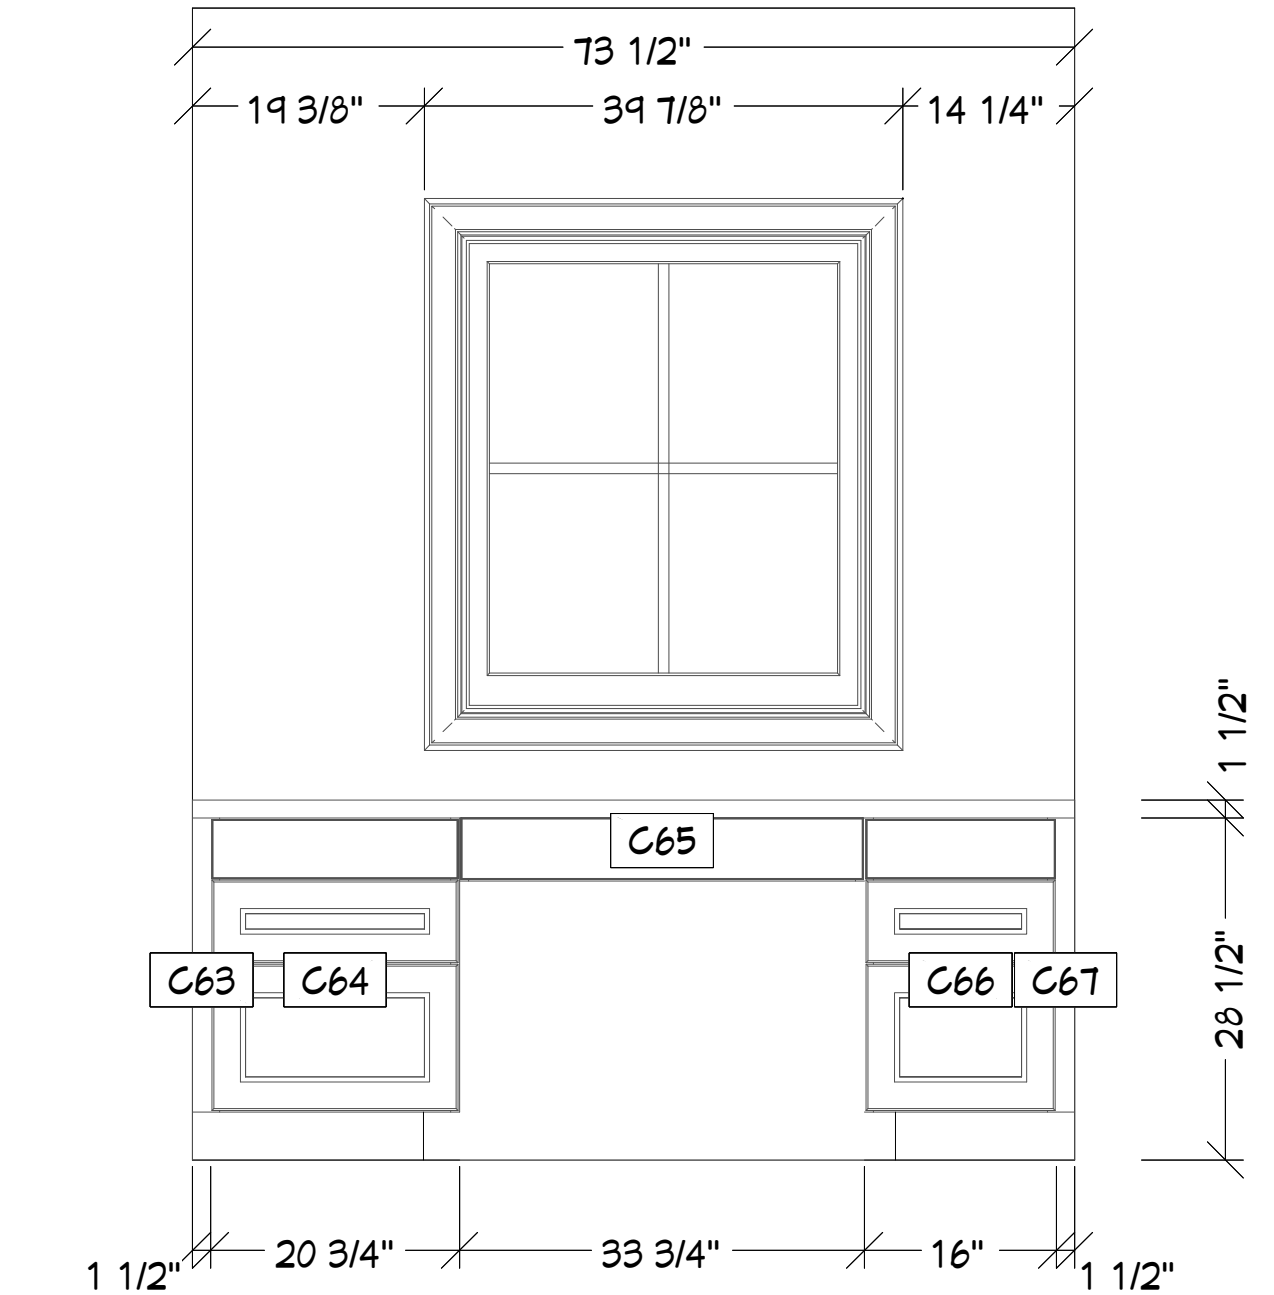

J
9 Servery Window Side
3/4 in = 1 ft

3D VIEWS ARE NOT TO SCALE AND MAY NOT REFLECT EXACTLY WHAT IS AVAILABLE FOR THE PROJECT. RENDER VIEWS ARE REPRESENTATIONS OF WHAT THE VIEW COULD LOOK LIKE, NOT WHAT IT WILL LOOK LIKE. 2D VIEWS ALWAYS SUPERCEDE 3D VIEWS

Renowned Group
4848 Lemmon Ave, suite 106,
Dallas, TX, 75219
PHONE: 972-232-7122 EMAIL: info@renowned-group.com

LICENSE NUMBER:
BU118842

REMODEL PLANS FOR:
Plassick Morton
3504 Villanova St
Dallas, TX, 75225

PAGE TITLE:
Kitchen Elevations

DRAWN BY:
MB

DATE:
5/7/25

SCALE:
3/4" = 1'0"

SHEET #:
9



3D VIEWS ARE NOT TO
SCALE AND MAY NOT
REFLECT EXACTLY WHAT
IS AVAILABLE FOR THE
PROJECT. RENDER VIEWS
ARE REPRESENTATIONS
OF WHAT THE VIEW
COULD LOOK LIKE, NOT
WHAT IT WILL LOOK LIKE.
2D VIEWS ALWAYS
SUPERCEDE 3D VIEWS

Renowned Group
4848 Lemmon Ave, suite 106,
Dallas, TX, 75219
PHONE: 972-232-7122 EMAIL: info@renowned-group.com

LICENSE NUMBER:
BU118842

REMODEL PLANS FOR:
Plassick Morton
3504 Villanova St
Dallas, TX, 75225


PAGE TITLE:
**3D Views Kitchen, Bar &
Servery**

DRAWN BY:
MB


DATE:
5/7/25

SCALE:
NA


SHEET #:
10

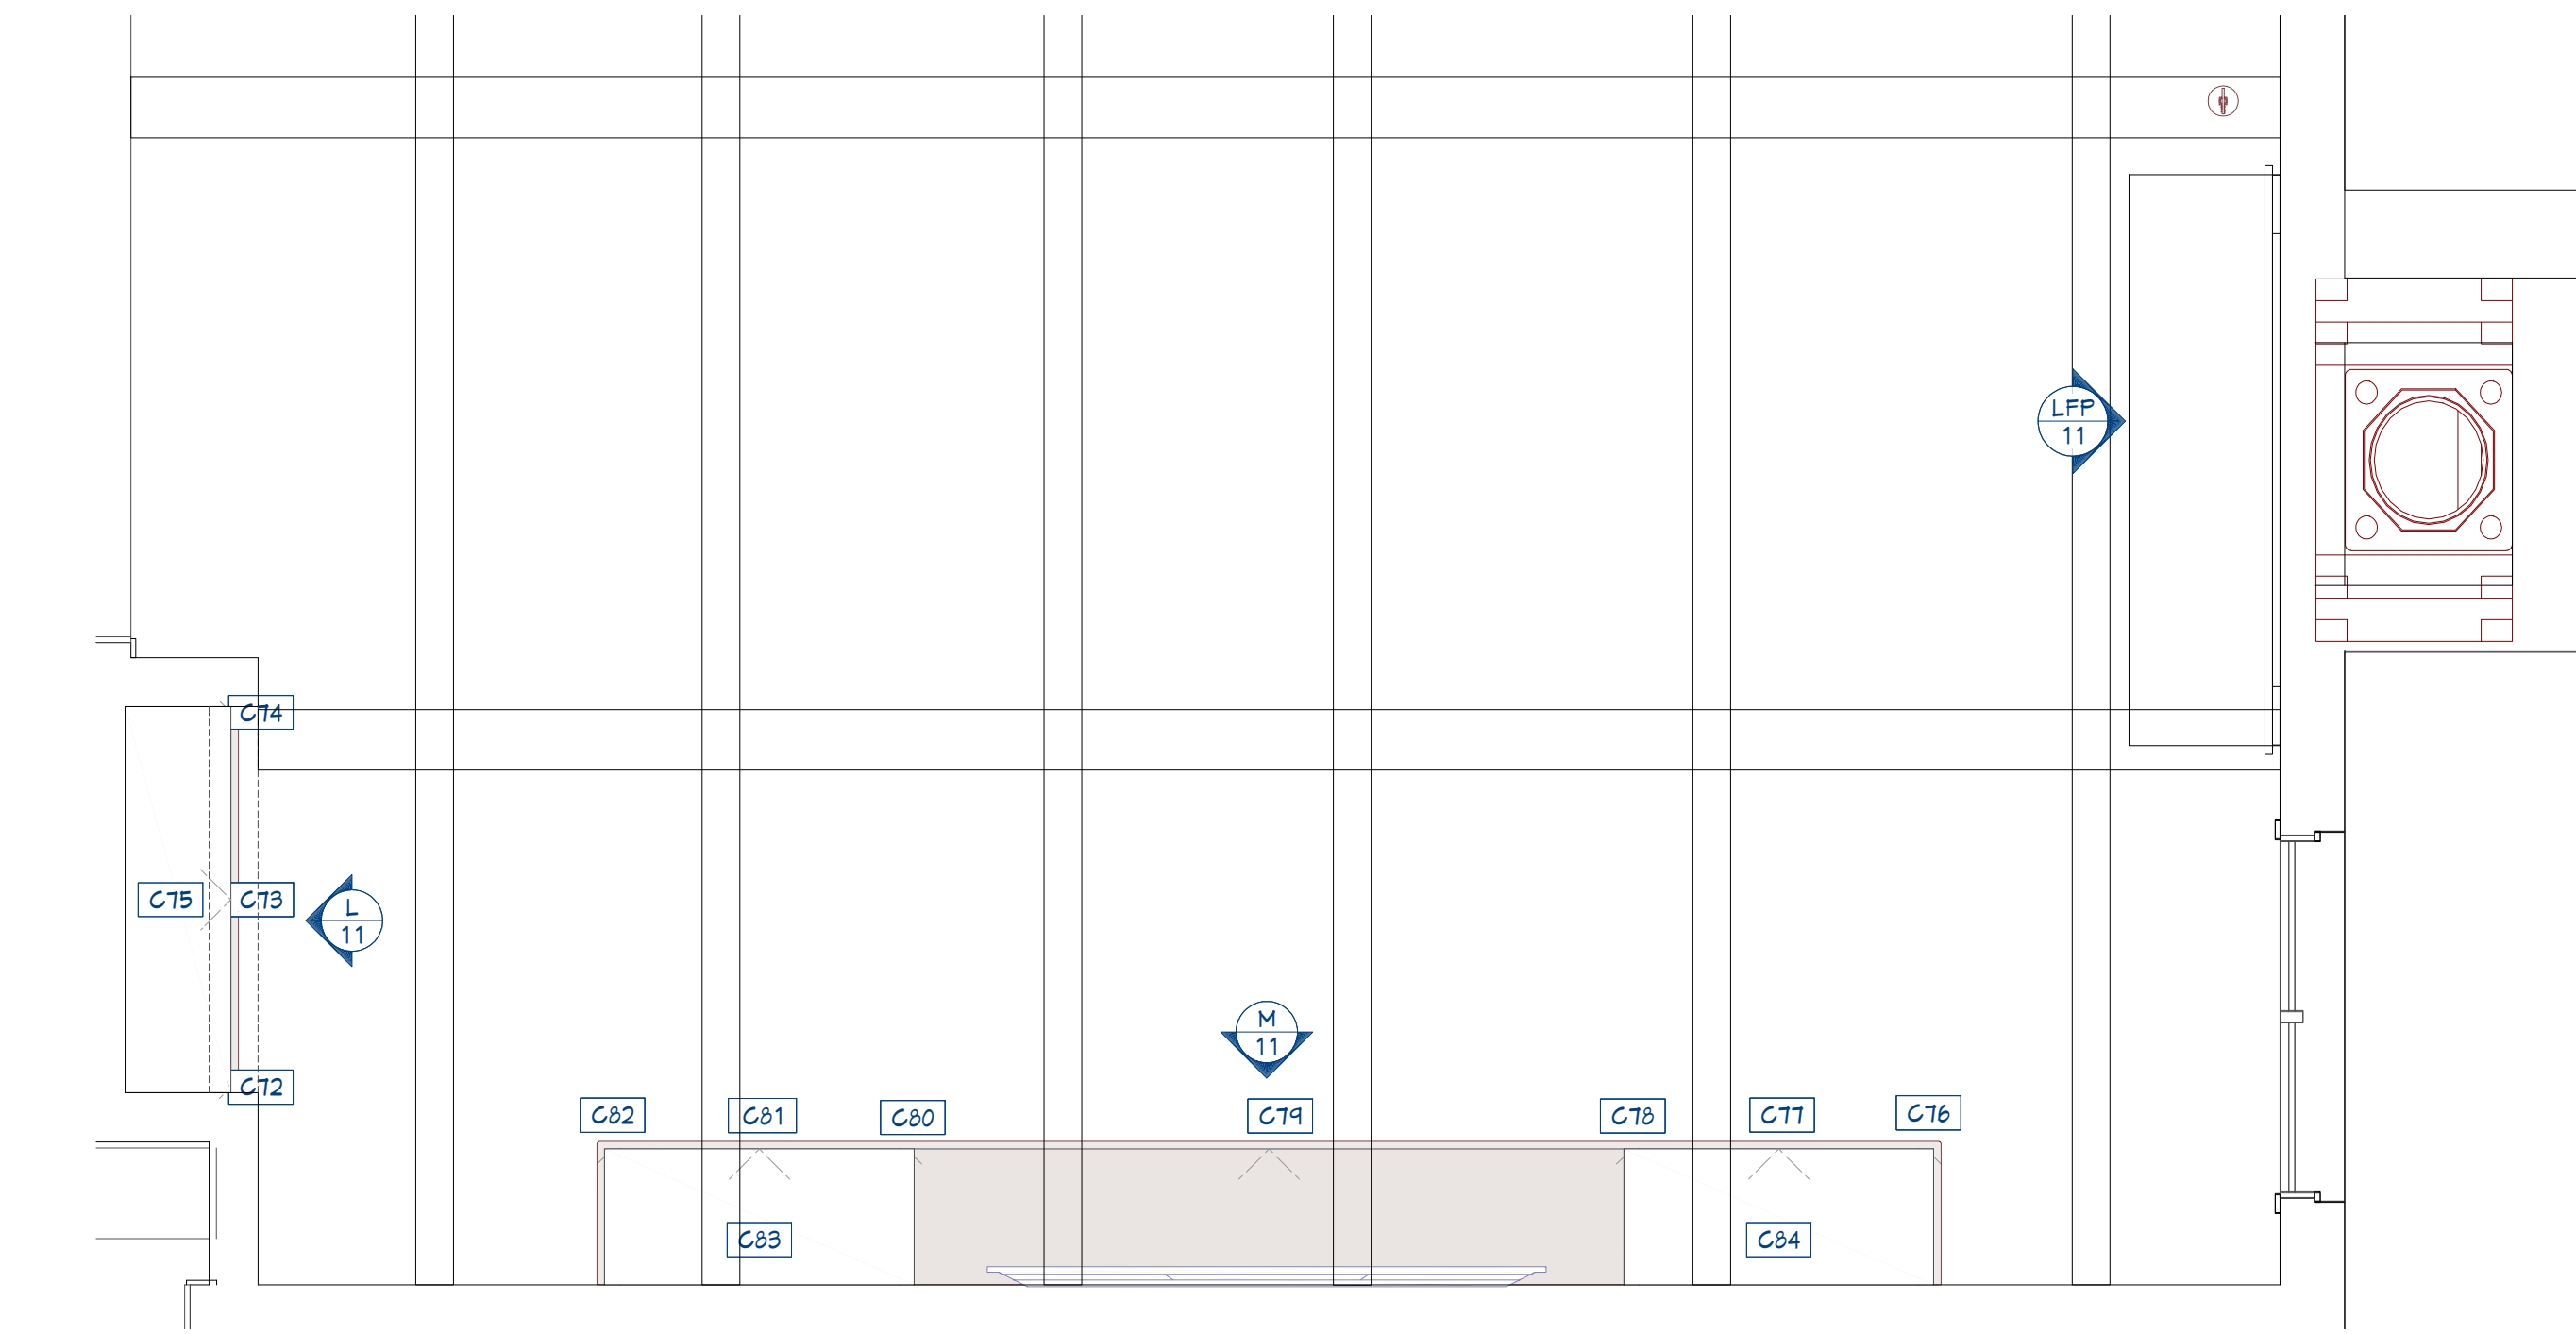


11 NKBA - Kitchen & Bath Plan 1/2"
1/2 in = 1 ft

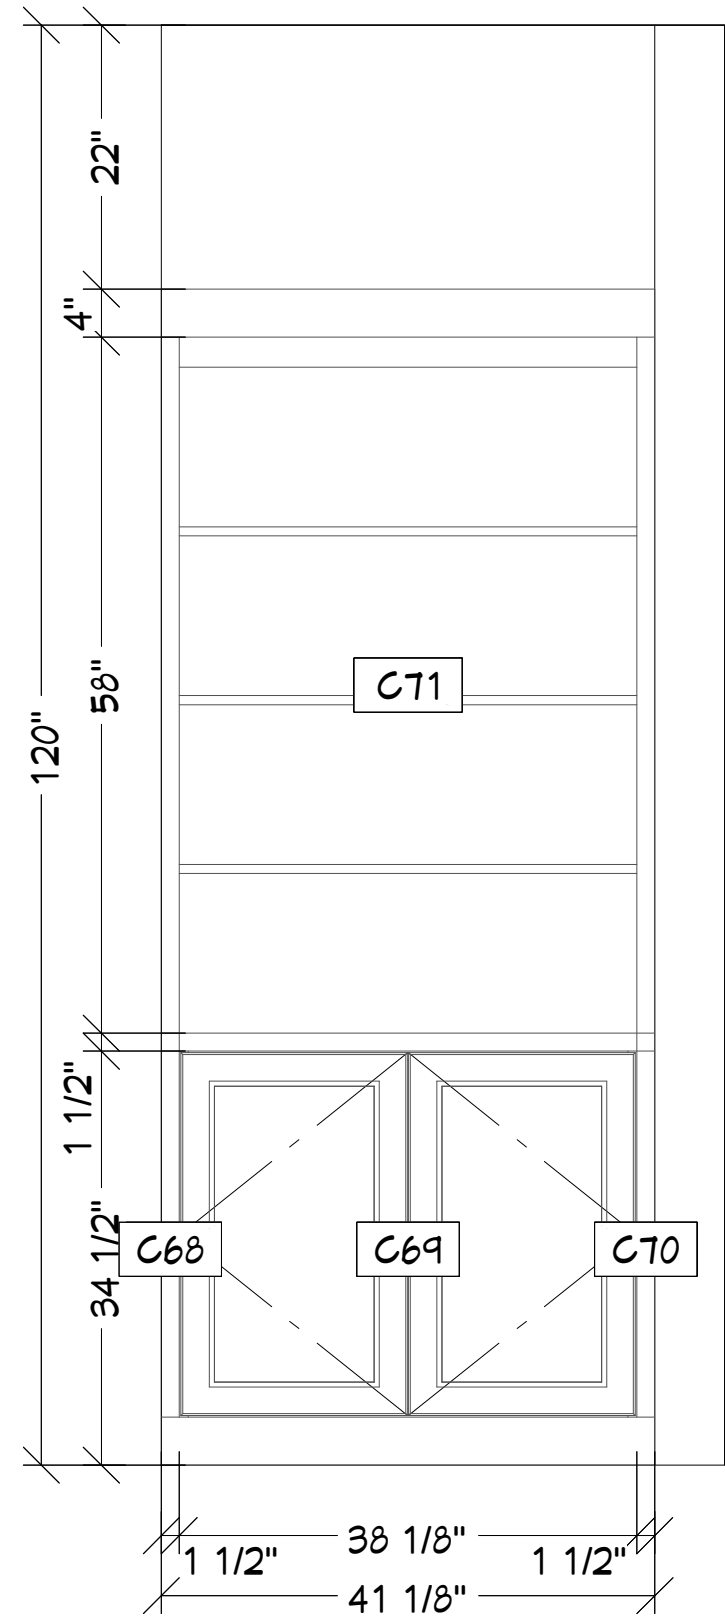

K
11 Hallway Built-In
3/4 in = 1 ft

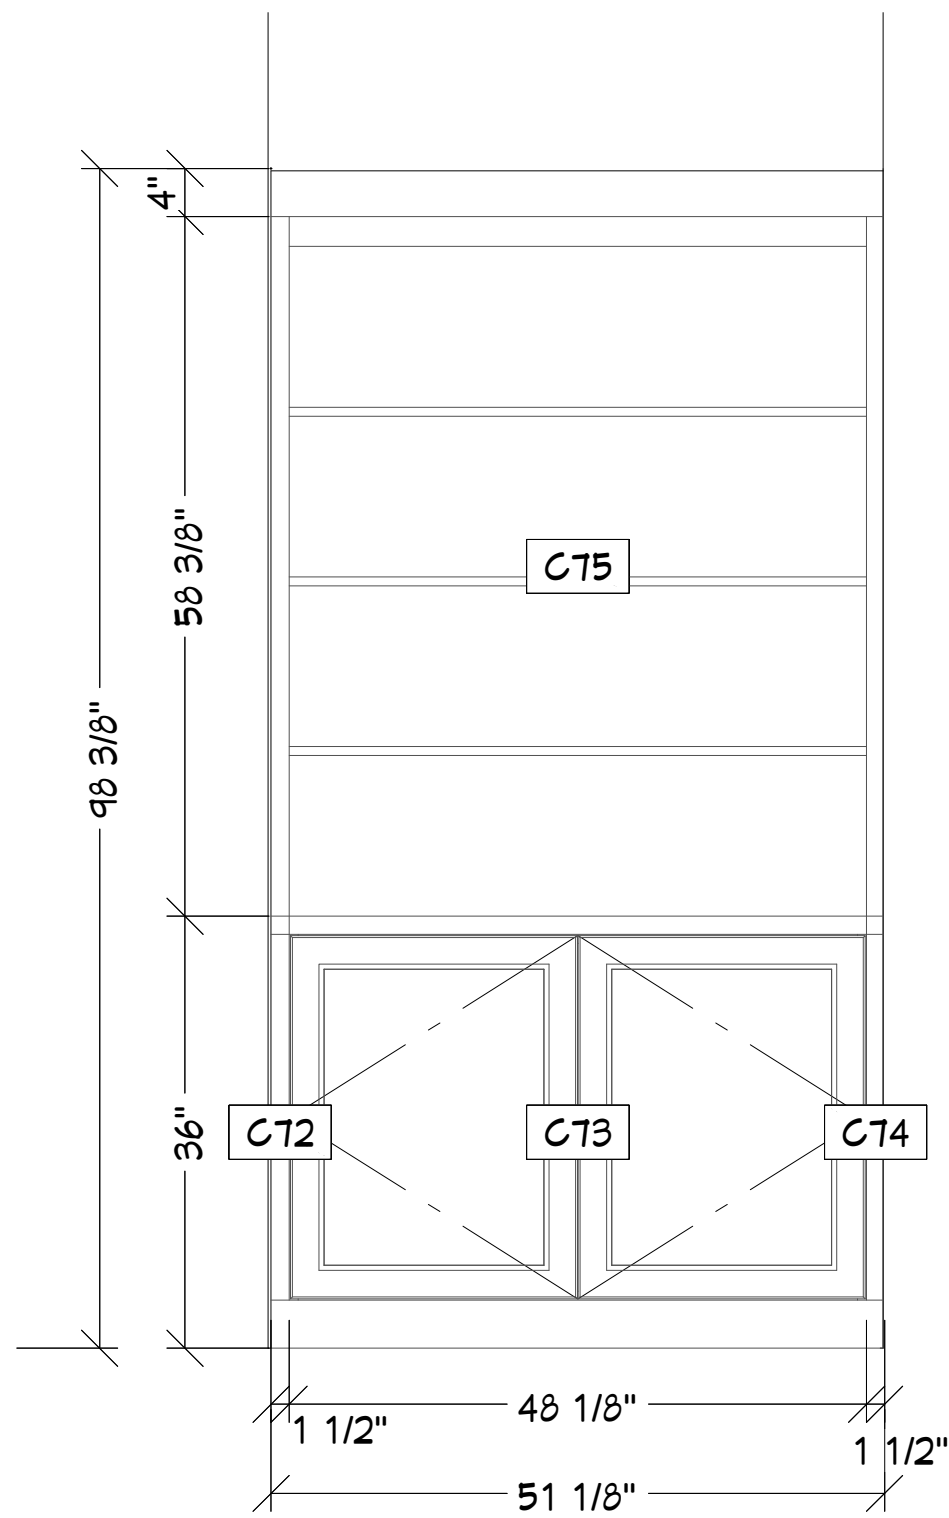


L
11 Living Room Built-In
3/4 in = 1 ft

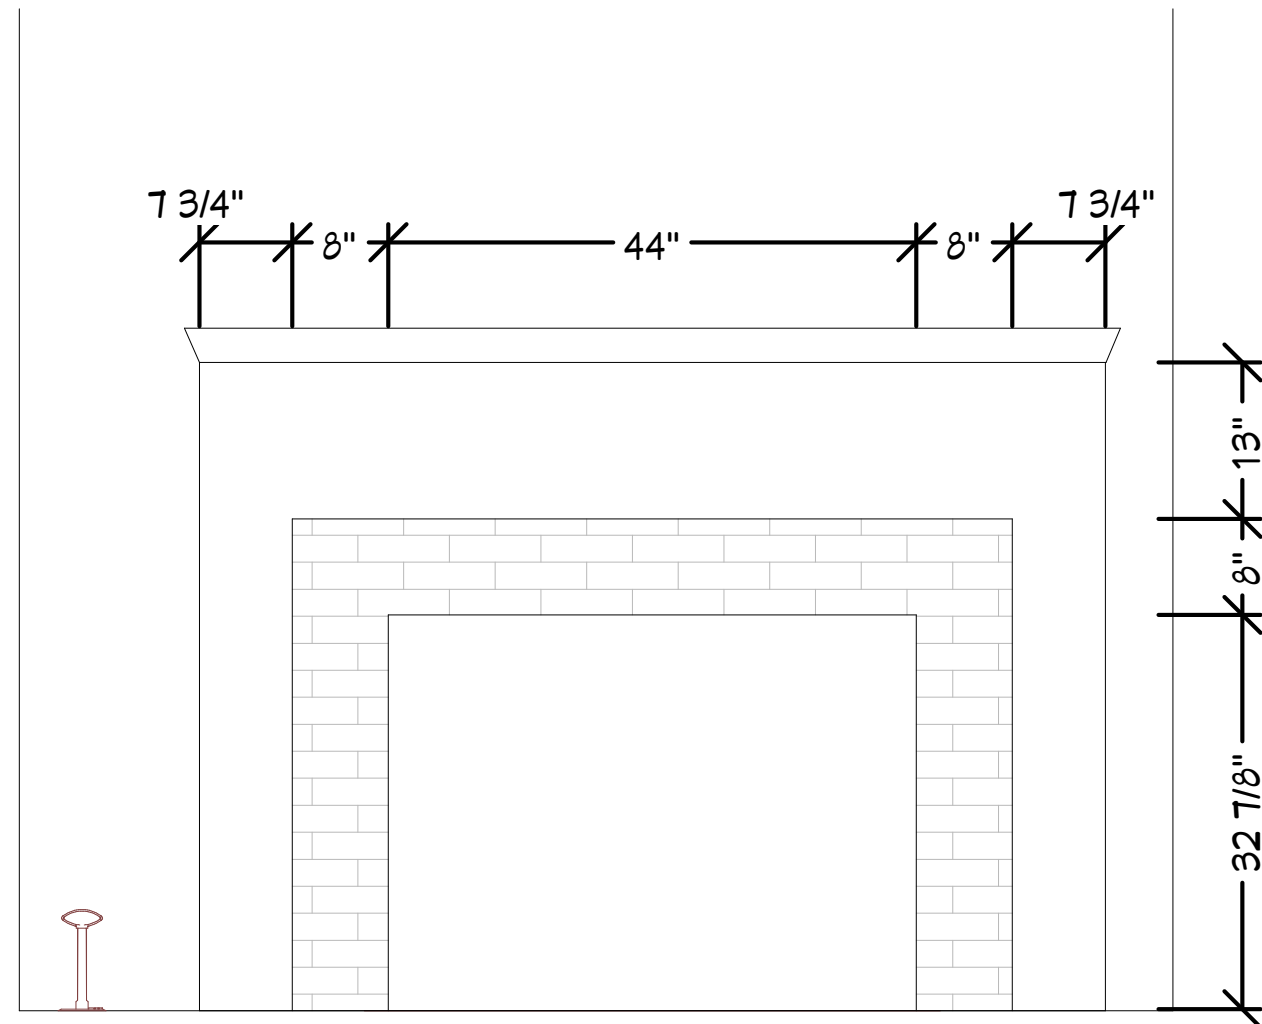

LFP
11 Living room FP
3/4 in = 1 ft



**11 LIVING ROOM AGAR 1 PIECE MANTLE
& PILLASTER UNIT**

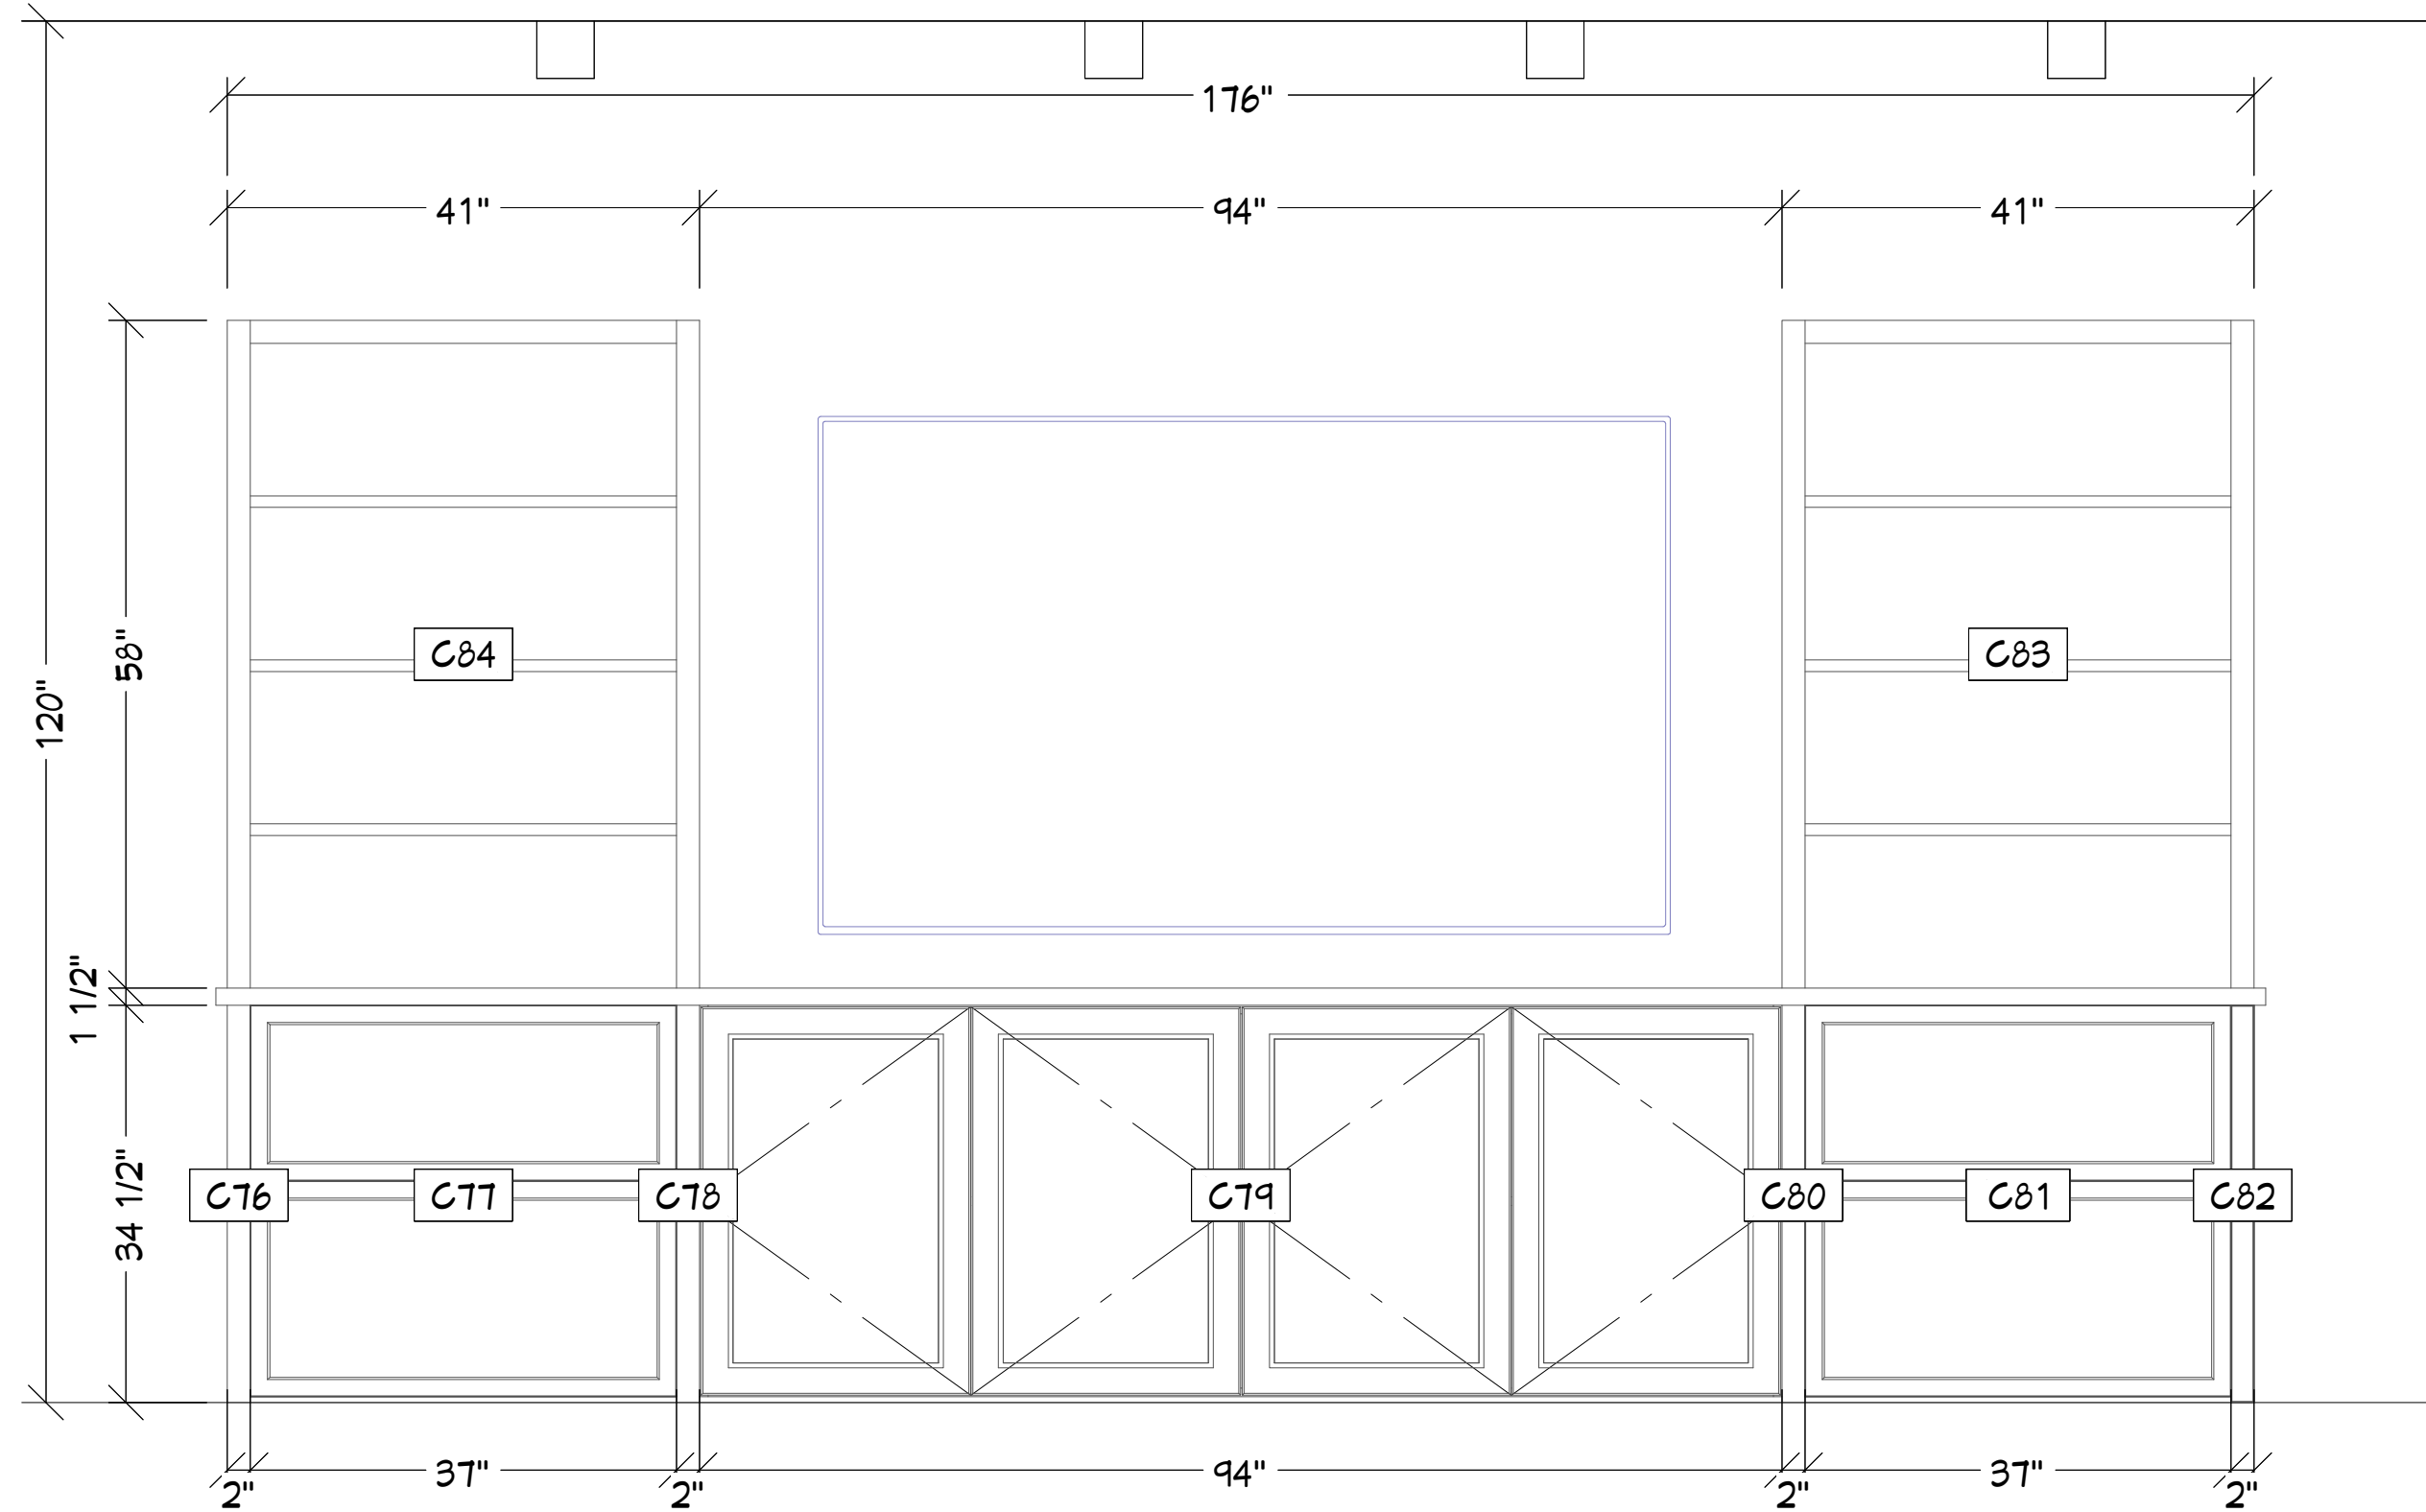

M
11 Living Room Media Center
3/4 in = 1 ft

3D VIEWS ARE NOT TO
SCALE AND MAY NOT
REFLECT EXACTLY WHAT
IS AVAILABLE FOR THE
PROJECT. RENDER VIEWS
ARE REPRESENTATIONS
OF WHAT THE VIEW
COULD LOOK LIKE, NOT
WHAT IT WILL LOOK LIKE.
2D VIEWS ALWAYS
SUPERCEDE 3D VIEWS

Renowned Group
4848 Lemmon Ave, suite 106,
Dallas, TX, 75219
PHONE: 972-232-7122 EMAIL: info@renowned-group.com

LICENSE NUMBER:
BU118842

REMODEL PLANS FOR:
Plassick Morton
3504 Villanova St
Dallas, TX, 75225

PAGE TITLE:
Living Room & Hall

DRAWN BY:
MB

DATE:
5/7/25

SCALE:
3/4" = 1' 0"

SHEET #:
11

3D VIEWS ARE NOT TO SCALE AND MAY NOT REFLECT EXACTLY WHAT IS AVAILABLE FOR THE PROJECT. RENDER VIEWS ARE REPRESENTATIONS OF WHAT THE VIEW COULD LOOK LIKE, NOT WHAT IT WILL LOOK LIKE. 2D VIEWS ALWAYS SUPERCEDE 3D VIEWS



Renowned Group
4848 Lemmon Ave, suite 106,
Dallas, TX, 75219
PHONE: 972-232-7122 EMAIL: info@renowned-group.com

LICENSE NUMBER:
BU118842

REMODEL PLANS FOR:
Plassick Morton
3504 Villanova St
Dallas, TX, 75225

PAGE TITLE:
3D Views Living & Hall


DRAWN BY:
MB

DATE:
5/7/25


SCALE:
NA

SHEET #:
12


13 NKBA - Kitchen & Bath Plan 1/2"
1/2 in = 1 ft

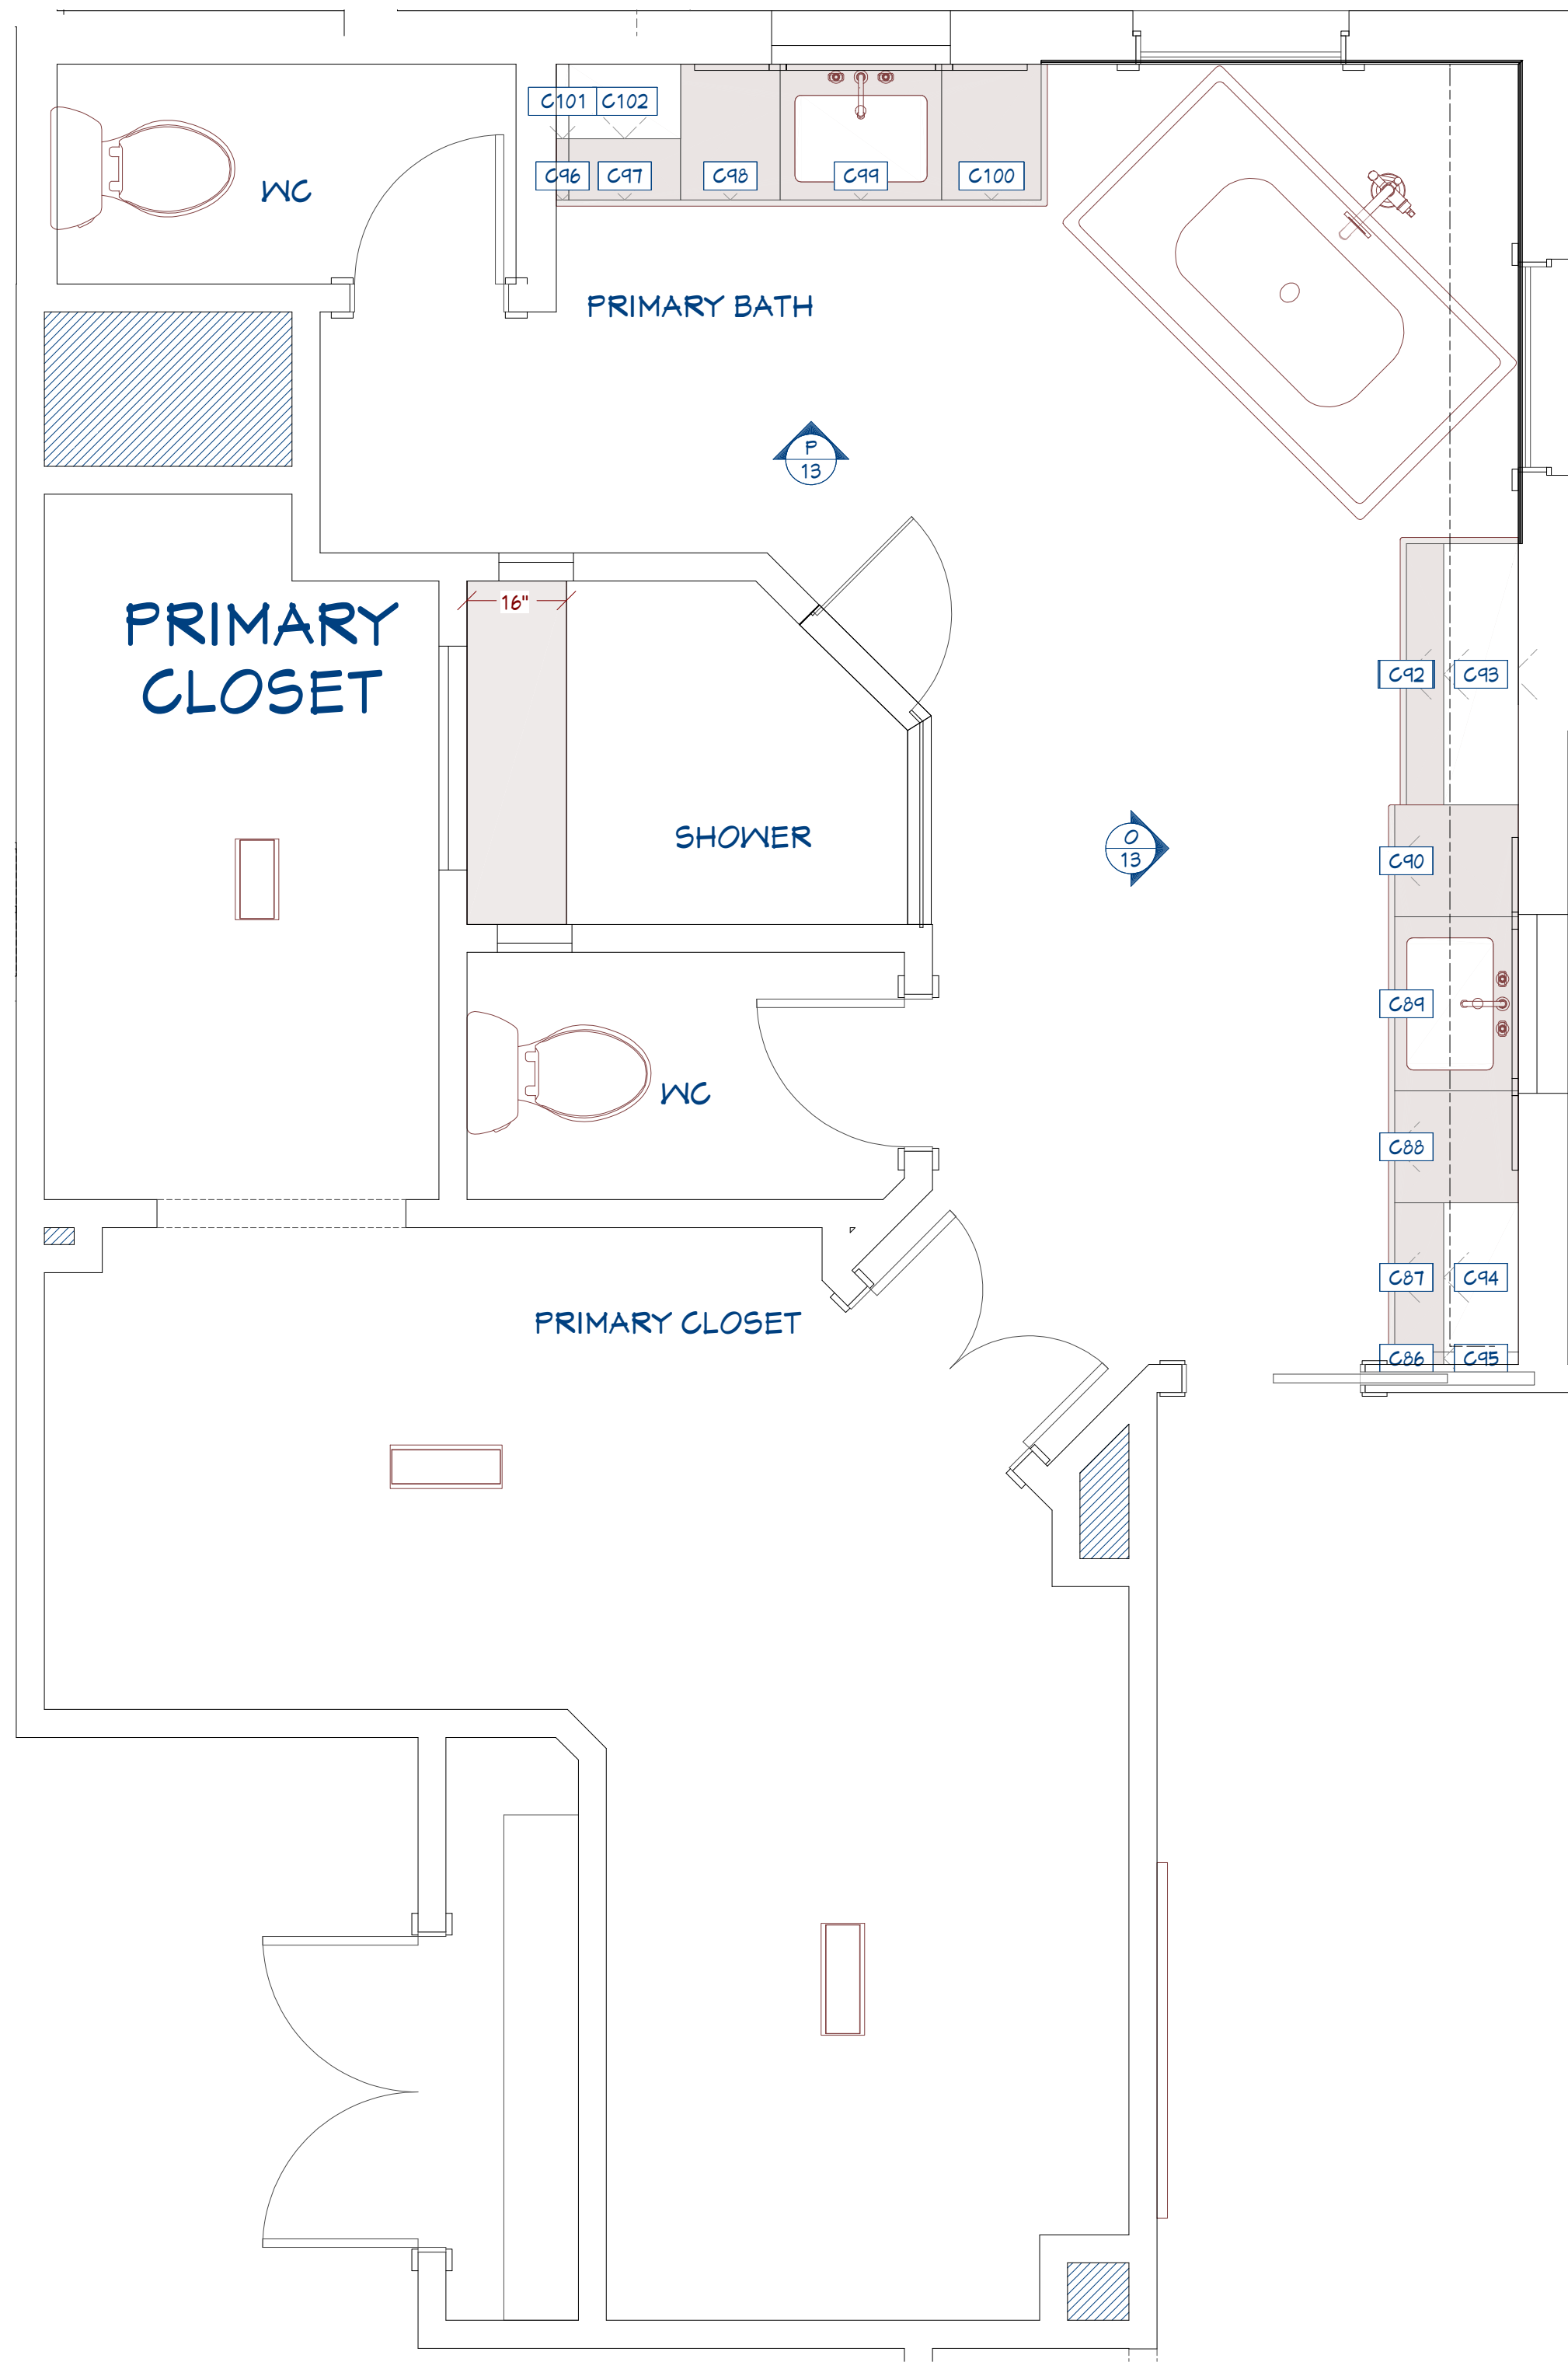

P 13 Primary Bath L
3/4 in = 1 ft

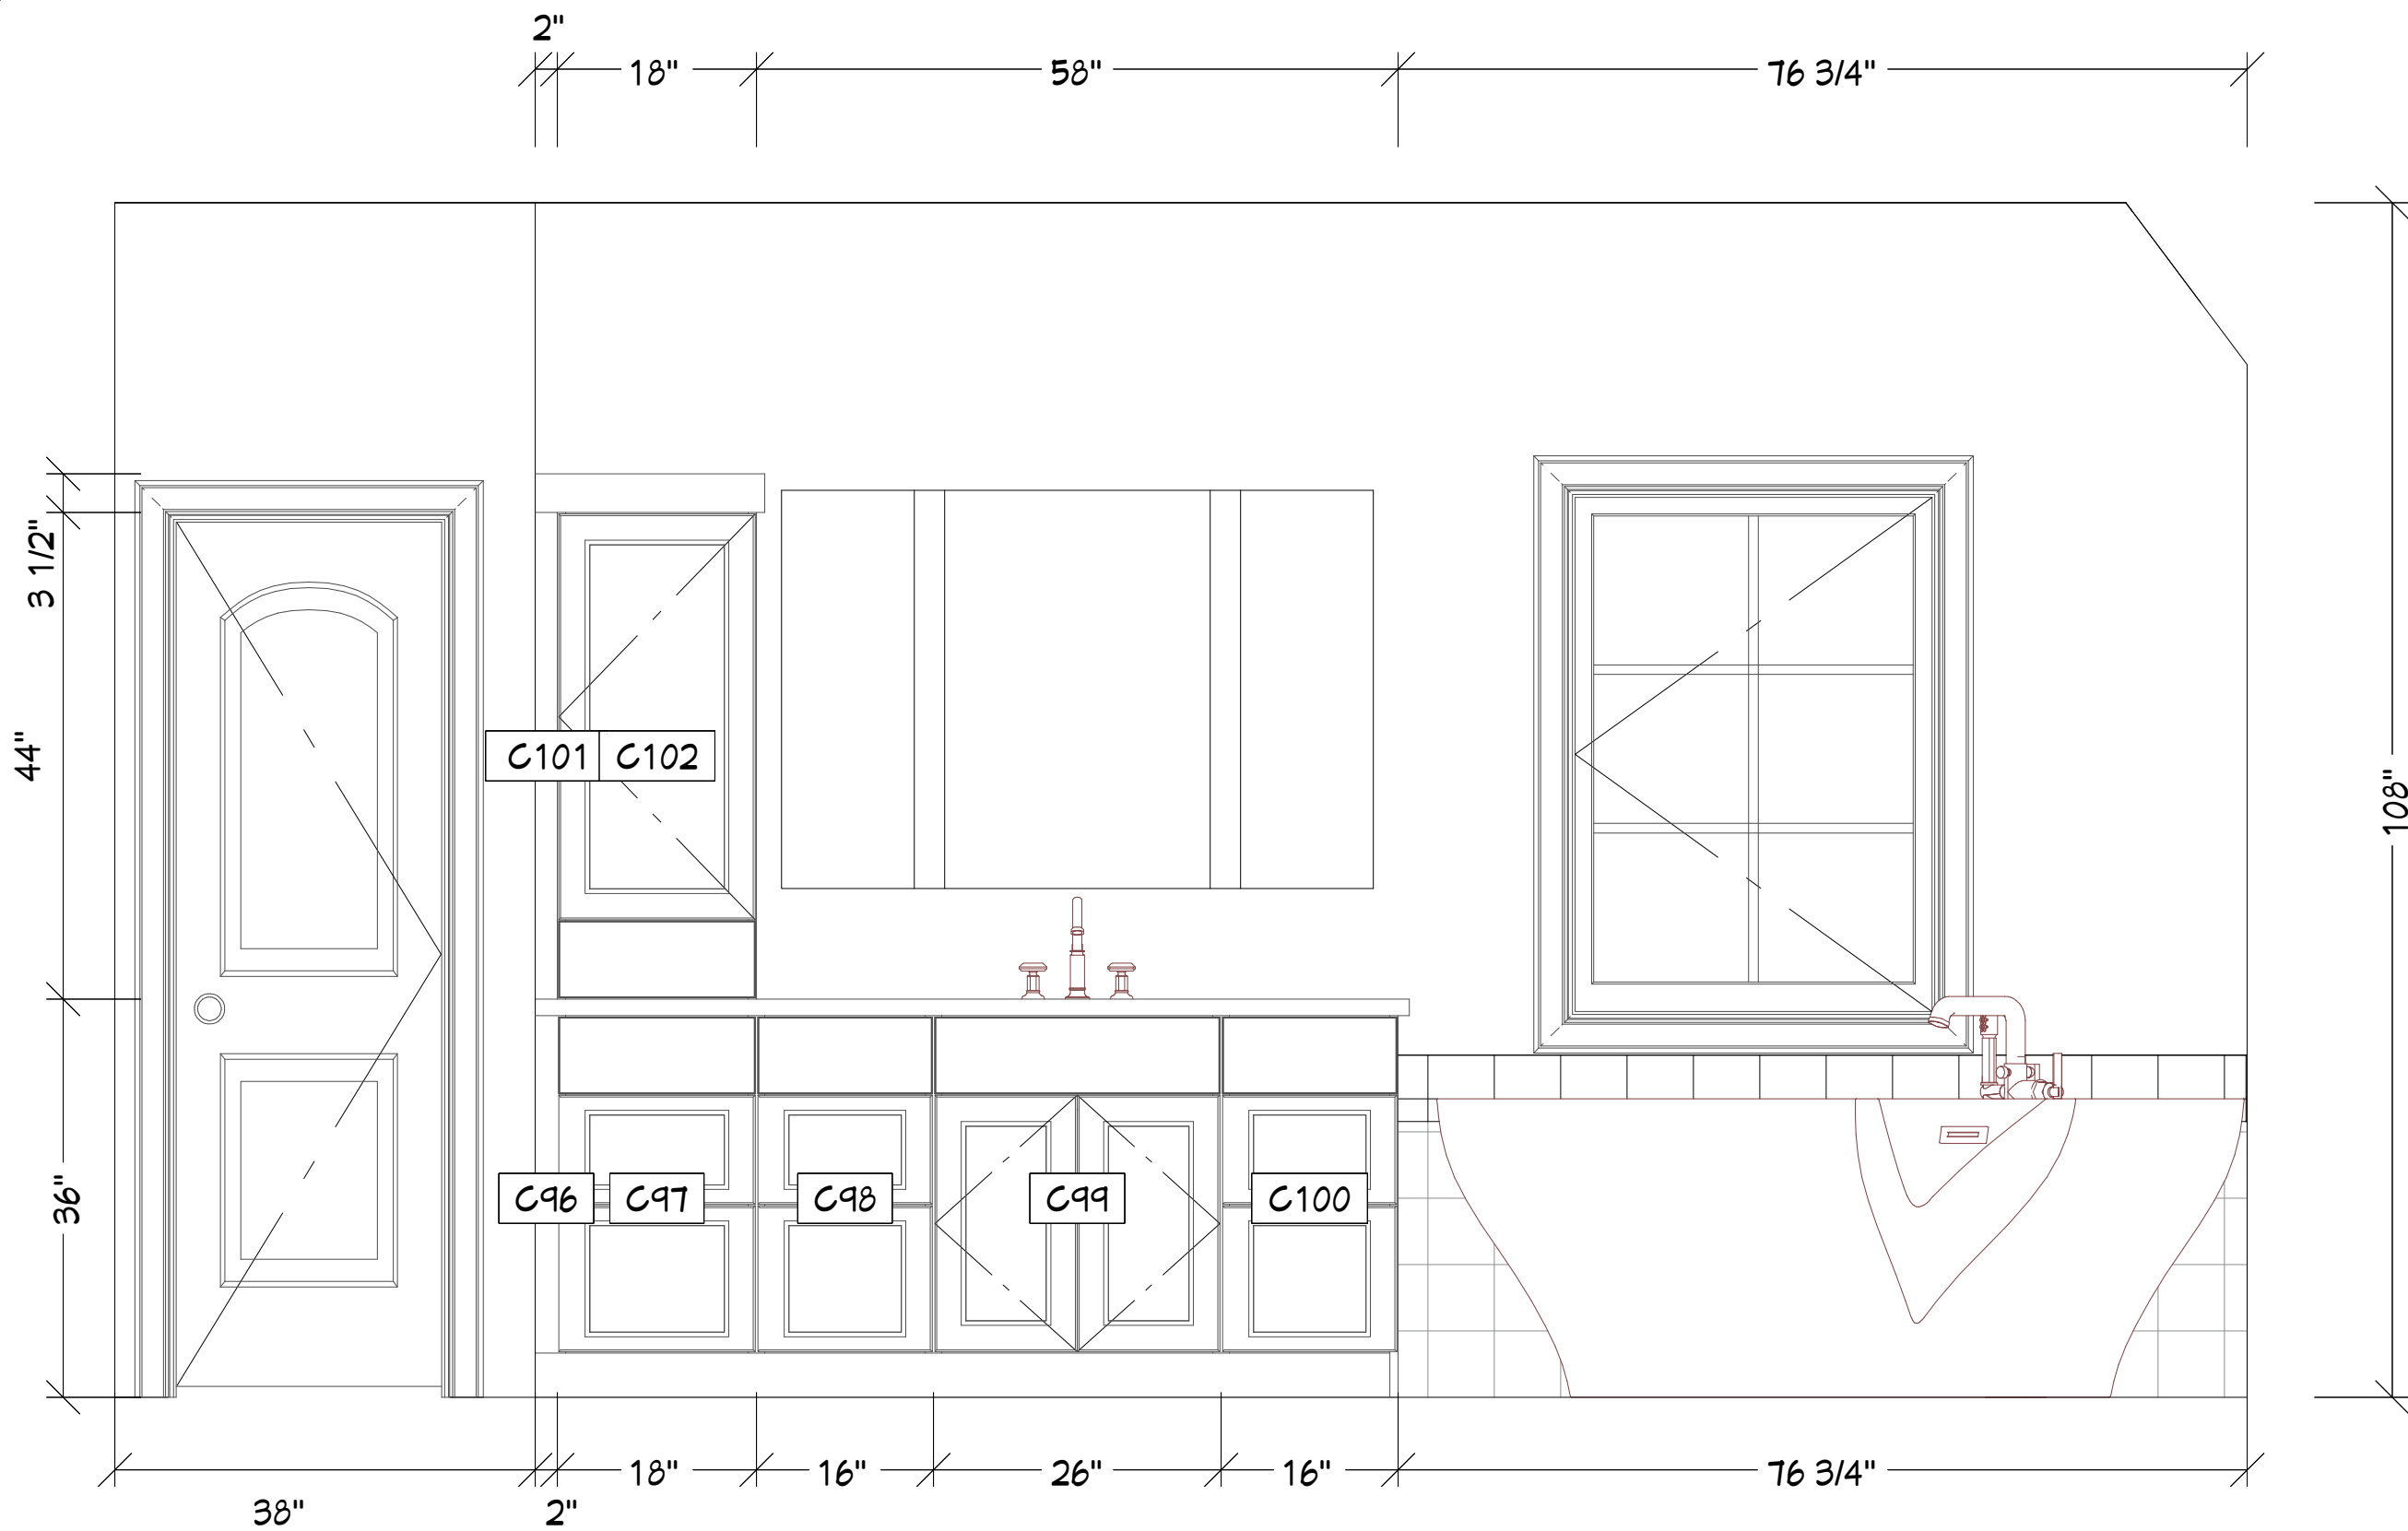

O 13 Primary Bath R
3/4 in = 1 ft

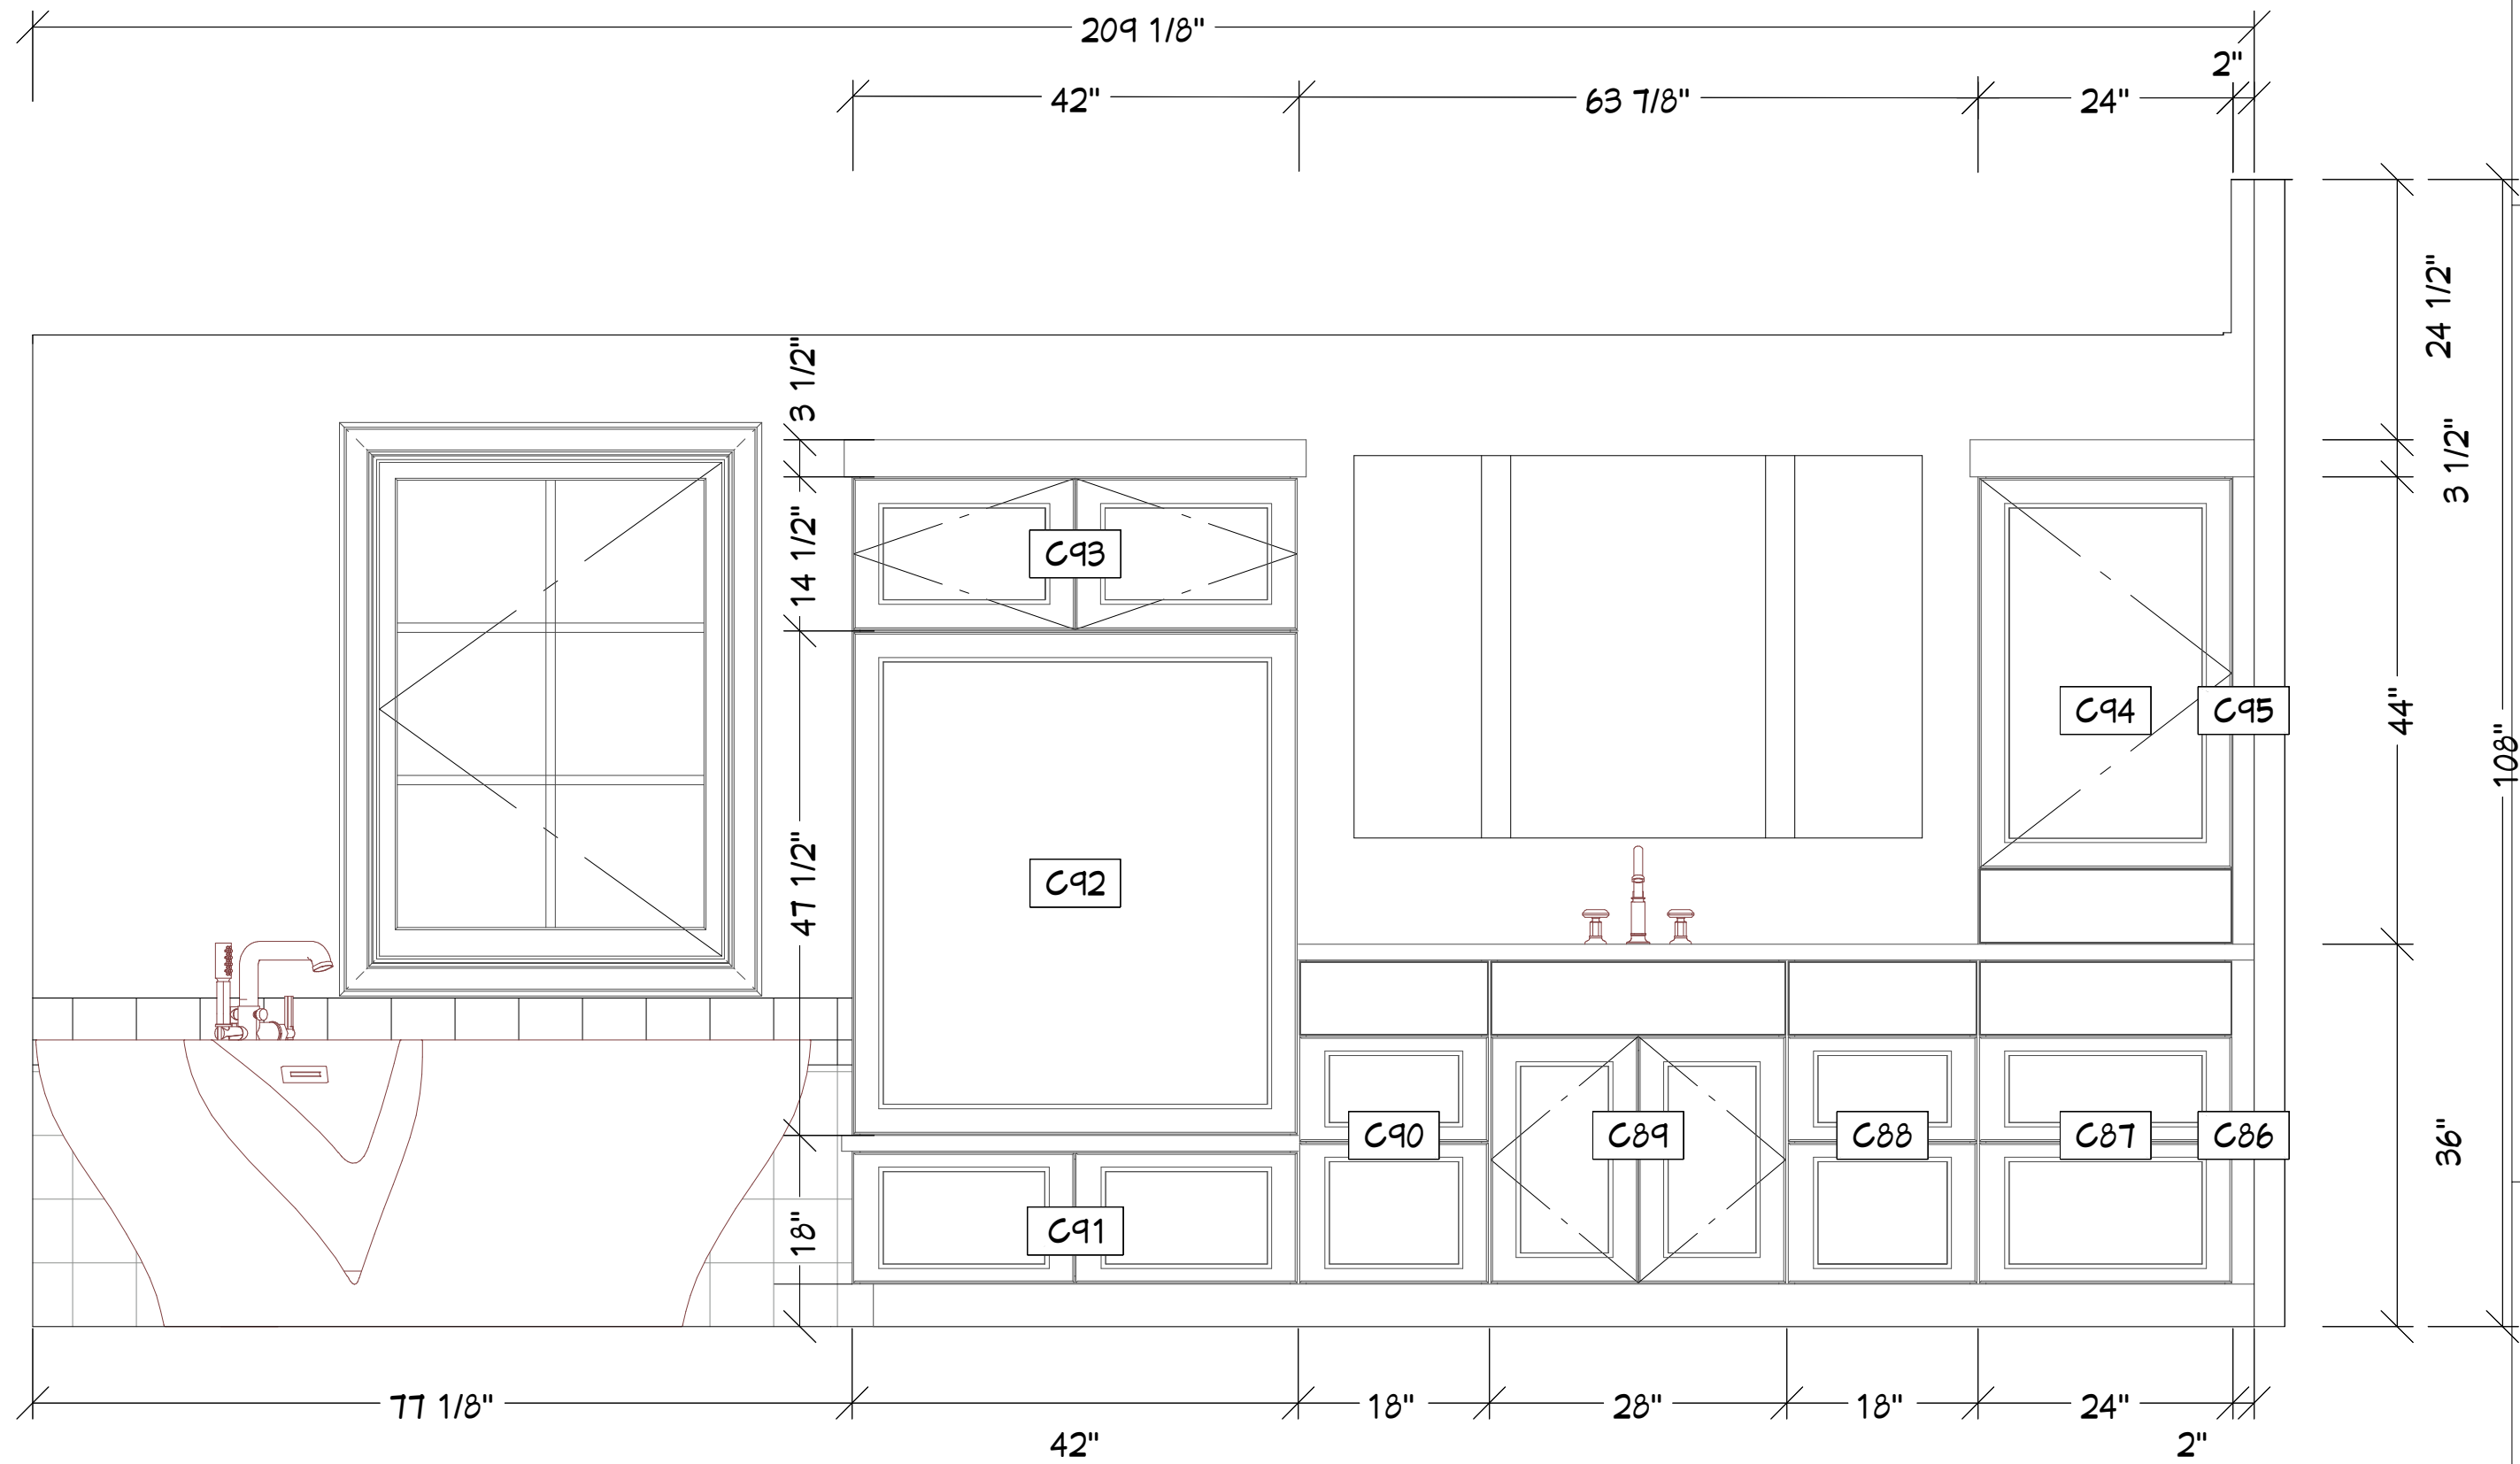

3D VIEWS ARE NOT TO SCALE AND MAY NOT REFLECT EXACTLY WHAT IS AVAILABLE FOR THE PROJECT. RENDER VIEWS ARE REPRESENTATIONS OF WHAT THE VIEW COULD LOOK LIKE, NOT WHAT IT WILL LOOK LIKE. 2D VIEWS ALWAYS SUPERCEDE 3D VIEWS

Renowned Group
4848 Lemmon Ave, suite 106,
Dallas, TX, 75219
PHONE: 972-232-7122 EMAIL: info@renowned-group.com

LICENSE NUMBER:
BU118842

REMODEL PLANS FOR:
Plassick Morton
3504 Villanova St
Dallas, TX, 75225

PAGE TITLE:
Primary Bath

DRAWN BY:
MB

DATE:
5/7/25

SCALE:
Multiple

SHEET #:
13



3D VIEWS ARE NOT TO SCALE AND MAY NOT REFLECT EXACTLY WHAT IS AVAILABLE FOR THE PROJECT. RENDER VIEWS ARE REPRESENTATIONS OF WHAT THE VIEW COULD LOOK LIKE, NOT WHAT IT WILL LOOK LIKE. 2D VIEWS ALWAYS SUPERCEDE 3D VIEWS

Renowned Group
4848 Lemmon Ave, suite 106,
Dallas, TX, 75219
PHONE: 972-232-7122 EMAIL: info@renowned-group.com

LICENSE NUMBER:
BU118842

REMODEL PLANS FOR:
Plassick Morton
3504 Villanova St
Dallas, TX, 75225

PAGE TITLE:
3D Views Primary Bath

DRAWN BY:
MB

DATE:
5/7/25

SCALE:
NA

SHEET #:
14

3D VIEWS ARE NOT TO SCALE AND MAY NOT REFLECT EXACTLY WHAT IS AVAILABLE FOR THE PROJECT. RENDER VIEWS ARE REPRESENTATIONS OF WHAT THE VIEW COULD LOOK LIKE, NOT WHAT IT WILL LOOK LIKE. 2D VIEWS ALWAYS SUPERCEDE 3D VIEWS

Renowned Group
4848 Lemmon Ave, suite 106,
Dallas, TX, 75219
PHONE: 972-232-7122 EMAIL: info@renowned-group.com

LICENSE NUMBER:

BU118842

REMODEL PLANS FOR:

Plassick Morton
3504 Villanova St
Dallas, TX, 75225

PAGE TITLE:

**Inlaw, Flex, Maggie's
Baths**

DRAWN BY:

MB

DATE:


5/7/25

SCALE:


Multiple

SHEET #:


15

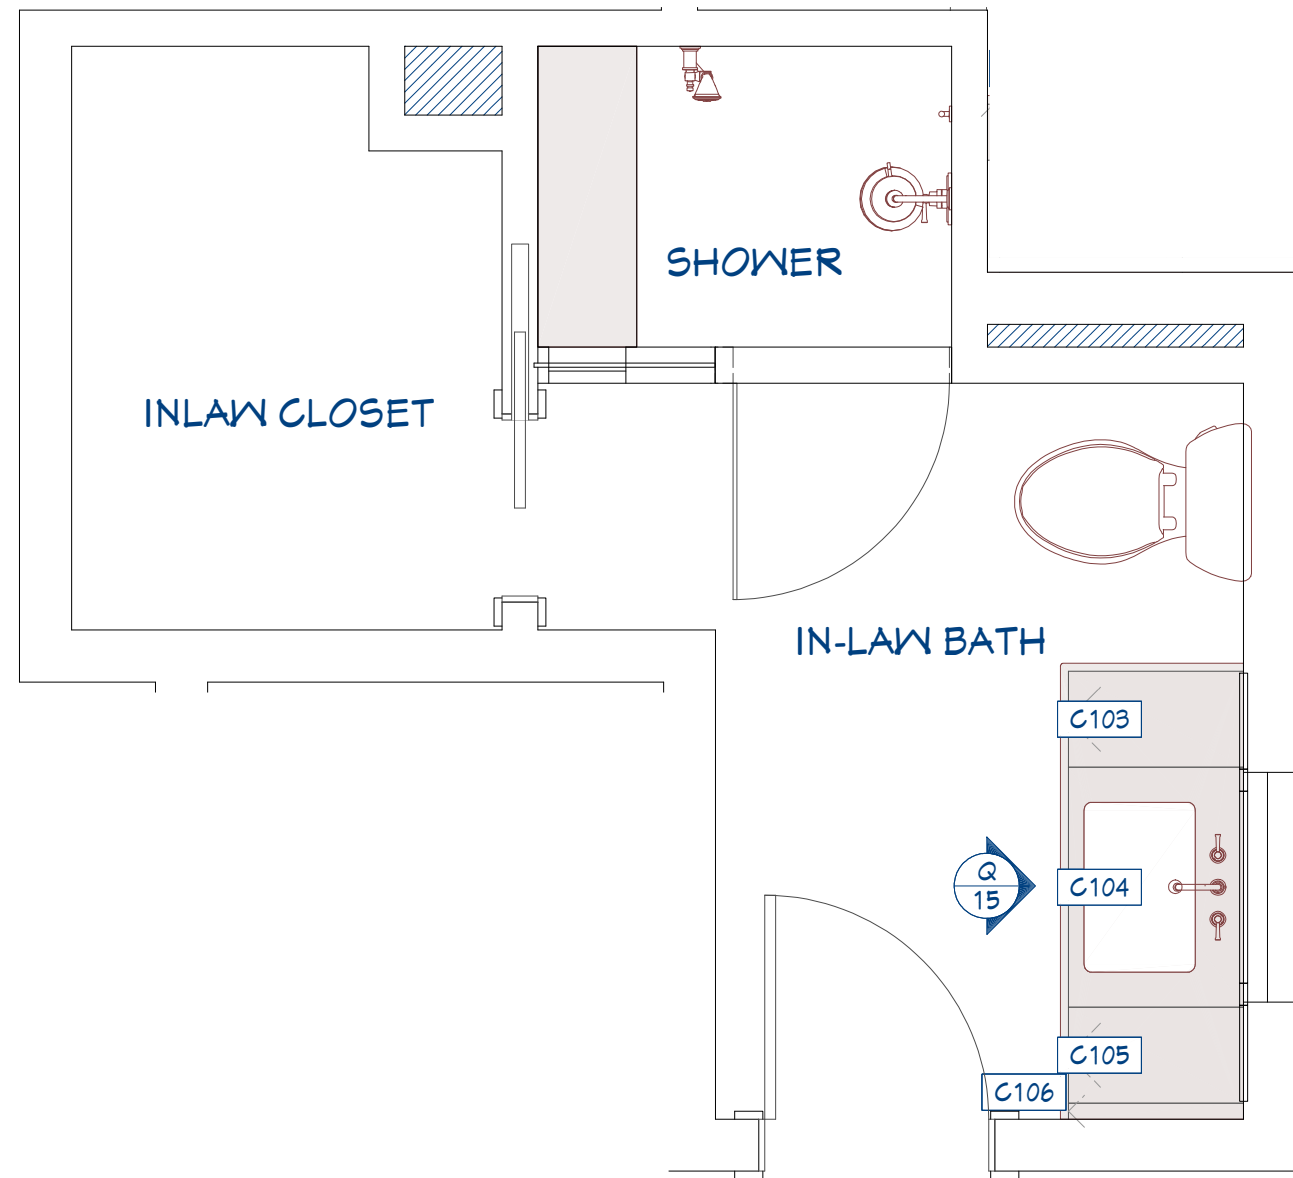


15 NKBA - Kitchen & Bath Plan 1/2"
1/2 in = 1 ft

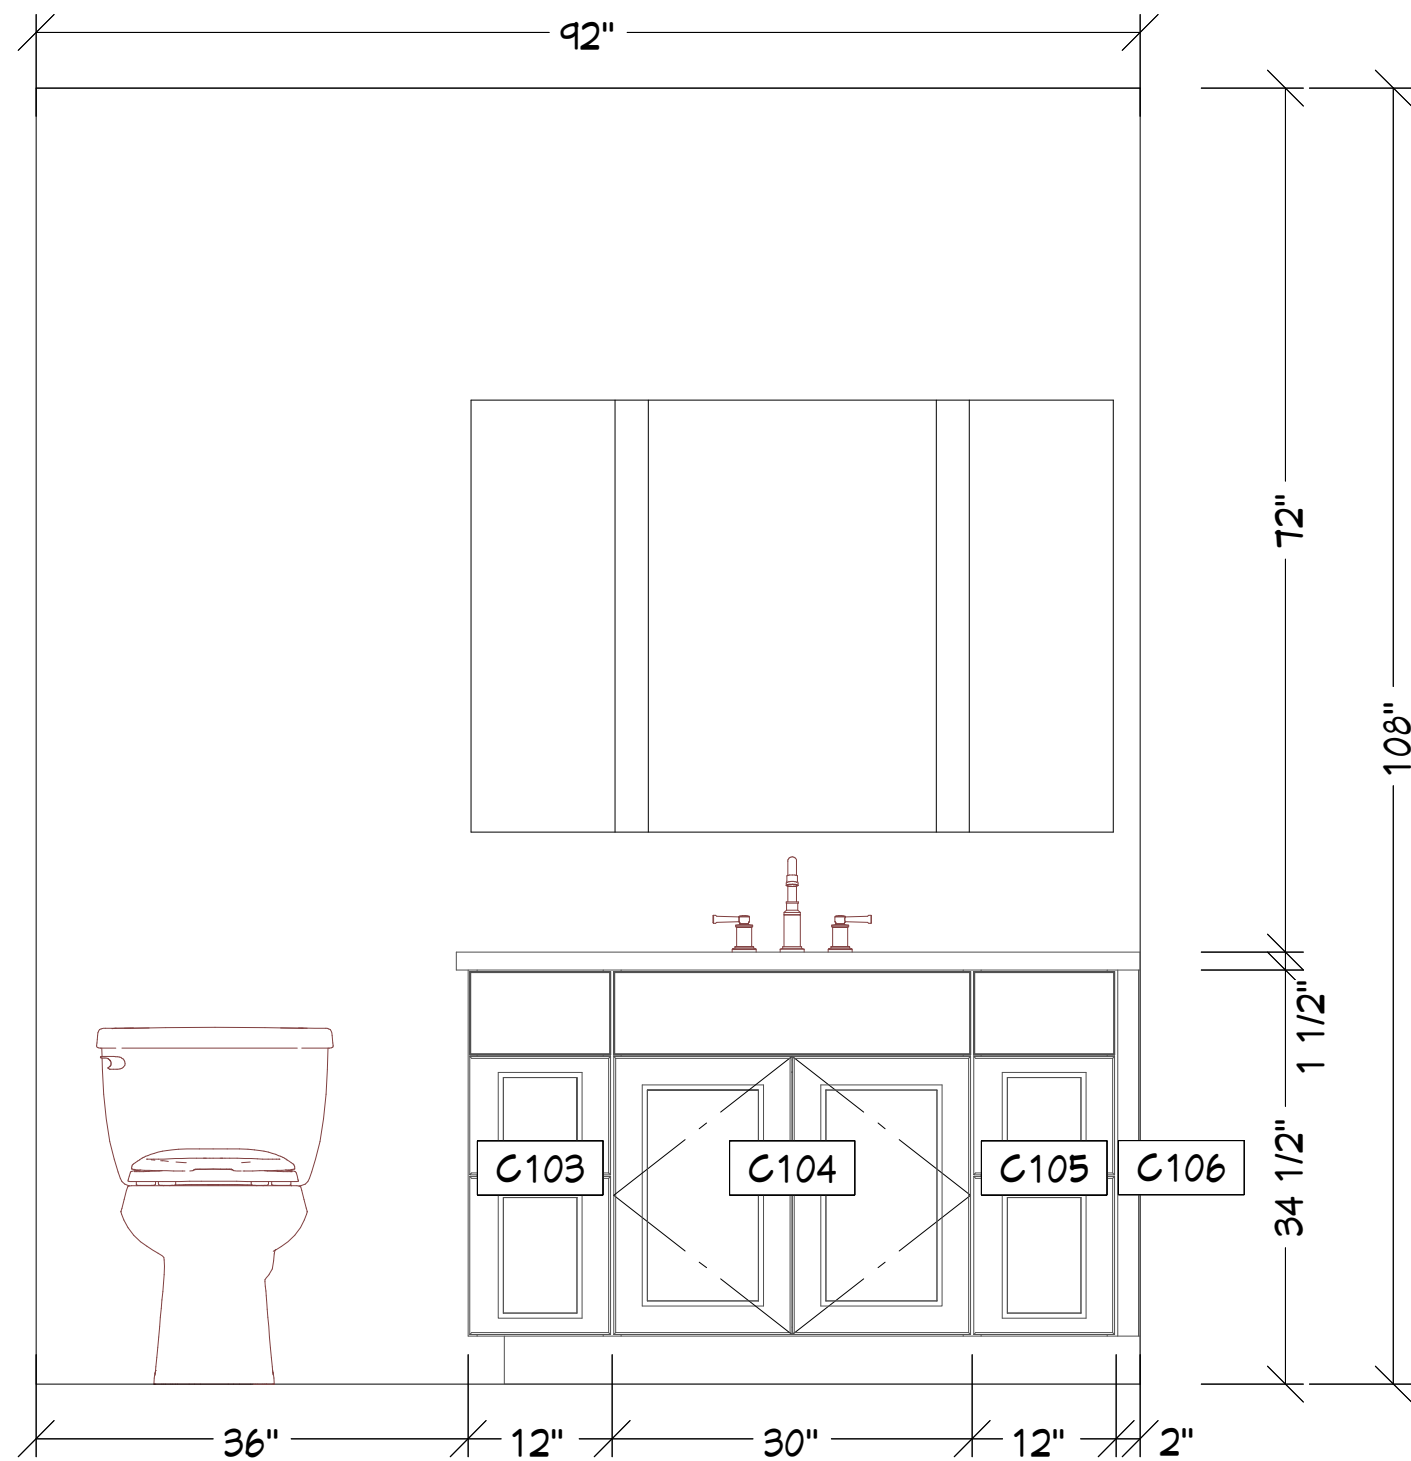


Q 15 In-Law Bath
3/4 in = 1 ft

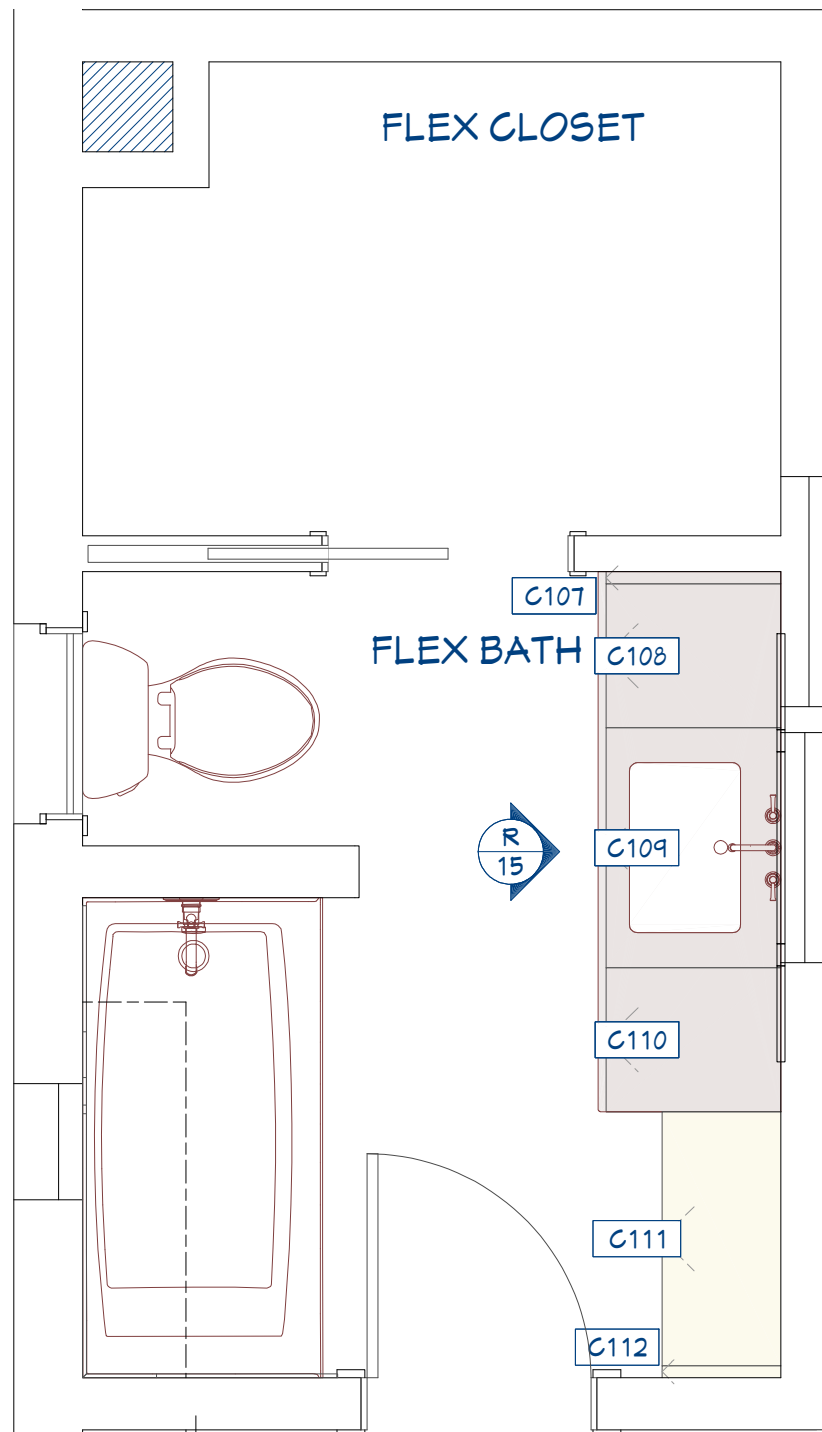


15 NKBA - Kitchen & Bath Plan 1/2"
1/2 in = 1 ft

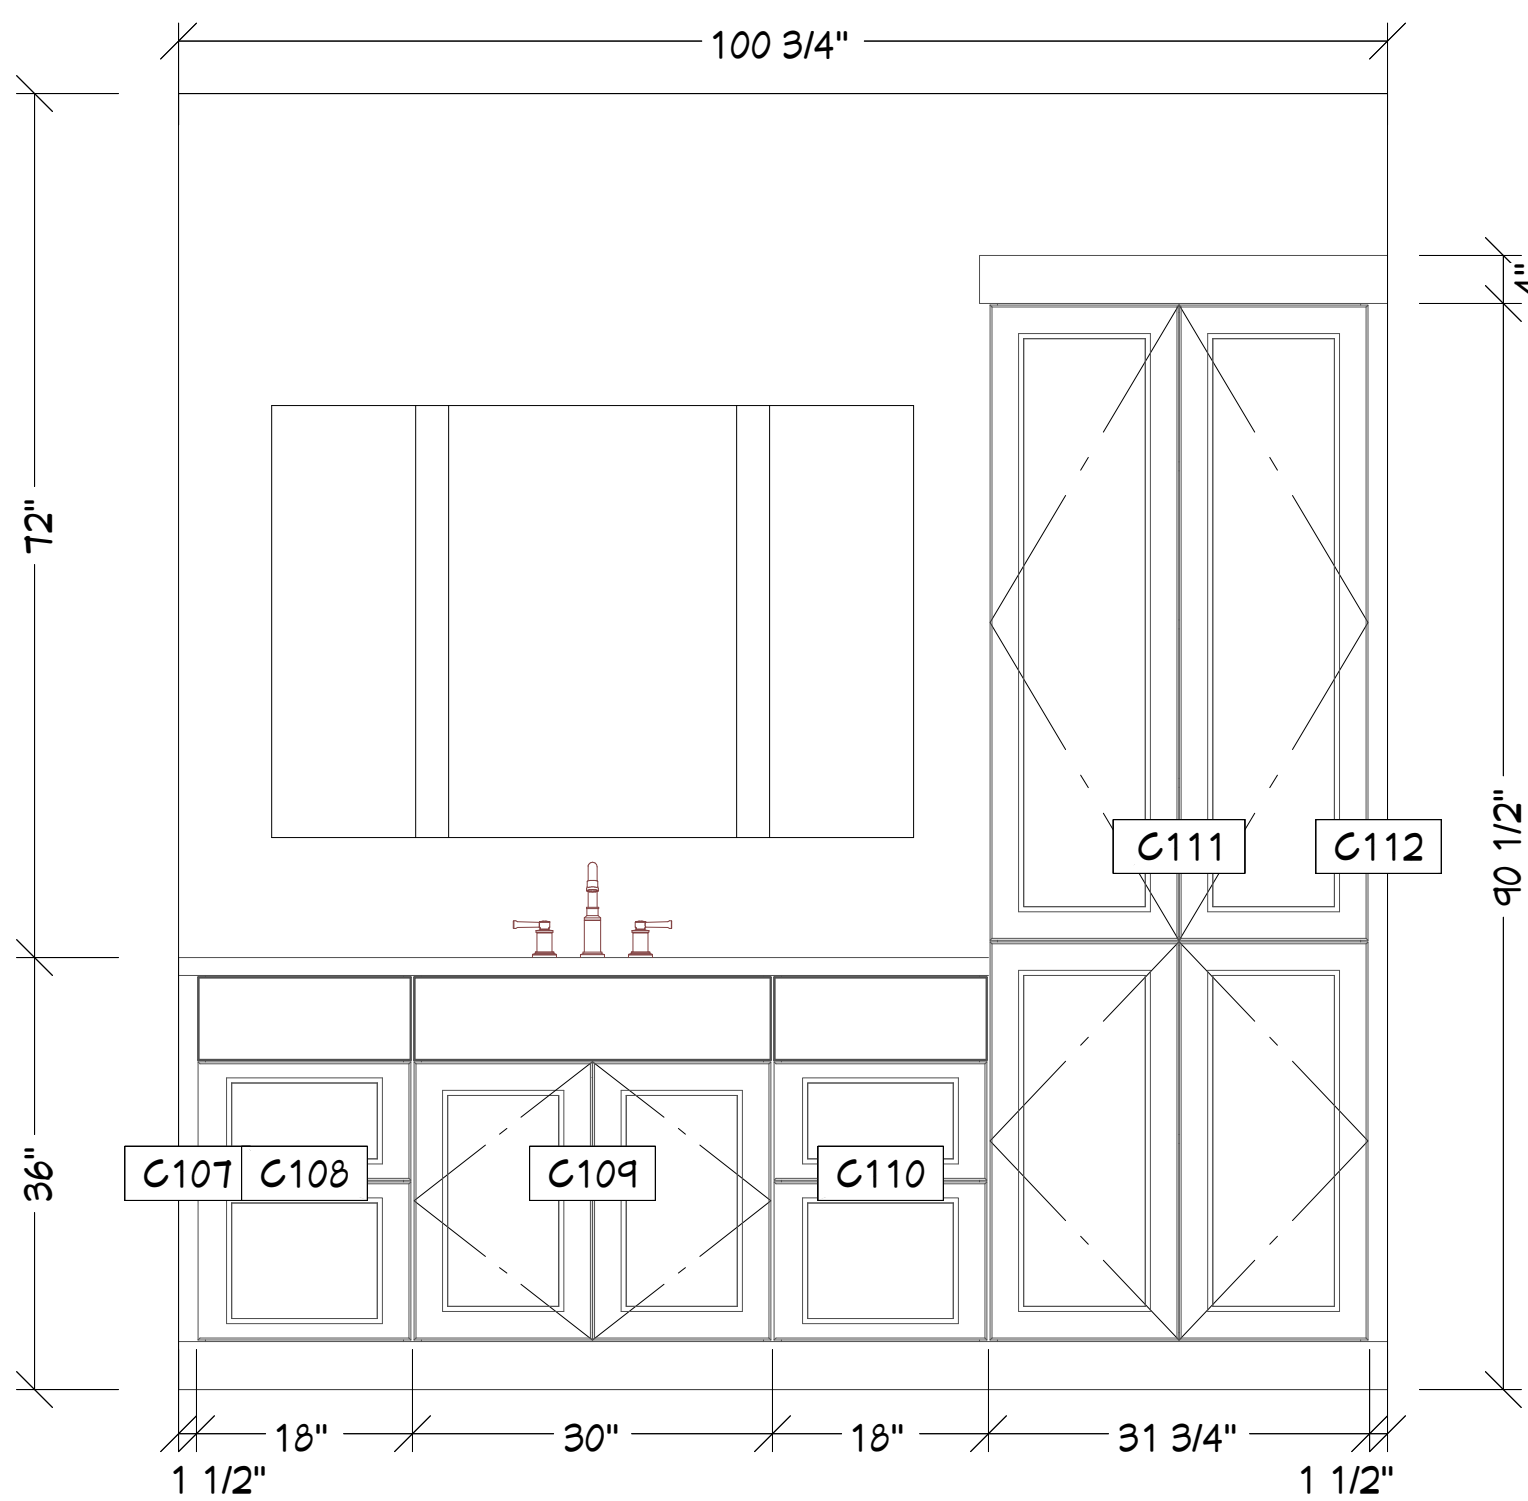

R 15 Flex Bath
3/4 in = 1 ft

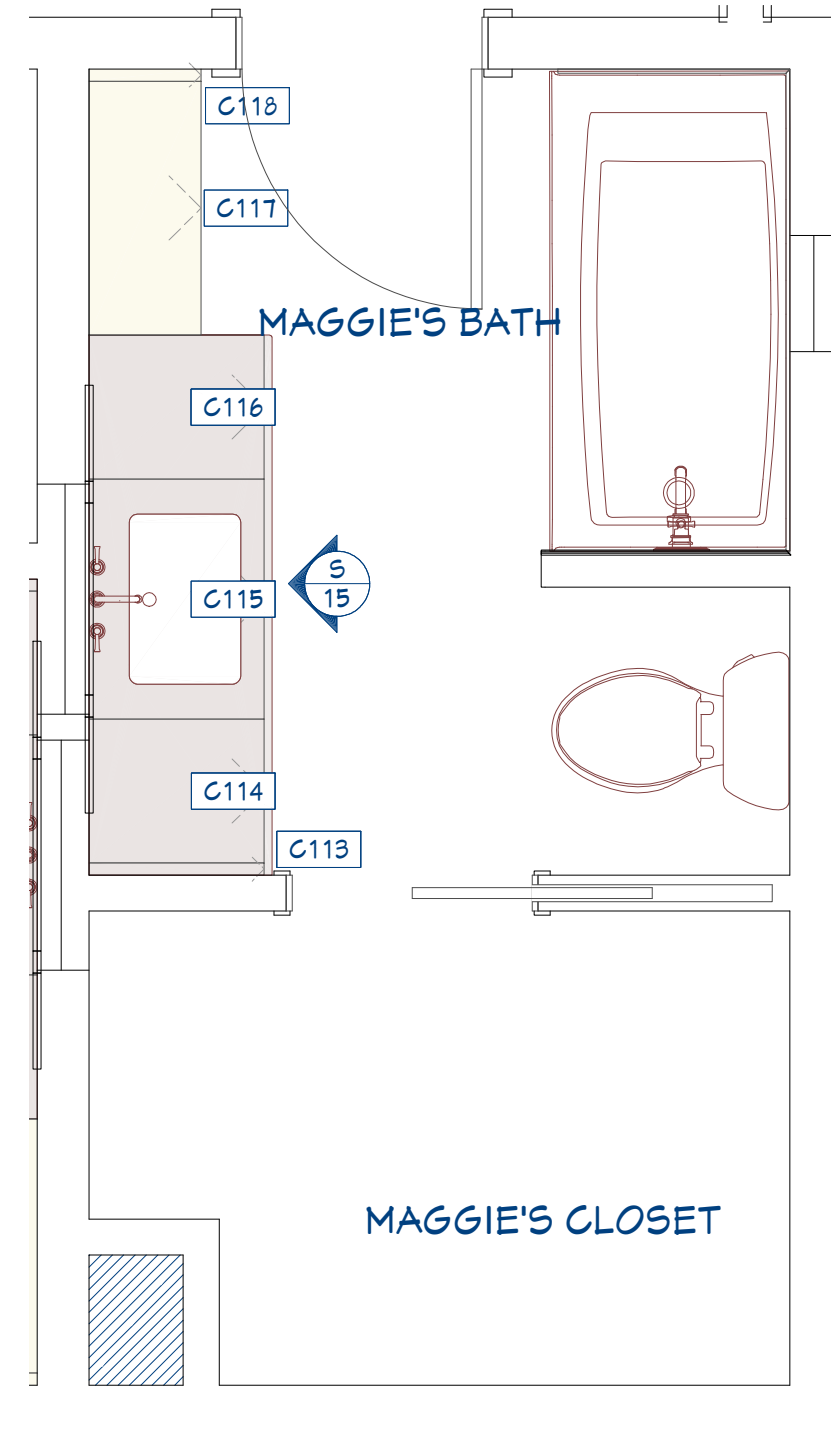

15 NKBA - Kitchen & Bath Plan 1/2"
1/2 in = 1 ft

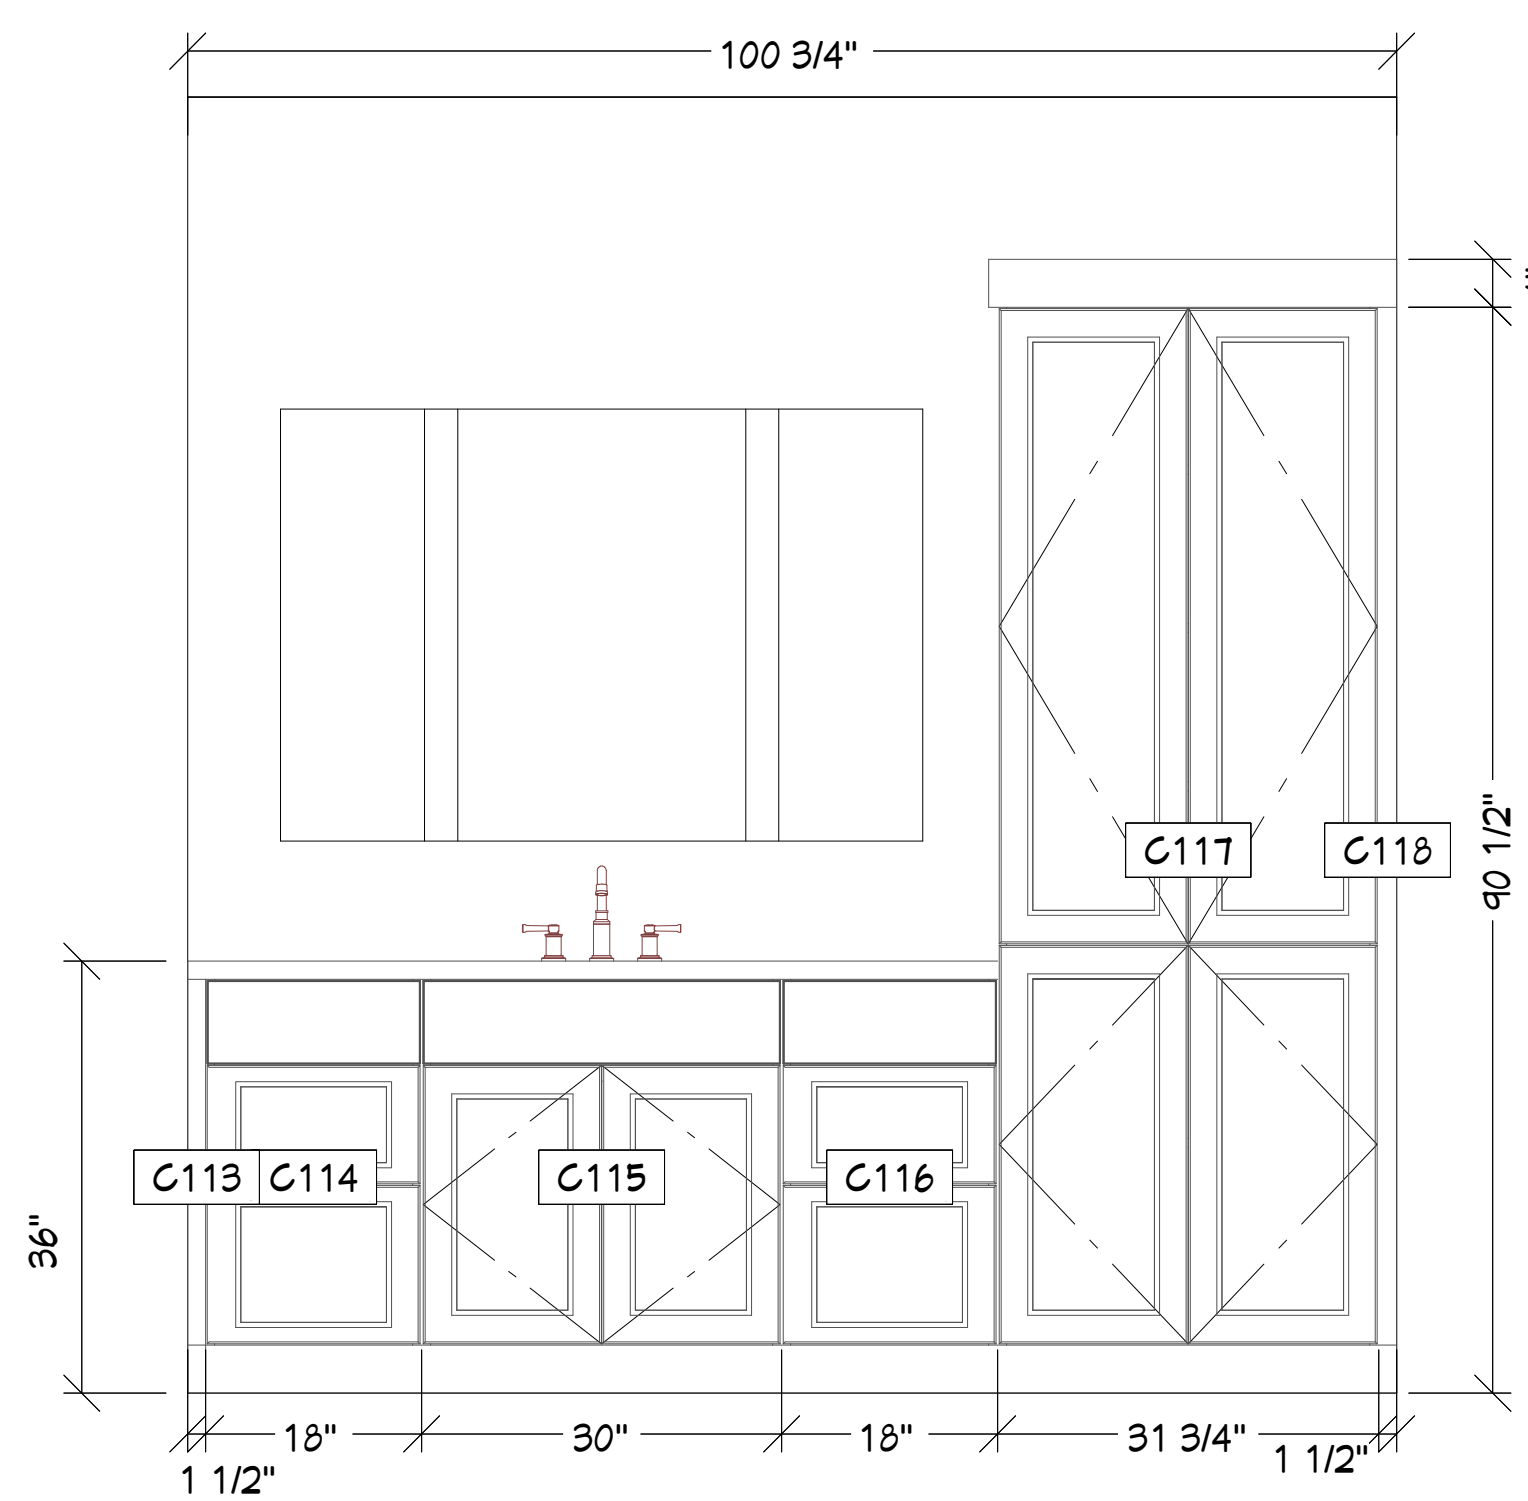

S 15 Maggie's Bath
3/4 in = 1 ft



3D VIEWS ARE NOT TO SCALE AND MAY NOT REFLECT EXACTLY WHAT IS AVAILABLE FOR THE PROJECT. RENDER VIEWS ARE REPRESENTATIONS OF WHAT THE VIEW COULD LOOK LIKE, NOT WHAT IT WILL LOOK LIKE. 2D VIEWS ALWAYS SUPERCEDE 3D VIEWS

Renowned Group
4848 Lemmon Ave, suite 106,
Dallas, TX, 75219
PHONE: 972-232-7122 EMAIL: info@renowned-group.com

LICENSE NUMBER:
BU118842

REMODEL PLANS FOR:
Plassick Morton
3504 Villanova St
Dallas, TX, 75225

PAGE TITLE:
**3D Views Flex &
Maggie's Baths**

DRAWN BY:
MB

DATE:
5/7/25

SCALE:
NA

SHEET #:
16



3D VIEWS ARE NOT TO SCALE AND MAY NOT REFLECT EXACTLY WHAT IS AVAILABLE FOR THE PROJECT. RENDER VIEWS ARE REPRESENTATIONS OF WHAT THE VIEW COULD LOOK LIKE, NOT WHAT IT WILL LOOK LIKE. 2D VIEWS ALWAYS SUPERCEDE 3D VIEWS

Renowned Group
4848 Lemmon Ave, suite 106,
Dallas, TX, 75219
PHONE: 972-232-7122 EMAIL: info@renowned-group.com

LICENSE NUMBER:
BU118842

REMODEL PLANS FOR:

Plassick Morton
3504 Villanova St
Dallas, TX, 75225

PAGE TITLE:


3D Views Inlaw Bath

DRAWN BY:
MB


DATE:
5/7/25

SCALE:
NA


SHEET #:
17

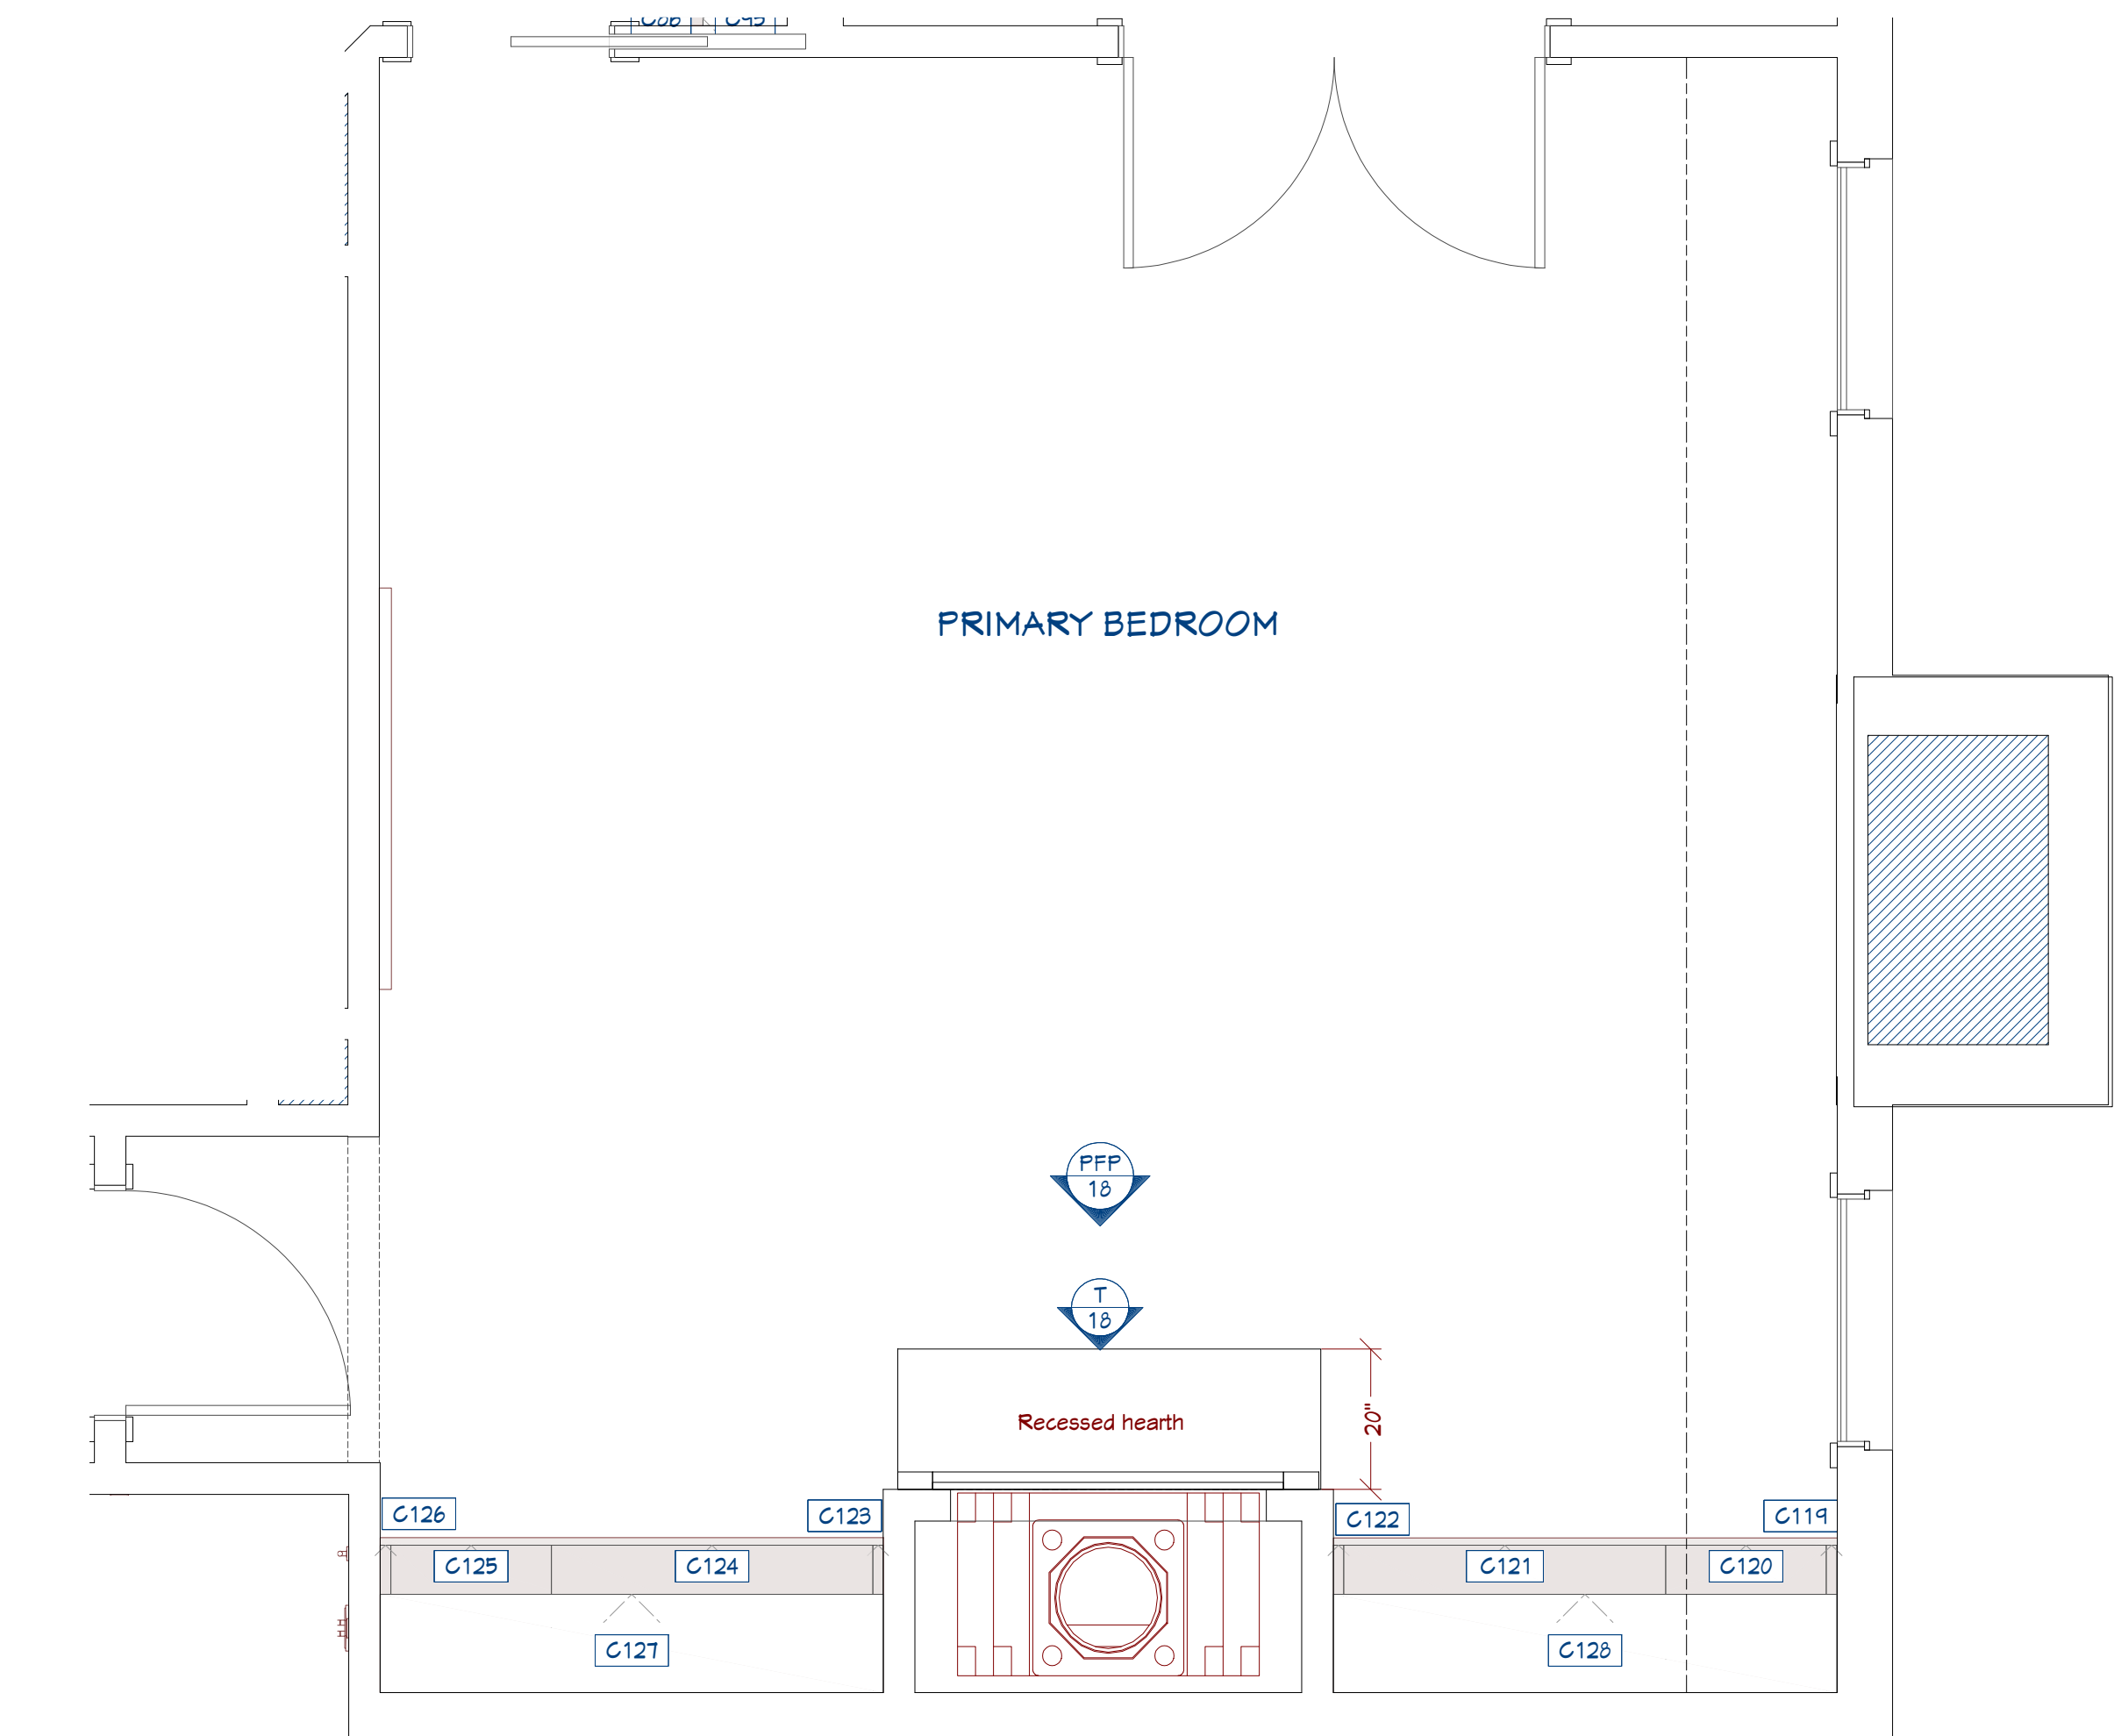


18 NKBA - Kitchen & Bath Plan 1/2"
1/2 in = 1 ft

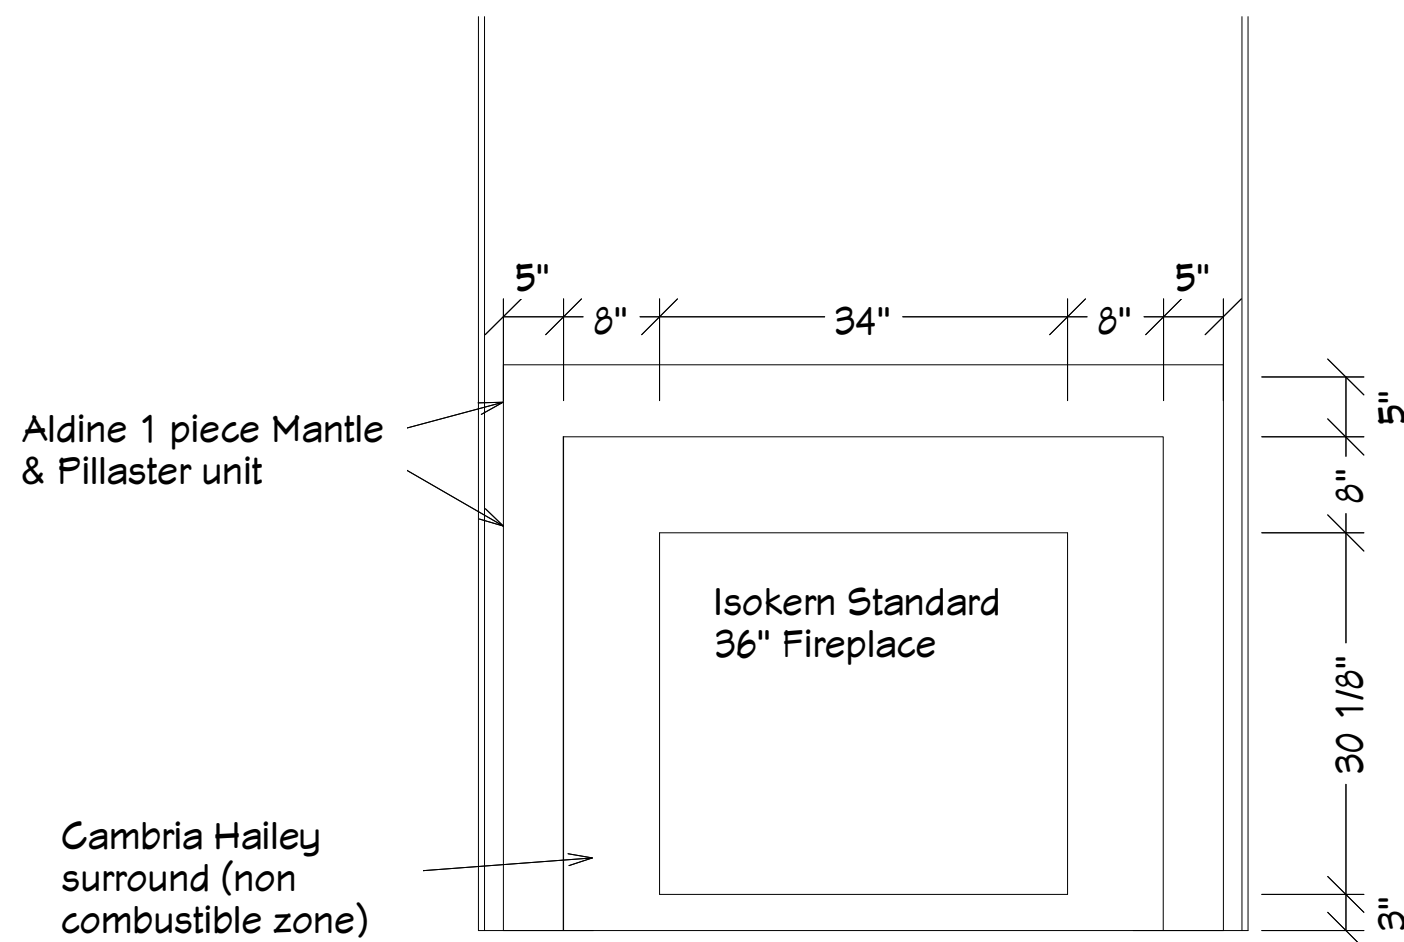


PFP 18 Primary fireplace
3/4 in = 1 ft

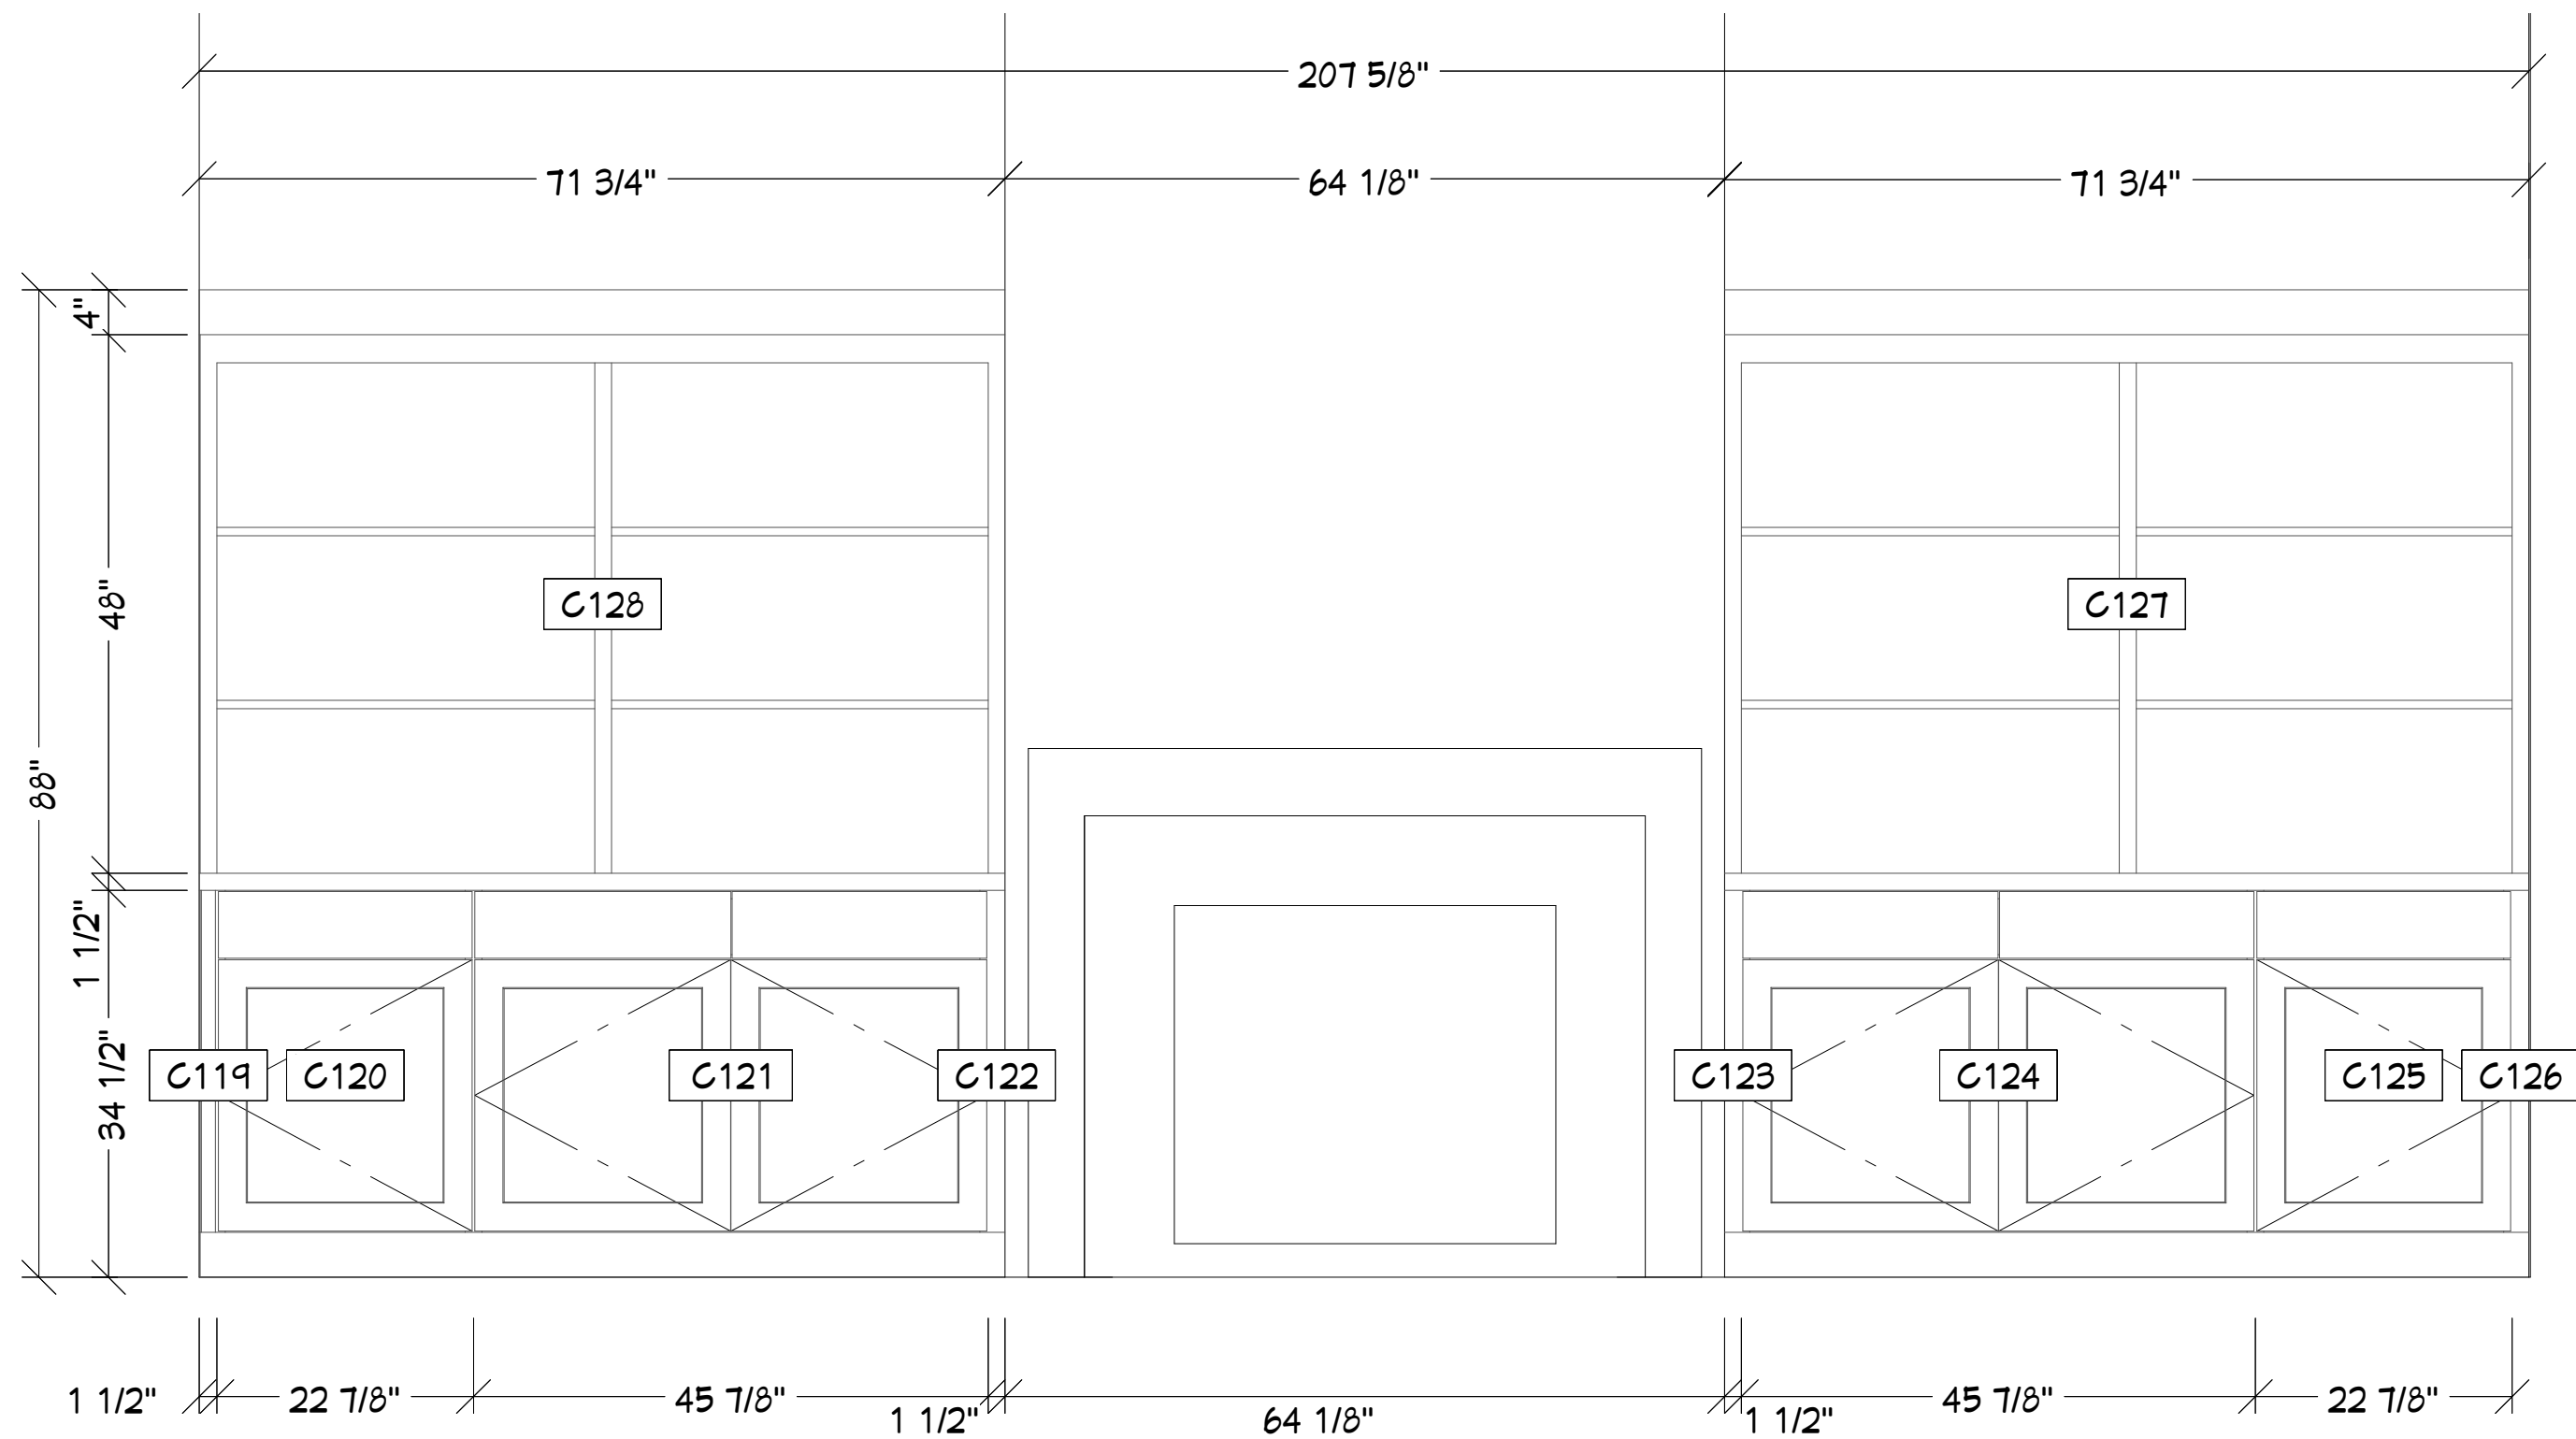

T 18 Primary Builtin
3/4 in = 1 ft

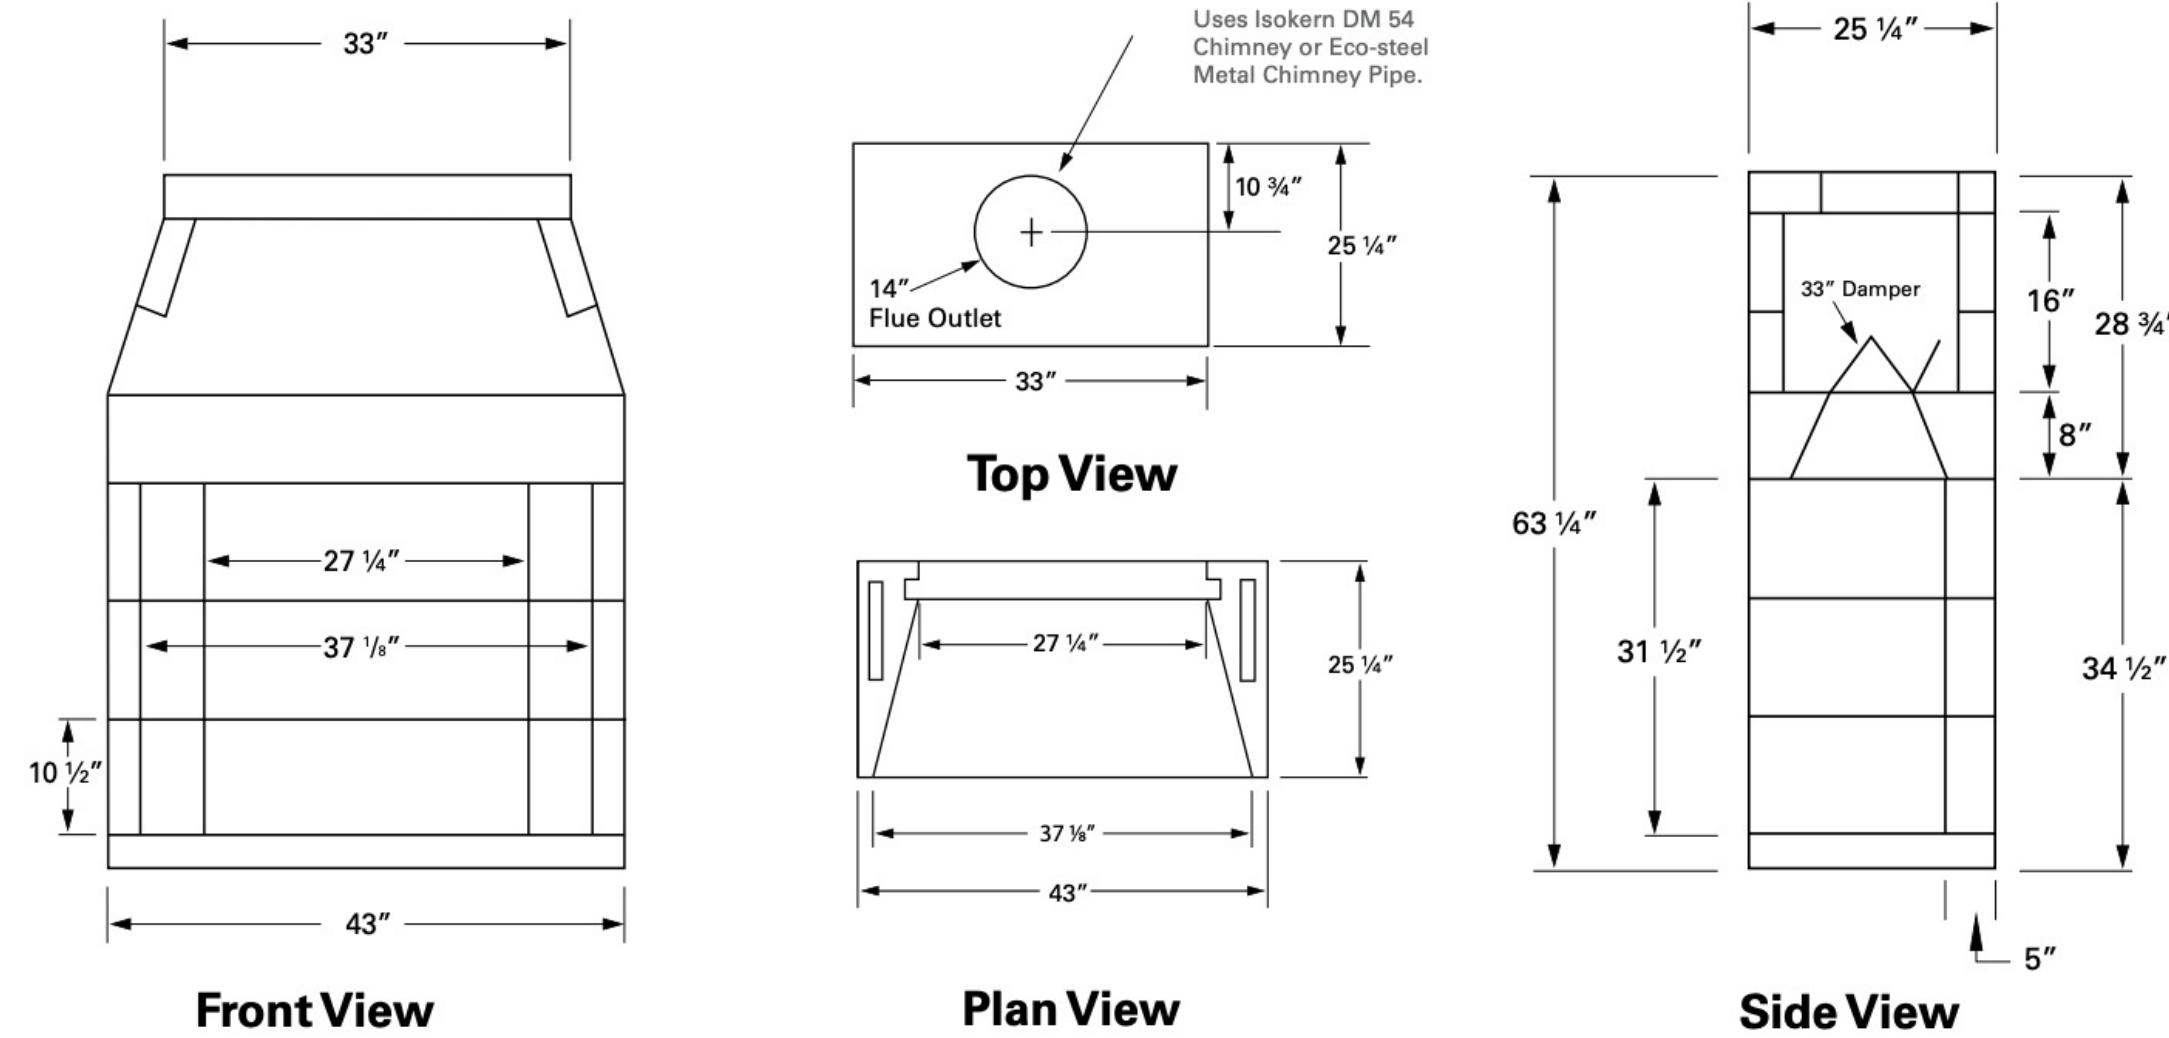

MINIMUM FRAMING DIMENSIONS

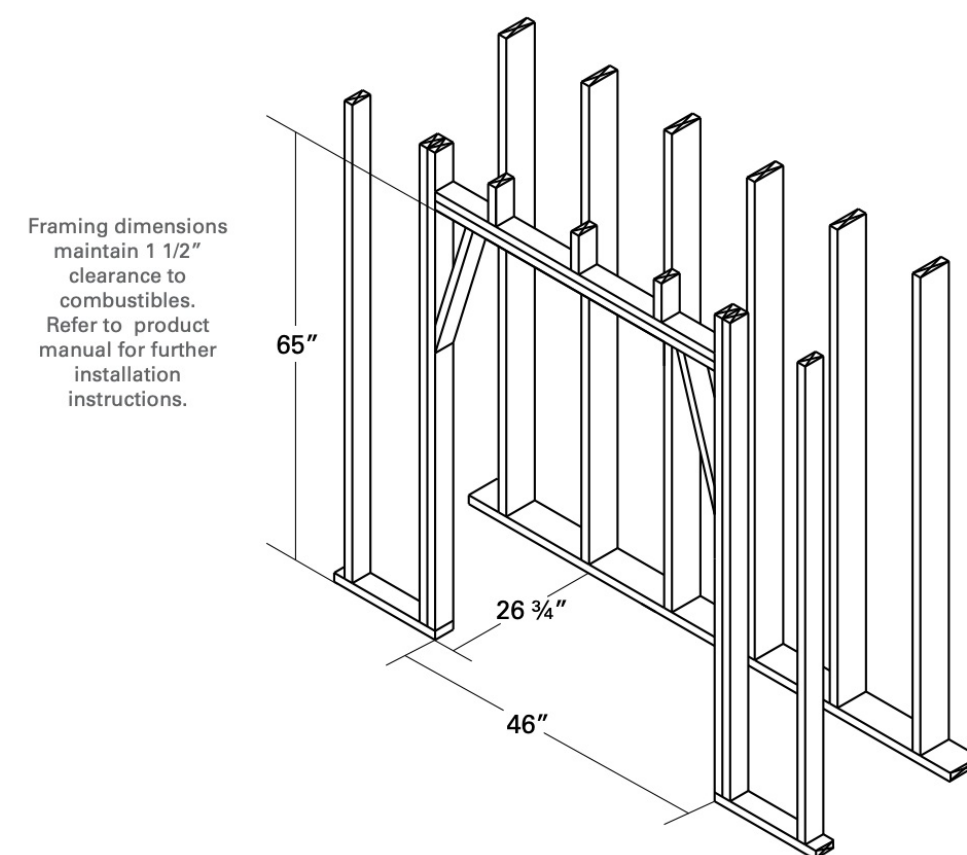

3D VIEWS ARE NOT TO SCALE AND MAY NOT REFLECT EXACTLY WHAT IS AVAILABLE FOR THE PROJECT. RENDER VIEWS ARE REPRESENTATIONS OF WHAT THE VIEW COULD LOOK LIKE, NOT WHAT IT WILL LOOK LIKE. 2D VIEWS ALWAYS SUPERCEDE 3D VIEWS

Renowned Group
4848 Lemmon Ave, suite 106,
Dallas, TX, 75219
PHONE: 972-252-7122 EMAIL: info@renowned-group.com

LICENSE NUMBER:

BU118842

REMODEL PLANS FOR:

Plassick Morton
3504 Villanova St
Dallas, TX, 75225

PAGE TITLE:

Primary

DRAWN BY:

MB

DATE:

5/7/25

SCALE:

Multiple

SHEET #:

18

CABINET SCHEDULE										
NUMBER	ROOM NAME	FLOOR	WIDTH	DEPTH	HEIGHT	LEFT SIDE	RIGHT SIDE	DESCRIPTION	MANUFACTURER	COMMENTS
C01	BAR	1	2"	24 1/8"	36"	UNFINISHED	UNFINISHED	BASE CABINET FILLER	STYLECRAFT	
C02	BAR	1	26 7/8"	24 1/8"	36"	UNFINISHED	UNFINISHED	BASE CABINET	STYLECRAFT	
C03	BAR	1	24"	24 1/8"	36"	UNFINISHED	UNFINISHED	BASE CABINET	STYLECRAFT	BEVERAGE FRIDGE 24" PANEL READY DEU2450B6/L
C04	BAR	1	24"	24 1/8"	36"	UNFINISHED	UNFINISHED	BASE CABINET	STYLECRAFT	WINE FRIDGE SUBZERO PANEL READY 24" DEU2450VNR
C05	BAR	1	2"	24 1/8"	36"	UNFINISHED	UNFINISHED	BASE CABINET FILLER	STYLECRAFT	
C06	BAR	1	2"	12 7/8"	42"	UNFINISHED	UNFINISHED	WALL CABINET FILLER	STYLECRAFT	
C07	BAR	1	22"	12 7/8"	42"	FINISHED	UNFINISHED	WALL CABINET	STYLECRAFT	RECESSED BOTTOM W/ LED PUCKS
C08	BAR	1	32 7/8"	12 7/8"	1 1/2"	FINISHED	FINISHED	SHELF	STYLECRAFT	WHITE OAK UNFINISHED W/ LED PUCKS
C09	BAR	1	32 7/8"	12 7/8"	1 1/2"	FINISHED	FINISHED	SHELF	STYLECRAFT	WHITE OAK UNFINISHED W/ LED PUCKS
C10	BAR	1		12 7/8"	42"	UNFINISHED	FINISHED	WALL CABINET	STYLECRAFT	RECESSED BOTTOM W/ LED PUCKS
C11	BAR	1	2"	12 7/8"	42"	UNFINISHED	UNFINISHED	WALL CABINET FILLER	STYLECRAFT	
C12	BAR	1	2"	24 1/8"	36"	UNFINISHED	UNFINISHED	BASE CABINET FILLER	STYLECRAFT	
C13	BAR	1	26 9/16"	24 1/8"	36"	UNFINISHED	UNFINISHED	BASE CABINET	STYLECRAFT	
C14	BAR	1	24 1/4"	24 1/8"	36"	UNFINISHED	UNFINISHED	BASE CABINET	STYLECRAFT	SINK B2DR THOMPSON TRADERS 17 X 15 INCH QUINTANA SQUARE BAR / PREP SINK
C15	BAR	1	15 1/4"	24 1/8"	36"	UNFINISHED	UNFINISHED	BASE CABINET	STYLECRAFT	BASE ICE MAKER SUBZERO 15" ICE MAKER - PANEL READY UG-15IFO
C16	BAR	1	10 13/16"	24 1/8"	36"	UNFINISHED	UNFINISHED	BASE CABINET	STYLECRAFT	TRADER DIVIDER FOR CUTTING BOARDS
C17	BAR	1	2"	24 1/8"	36"	UNFINISHED	UNFINISHED	BASE CABINET FILLER	STYLECRAFT	
C18	BAR	1	2"	12 7/8"	42"	UNFINISHED	UNFINISHED	WALL CABINET FILLER	STYLECRAFT	
C19	BAR	1	18"	12 7/8"	42"	HAS FACE	UNFINISHED	WALL CABINET	STYLECRAFT	RECESSED BOTTOM W/ LED PUCKS
C20	BAR	1	16 1/2"	12 7/8"	42"	UNFINISHED	HAS FACE	WALL CABINET	STYLECRAFT	RECESSED BOTTOM W/ LED PUCKS
C21	BAR	1	2"	12 7/8"	42"	UNFINISHED	UNFINISHED	WALL CABINET FILLER	STYLECRAFT	
C22	KITCHEN	1	39"	24 1/8"	36"	HAS FACE	UNFINISHED	BASE CABINET	STYLECRAFT	
C23	KITCHEN	1	39"	24 1/8"	36"	UNFINISHED	UNFINISHED	BASE CABINET	STYLECRAFT	
C24	KITCHEN	1	37 1/2"	26"	46"	FINISHED	UNFINISHED	UTILITY CABINET	STYLECRAFT	PANEL READY DET3650G1
C25	KITCHEN	1	37 1/2"	26"	46"	HAS FACE	HAS FACE	UTILITY CABINET	STYLECRAFT	PANEL READY DEC3650R
C26	KITCHEN	1	24"	12 7/8"	42"	FINISHED	FINISHED	WALL CABINET	STYLECRAFT	GLASS DOORS & SHELVES RECESSED BOTTOM W/ LED PUCKS
C27	KITCHEN	1	30"	12 7/8"	1 1/2"	FINISHED	FINISHED	SHELF	STYLECRAFT	WHITE OAK UNFINISHED W/ LED PUCKS
C28	KITCHEN	1	30"	12 7/8"	1 1/2"	FINISHED	FINISHED	SHELF	STYLECRAFT	WHITE OAK UNFINISHED W/ LED PUCKS
C29	KITCHEN	1	24"	12 7/8"	42"	HAS FACE	FINISHED	WALL CABINET	STYLECRAFT	GLASS DOOR & SHELVES RECESSED BOTTOM W/ LED PUCKS
C30	KITCHEN	1	2"	24 1/8"	36"	UNFINISHED	UNFINISHED	BASE CABINET FILLER	STYLECRAFT	
C31	KITCHEN	1	25"	24 1/8"	36"	UNFINISHED	UNFINISHED	BASE CABINET	STYLECRAFT	
C32	KITCHEN	1	25"	24 1/8"	36"	UNFINISHED	UNFINISHED	BASE CABINET	STYLECRAFT	
C33	KITCHEN	1	20 3/16"	24 1/8"	36"	UNFINISHED	UNFINISHED	BASE CABINET	STYLECRAFT	TRASH PULL W/ DRAWER INSIDE @ TOP
C34	KITCHEN	1	24"	24 1/8"	36"	UNFINISHED	UNFINISHED	BASE CABINET	STYLECRAFT	B DISHWASHER DVQ2450
C35	KITCHEN	1	36"	24 1/8"	36"	UNFINISHED	UNFINISHED	BASE CABINET	STYLECRAFT	SINK CAB KOHLER RIVERBY 33" UNDERMOUNT SINGLE BASIN
C36	KITCHEN	1	24"	24 1/8"	36"	UNFINISHED	UNFINISHED	BASE CABINET	STYLECRAFT	B DISHWASHER DVQ2450
C37	KITCHEN	1	12 13/16"	24 1/8"	36"	UNFINISHED	UNFINISHED	BASE CABINET	STYLECRAFT	TRAY PULLOUT
C38	KITCHEN	1	25"	24 1/8"	36"	UNFINISHED	UNFINISHED	BASE CABINET	STYLECRAFT	CUTLERY DIVIDER IN DRAWER SHALLOW PULLOUTS BEHIND DOOR
C39	KITCHEN	1	25"	24 1/8"	36"	UNFINISHED	UNFINISHED	BASE CABINET	STYLECRAFT	PULLOUTS
C40	KITCHEN	1	2"	24 1/8"	36"	UNFINISHED	UNFINISHED	BASE CABINET FILLER	STYLECRAFT	
C41	KITCHEN	1	2 1/8"	13 7/8"	42"	UNFINISHED	UNFINISHED	WALL CABINET FILLER	STYLECRAFT	
C42	KITCHEN	1	31 3/8"	13 7/8"	42"	UNFINISHED	UNFINISHED	WALL CABINET	STYLECRAFT	RECESSED BOTTOM W/ LED PUCKS
C43	KITCHEN	1	31 3/8"	13 7/8"	42"	HAS FACE	UNFINISHED	WALL CABINET	STYLECRAFT	RECESSED BOTTOM W/ LED PUCKS
C44	KITCHEN	1	34 7/8"	13 7/8"	42"	UNFINISHED	HAS FACE	WALL CABINET	STYLECRAFT	RECESSED BOTTOM W/ LED PUCKS
C45	KITCHEN	1	34 7/8"	13 7/8"	42"	UNFINISHED	UNFINISHED	WALL CABINET	STYLECRAFT	RECESSED BOTTOM W/ LED PUCKS
C46	KITCHEN	1	2"	13 7/8"	42"	UNFINISHED	UNFINISHED	WALL CABINET FILLER	STYLECRAFT	
C47	KITCHEN	1	18"	24 1/8"	36"	HAS FACE	FINISHED	BASE CABINET	STYLECRAFT	TOP DRAWER SPICE INSERT
C48	KITCHEN	1	18"	24 1/8"	36"	FINISHED	HAS FACE	BASE CABINET	STYLECRAFT	TOP DRAWER SPICE INSERT
C49	KITCHEN	1	13/16"	8 1/8"	36"	FINISHED	FINISHED	BASE CABINET FILLER	STYLECRAFT	
C50	KITCHEN	1	13/16"	8 1/8"	42"	UNFINISHED	FINISHED	WALL CABINET FILLER	STYLECRAFT	
C51	KITCHEN	1	18"	13 7/8"	42"	FINISHED	HAS FACE	WALL CABINET	STYLECRAFT	RECESSED BOTTOM W/ LED PUCKS
C52	KITCHEN	1	48"	21"	30 1/16"			WOOD HOOD	HOODSLY	SLOPED
C53	KITCHEN	1	18"	13 7/8"	42"	HAS FACE	FINISHED	WALL CABINET	STYLECRAFT	SPICE PULLOUT RECESSED BOTTOM W/ LED PUCKS
C54	KITCHEN	1	54 3/4"	3/4"	36"	FINISHED	FINISHED	BASE CABINET	STYLECRAFT	APPLIED PANEL TO MATCH DOOR STYLE
C55	KITCHEN	1	54 3/4"	3/4"	36"	FINISHED	UNFINISHED	BASE CABINET	STYLECRAFT	APPLIED PANEL TO MATCH DOOR STYLE
C56	KITCHEN	1	30 1/8"	24 1/8"	36"	HAS FACE	UNFINISHED	BASE CABINET	STYLECRAFT	WARNING DRAWER KNOB W/ND30 AT TOP UTILIZE TWO DRAWER FRONTS, DONELED TOGETHER IF NECESSARY.
C57	KITCHEN	1	30 1/8"	24 1/8"	36"	UNFINISHED	UNFINISHED	BASE CABINET	STYLECRAFT	CUTLERY DIVIDER AND TOP DRAWER
C58	KITCHEN	1	24 1/4"	24 1/8"	36"	UNFINISHED	HAS FACE	BASE CABINET	STYLECRAFT	BASE MICROWAVE IN DRAWER UNDER R SIDE MAINSCOTT
C59	KITCHEN	1	37"	16"	36"	UNFINISHED	UNFINISHED	BASE CABINET	STYLECRAFT	
C60	KITCHEN	1	37"	16"	36"	UNFINISHED	FINISHED	BASE CABINET	STYLECRAFT	
C63	SERVERY	1	1 1/2"	19"	30"	UNFINISHED	UNFINISHED	BASE CABINET FILLER	STYLECRAFT	
C64	SERVERY	1	20 3/4"	19"	30"	UNFINISHED	FINISHED	BASE CABINET	STYLECRAFT	
C65	SERVERY	1	33 3/4"	19"	33 3/4"	UNFINISHED	UNFINISHED	BASE CABINET	STYLECRAFT	
C66	SERVERY	1	16"	19"	30"	UNFINISHED	UNFINISHED	BASE CABINET	STYLECRAFT	
C67	SERVERY	1	1 1/2"	19"	30"	UNFINISHED	UNFINISHED	BASE CABINET FILLER	STYLECRAFT	
C68	HALLWAY	1	1 1/2"	16"	36"	UNFINISHED	UNFINISHED	BASE CABINET FILLER	STYLECRAFT	
C69	HALLWAY	1	36 7/8"	16"	36"	UNFINISHED	UNFINISHED	BASE CABINET	STYLECRAFT	
C70	HALLWAY	1	1 1/2"	16"	36"	UNFINISHED	UNFINISHED	BASE CABINET FILLER	STYLECRAFT	
C71	HALLWAY	1	41 1/8"	15"	58"	UNFINISHED	UNFINISHED	WALL CABINET	STYLECRAFT	DELETE BOTTOM TO BE INSTALLED ON WOOD TOP
C72	LIVING	1	1 1/2"	14"	36"	UNFINISHED	UNFINISHED	BASE CABINET FILLER	STYLECRAFT	
C73	LIVING	1	48 1/8"	14"	36"	UNFINISHED	UNFINISHED	BASE CABINET	STYLECRAFT	
C74	LIVING	1	1 1/2"	14"	36"	UNFINISHED	UNFINISHED	BASE CABINET FILLER	STYLECRAFT	
C75	LIVING	1	51 1/8"	14"	58 5/16"	UNFINISHED	UNFINISHED	WALL CABINET	STYLECRAFT	DELETE BOTTOM TO BE INSTALLED ON WOOD TOP
C76	LIVING	1	2"	18"	36"	FINISHED	UNFINISHED	BASE CABINET	STYLECRAFT	
C77	LIVING	1	37"	18"	36"	UNFINISHED	UNFINISHED	BASE CABINET	STYLECRAFT	
C78	LIVING	1	2"	18"	36"	UNFINISHED	UNFINISHED	BASE CABINET	STYLECRAFT	
C79	LIVING	1	44"	18"	36"	UNFINISHED	UNFINISHED	BASE CABINET	STYLECRAFT	
C80	LIVING	1	2"	18"	36"	UNFINISHED	UNFINISHED	BASE CABINET	STYLECRAFT	
C81	LIVING	1	37"	18"	36"	UNFINISHED	UNFINISHED	BASE CABINET	STYLECRAFT	
C82	LIVING	1	2"	18"	36"	UNFINISHED	FINISHED	BASE CABINET	STYLECRAFT	
C83	LIVING	1	41"	18"	58"	HAS FACE	HAS FACE	WALL CABINET	STYLECRAFT	DELETE BOTTOM TO BE INSTALLED ON WOOD TOP. OPEN SIDES.
C84	LIVING	1	41"	18"	58"	HAS FACE	HAS FACE	WALL CABINET	STYLECRAFT	DELETE BOTTOM TO BE INSTALLED ON WOOD TOP. OPEN SIDES
C85	POWDER BATH	1	48"	21"	36"	UNFINISHED	FINISHED	BASE CABINET	STYLECRAFT	TBD
C86	PRIMARY BATH	2	2"	14 7/8"	36"	UNFINISHED	UNFINISHED	BASE CABINET FILLER	STYLECRAFT	
C87	PRIMARY BATH	2	24"	14 7/8"	36"	UNFINISHED	UNFINISHED	BASE CABINET	STYLECRAFT	
C88	PRIMARY BATH	2	18"	14 7/8"	36"	UNFINISHED	UNFINISHED	BASE CABINET	STYLECRAFT	
C89	PRIMARY BATH	2	28"	14 7/8"	36"	UNFINISHED	UNFINISHED	BASE CABINET	STYLECRAFT	SIGNATURE HARDWARE MYERS 23" UNDERMOUNT BATHROOM SINK
C90	PRIMARY BATH	2	18"	14 7/8"	36"	FINISHED	UNFINISHED	BASE CABINET	STYLECRAFT	
C91	PRIMARY BATH	2	42"	18"	18"	HAS FACE	UNFINISHED	BASE CABINET	STYLECRAFT	
C92	PRIMARY BATH	2	42"	1"	47 1/2"	FINISHED	FINISHED	BASE CABINET	STYLECRAFT	
C93	PRIMARY BATH	2	42"	12"	14 1/2"	HAS FACE	HAS FACE	WALL CABINET	STYLECRAFT	
C94	PRIMARY BATH	2	24"	12"	44"	HAS FACE	UNFINISHED	WALL CABINET	STYLECRAFT	
C95	PRIMARY BATH	2	2"	12"	44"	UNFINISHED	UNFINISHED	WALL CABINET FILLER	STYLECRAFT	
C96	PRIMARY BATH	2	2"	21 7/8"	36"	UNFINISHED	UNFINISHED	BASE CABINET FILLER	STYLECRAFT	
C97	PRIMARY BATH	2	18"	21 7/8"	36"	UNFINISHED	UNFINISHED	BASE CABINET	STYLECRAFT	
C98	PRIMARY BATH	2	16"	21 7/8"	36"	UNFINISHED	UNFINISHED	BASE CABINET	STYLECRAFT	
C99	PRIMARY BATH	2	26"	21 7/8"	36"	UNFINISHED	UNFINISHED	BASE CABINET	STYLECRAFT	SIGNATURE HARDWARE MYERS 23" UNDERMOUNT BATHROOM SINK
C100	PRIMARY BATH	2	16"	21 7/8"	36"	UNFINISHED	HAS FACE	BASE CABINET	STYLECRAFT	
C101	PRIMARY BATH	2	2"	12"	44"	UNFINISHED	UNFINISHED	WALL CABINET FILLER	STYLECRAFT	
C102	PRIMARY BATH	2	18"	12"	44"	UNFINISHED	HAS FACE	WALL CABINET	STYLECRAFT	
C103	IN-LAW BATH	2	12"	21 7/8"	36"	HAS FACE	UNFINISHED	BASE CABINET	STYLECRAFT	
C104	IN-LAW BATH	2	30"	21 7/8"	36"	UNFINISHED	UNFINISHED	BASE CABINET	STYLECRAFT	SIGNATURE HARDWARE MYERS 23"UNDERMOUNT BATHROOM SINK
C105	IN-LAW BATH	2	12"	21 7/8"	36"	UNFINISHED	UNFINISHED	BASE CABINET	STYLECRAFT	
C106	IN-LAW BATH	2	2"	21 7/8"	36"	UNFINISHED	UNFINISHED	BASE CABINET FILLER	STYLECRAFT	
C107	FLEX BATH	2	1 1/2"	21 7/8"	36"	UNFINISHED	UNFINISHED	BASE CABINET FILLER	STYLECRAFT	
C108	FLEX BATH	2	18"	21 7/8"	36"	UNFINISHED	UNFINISHED	BASE CABINET	STYLECRAFT	
C109	FLEX BATH	2	30"	21 7/8"	36"	UNFINISHED	UNFINISHED	BASE CABINET	STYLECRAFT	
C110	FLEX BATH	2	18"	21 7/8"	36"	UNFINISHED	FINISHED	BASE CABINET	STYLECRAFT	
C111	FLEX BATH	2	31 3/4"	14 7/8"	40 1/2"	HAS FACE	UNFINISHED	UTILITY CABINET	STYLECRAFT	
C112	FLEX BATH	2	1 1/2"	14 7/8"	40 1/2"	UNFINISHED	UNFINISHED	UTILITY CABINET FILLER	STYLECRAFT	
C113	MAGGIE'S BATH	2	1 1/2"	21 7/8"	36"	UNFINISHED	UNFINISHED	BASE CABINET FILLER	STYLECRAFT	
C114	MAGGIE'S BATH	2	18"	21 7/8"	36"	UNFINISHED	UNFINISHED	BASE CABINET	STYLECRAFT	
C115	MAGGIE'S BATH	2	30"	21 7/8"	36"	UNFINISHED	UNFINISHED	BASE CABINET	STYLECRAFT	
C116	MAGGIE'S BATH	2	18"	21 7/8"	36"	UNFINISHED	FINISHED	BASE CABINET	STYLECRAFT	
C117	MAGGIE'S BATH	2	31 3/4"	14"	40 1/2"	HAS FACE	UNFINISHED	UTILITY CABINET	STYLECRAFT	
C118	MAGGIE'S BATH	2	1 1/2"	14"	40 1/2"	UNFINISHED	UNFINISHED	UTILITY CABINET FILLER	STYLECRAFT	
C119	PRIMARY BEDROOM	2	1 1/2"	21"	36"	UNFINISHED	UNFINISHED	BASE CABINET FILLER	STYLECRAFT	
C120	PRIMARY BEDROOM	2	22 7/8"	21"	36"	UNFINISHED	UNFINISHED	BASE CABINET	STYLECRAFT	
C121	PRIMARY BEDROOM	2	45 7/8"	21"	36"	UNFINISHED	UNFINISHED	BASE CABINET	STYLECRAFT	
C122	PRIMARY BEDROOM	2	1 1/2"	21"	36"	UNFINISHED	UNFINISHED	BASE CABINET FILLER	STYLECRAFT	
C123	PRIMARY BEDROOM	2	1 1/2"	21"	36"	UNFINISHED	UNFINISHED	BASE CABINET FILLER	STYLECRAFT	
C124	PRIMARY BEDROOM	2	45 13/16"	21"	36"	UNFINISHED	UNFINISHED	BASE CABINET	STYLECRAFT	
C125	PRIMARY BEDROOM	2	22 7/8"	21"	36"	UNFINISHED	UNFINISHED	BASE CABINET	STYLECRAFT	
C126	PRIMARY BEDROOM	2	1 1/2"	21"	36"	UNFINISHED	UNFINISHED	BASE CABINET FILLER	STYLECRAFT	
C127	PRIMARY BEDROOM	2	71 11/16"	14"	48"	UNFINISHED	UNFINISHED	WALL CABINET	STYLECRAFT	DELETE BOTTOM TO BE INSTALLED ON WOOD TOP
C128	PRIMARY BEDROOM	2	71 3/4"	14"	48"	UNFINISHED	UNFINISHED	WALL CABINET	STYLECRAFT	DELETE BOTTOM TO BE INSTALLED ON WOOD TOP

3D VIEWS ARE NOT TO SCALE AND MAY NOT REFLECT EXACTLY WHAT IS AVAILABLE FOR THE PROJECT. RENDER VIEWS ARE REPRESENTATIONS OF WHAT THE VIEW COULD LOOK LIKE, NOT WHAT IT WILL LOOK LIKE. 2D VIEWS ALWAYS SUPERCEDE 3D VIEWS

Renowned Group

4848 Lemmon Ave, suite 106,
Dallas, TX, 75219

PHONE: 972-232-7122 EMAIL: info@renowned-group.com

LICENSE NUMBER:

BU118842

REMODEL PLANS FOR:

Plassick Morton
3504 Villanova St
Dallas, TX, 75225

PAGE TITLE:

Cabinet Schedule

DRAWN BY:

MB

DATE:

5/7/25

SCALE: