


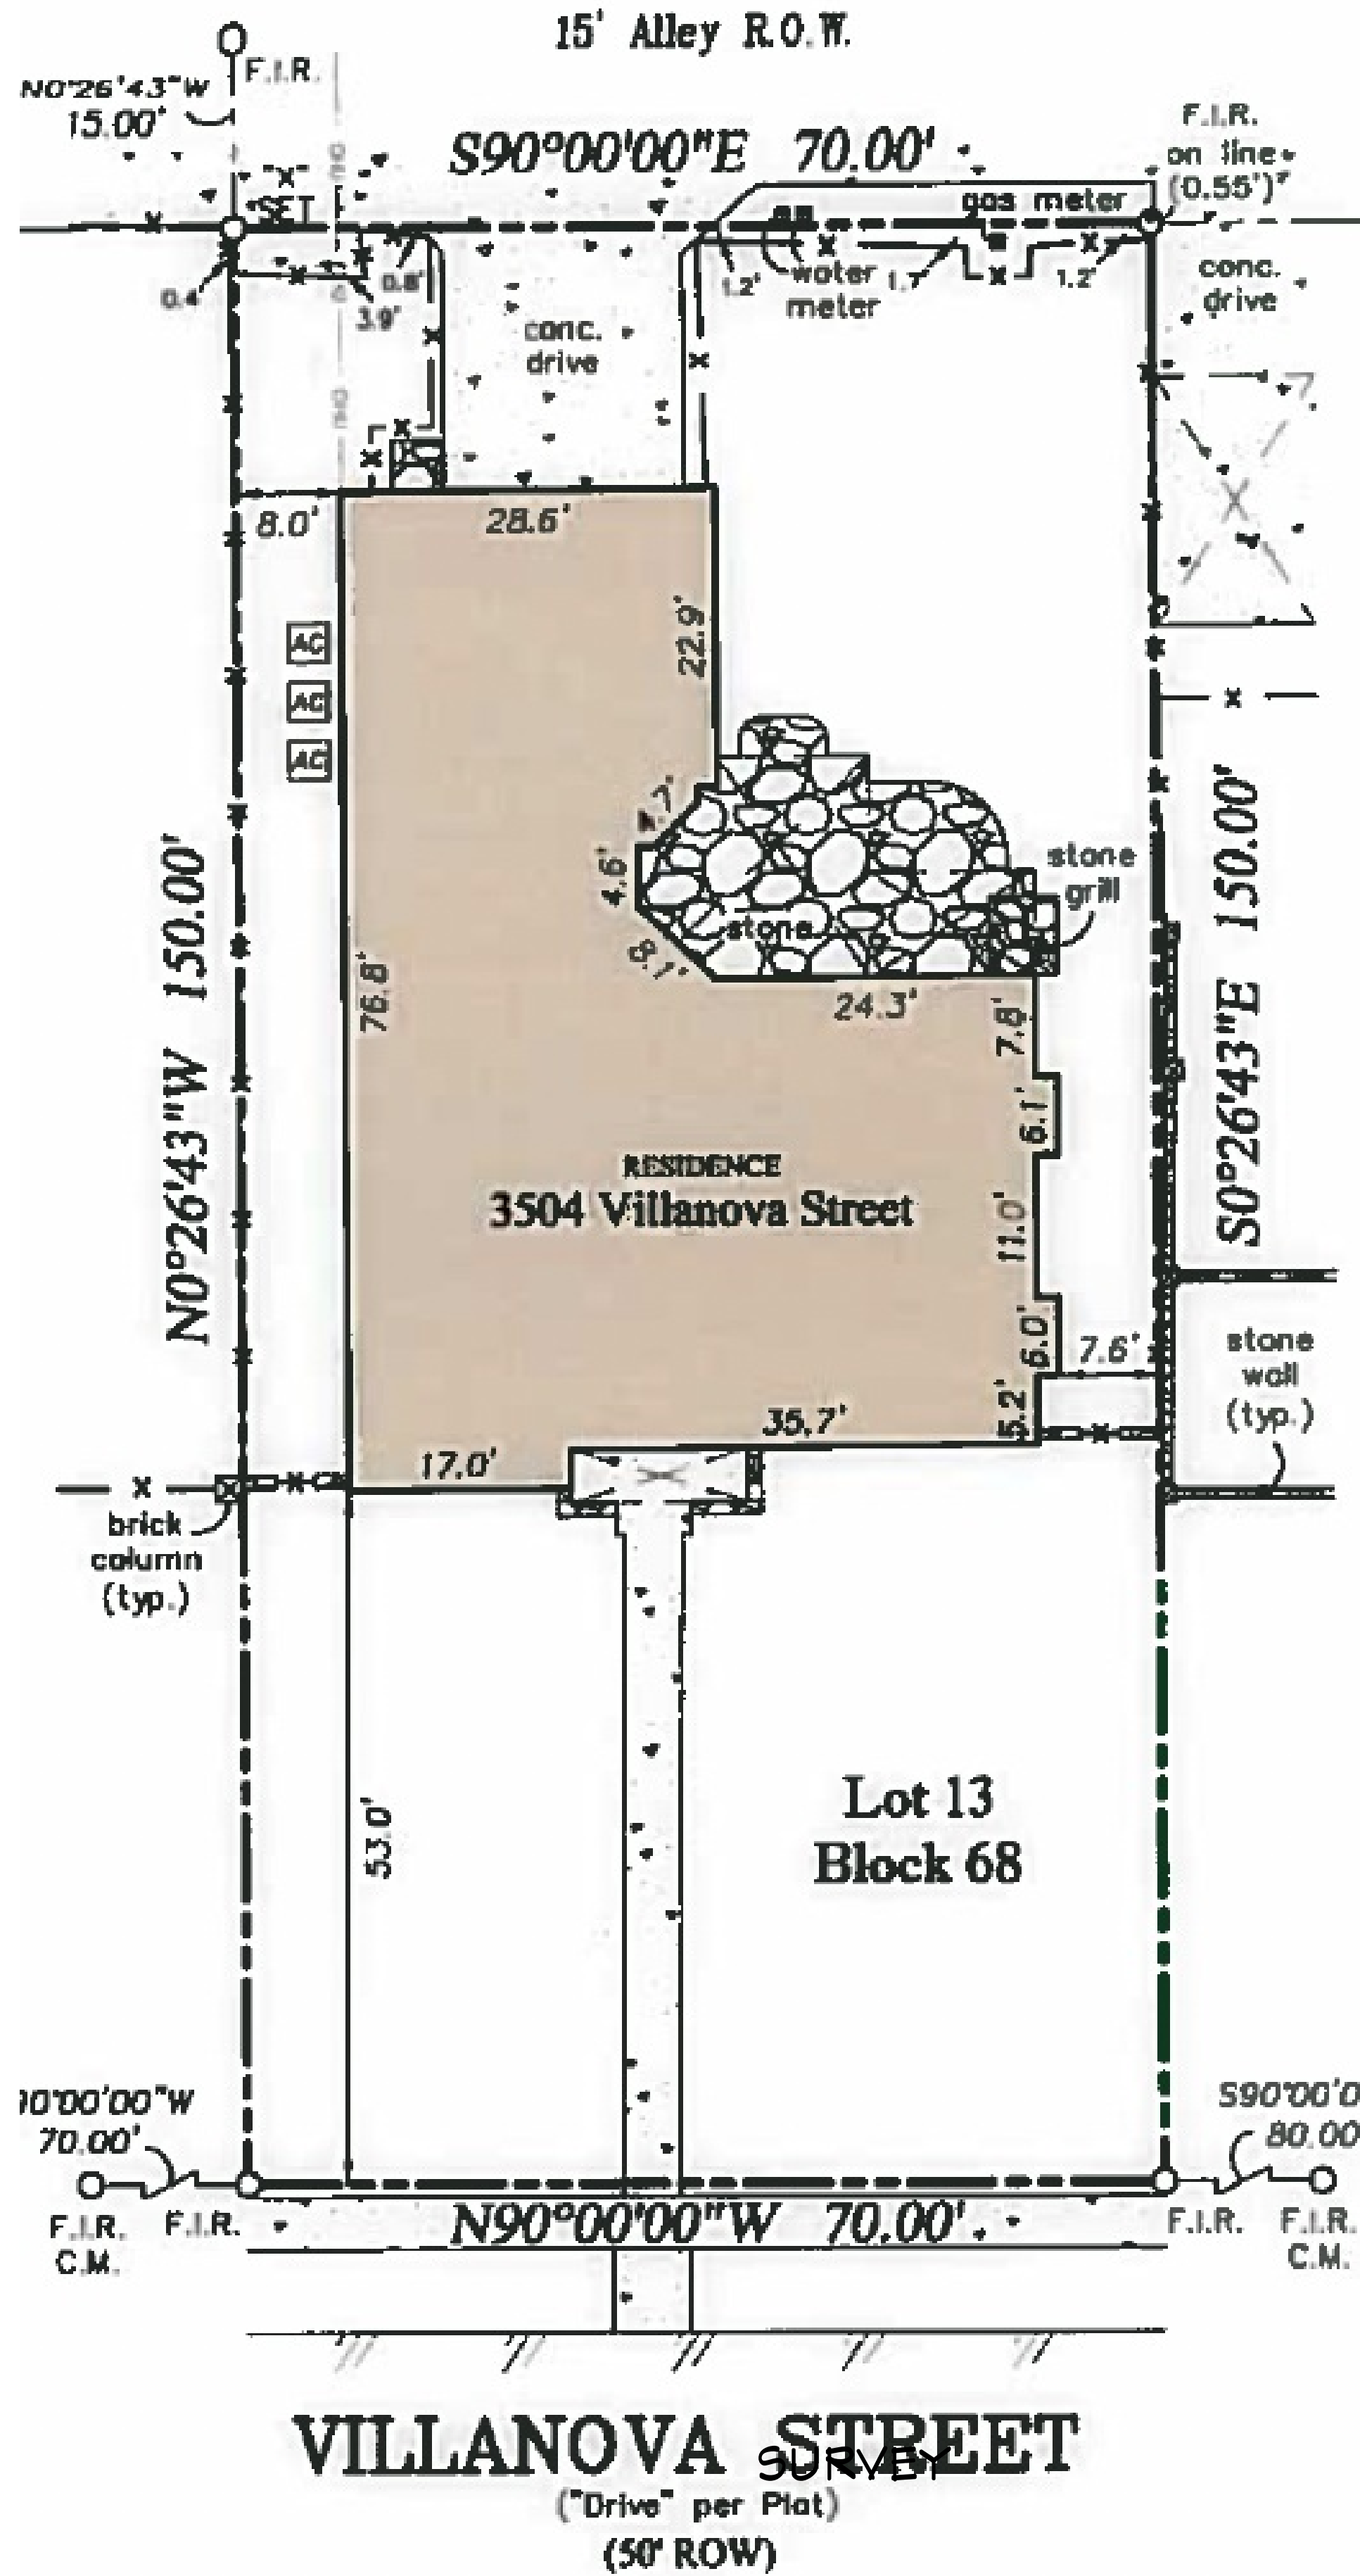

KOHLER.

Model: 38RCLC

Multi-Fuel
Natural Gas/LPG

9001
KOHLER
NATIONALLY REGISTERED



The Kohler® Advantage

- High Quality Power**
Kohler home generators provide advanced voltage and frequency regulation along with ultra-low levels of harmonic distortion for excellent generator power quality to protect your valuable electronics.
- Quiet Operation**
Kohler home generators provide quiet, neighborhood-friendly performance.
- Premium 5-year/2000 hr Limited Warranty Included**
Kohler is known for extraordinary reliability and performance. Kohler's premium limited warranty covers parts, labor, and travel for the full warranty period.
- Aluminum Enclosure**
Attractive aluminum enclosure allows installation as close as 18 inches from your home or small business.

Standard Features

- The generator set and its components are prototype-tested, factory-built, and production-tested.
- The generator set accepts rated load in one step.
- A premium 5 year/2000 hour limited warranty covers all systems and components.
- Quick-ship (QS) models with selected features are available. See your Kohler distributor for details.
- Meets 291 kph (181 mph) wind load rating.
- GFCI service outlet installed on the junction box.
- RDC2 Controller
 - One digital controller manages both the generator set and transfer switch functions (with optional Model RXT transfer switch).
 - Designed for today's most sophisticated electronics.
 - Electronic speed control responds quickly to varying household demand.
 - Digital voltage regulation protects your valuable electronics from harmonic distortion and unstable power quality.
 - Two-line, backlit LCD screen is easy to read in all lighting conditions, including direct sunlight and low light.
 - Able to connect to the internet using ethernet cable, wireless radios, or any other wifi adapters.
- Engine Features
 - Powerful and reliable 2.2 L turbocharged liquid-cooled engine
 - Electronic engine management system.
 - Simple field conversion between natural gas and LPG fuels while maintaining emission certification.
- Innovative Cooling System
 - Electronically controlled fan speeds minimize generator set sound signature.
- Certifications
 - The 60 Hz generator set engine is certified by the Environmental Protection Agency (EPA) to conform to the New Source Performance Standard (NSPS) for stationary spark-ignited emissions.
 - cULus listed
 - Accepted by the Massachusetts Board of Registration of Plumbers and Gas Fitters.
 - Meets NFPA 37 requirements for 18 in. offset for installation.
- Approved for stationary standby applications in locations served by a reliable utility source.

KOHLER.

Model: RXT

Automatic Transfer Switch
100- 400 Amps

9001
KOHLER
NATIONALLY REGISTERED



Model RXT Automatic Transfer Switch

The Model RXT automatic transfer switch is designed for use only with Kohler® generator sets equipped with the RDC2 generator set/transfer switch controller. The transfer switch operation is controlled by the RDC2 controller.

Standard Features

- Allows utility voltage display on the RDC2 generator set/transfer switch controller, available exclusively on Kohler® residential and light commercial generator sets
- UL listed
 - UL 1008 listed, file #E58962
 - Models with load centers use UL 67 listed components
- CSA certification, file #LR58301, is available for:
 - Standard ATS without load center (single and three-phase)
 - Service entrance ATS 100, 200, 300, and 400 amp models
- Corrosion-resistant NEMA 3R aluminum enclosure
 - Padlockable
 - Approved for indoor or outdoor installation
 - ANSI 49 gray
- NEMA 1 enclosure available on 100 amp load center models
- Contactors electrically and mechanically interlocked
- Double throw inherently interlocked design
- Contactors manually operable for maintenance purposes
- Silver alloy main contacts
- Transfer switches are 100% equipment rated and can be applied at the rated current without derating (non-service entrance models)
- Service entrance models include disconnect circuit breaker on the utility (normal) source side (80% rated)
- Five-year limited warranty

PLAN INDEX

PAGE	PAGE TITLE
1	Project Overview
2	Site Plan

3D VIEWS ARE NOT TO SCALE AND MAY NOT REFLECT EXACTLY WHAT IS AVAILABLE FOR THE PROJECT. RENDER VIEWS ARE REPRESENTATIONS OF WHAT THE VIEW COULD LOOK LIKE, NOT WHAT IT WILL LOOK LIKE. 2D VIEWS ALWAYS SUPERCEDE 3D VIEWS

RENOVATED GROUP

4848 LEMMON AVE, SUITE 106,
DALLAS, TX, 75219

PHONE: 972-232-1122 EMAIL: INFO@RENOVATED-GROUP.COM

LICENSE NUMBER:

BU118842

REMODEL PLANS FOR:

PIASSICK MORTON
3504 VILLANOVA ST
DALLAS, TX, 75225

PAGE TITLE:

PROJECT OVERVIEW

DRAWN BY:

GW

DATE:


10/31/25

SCALE:

NA

SHEET #:

1

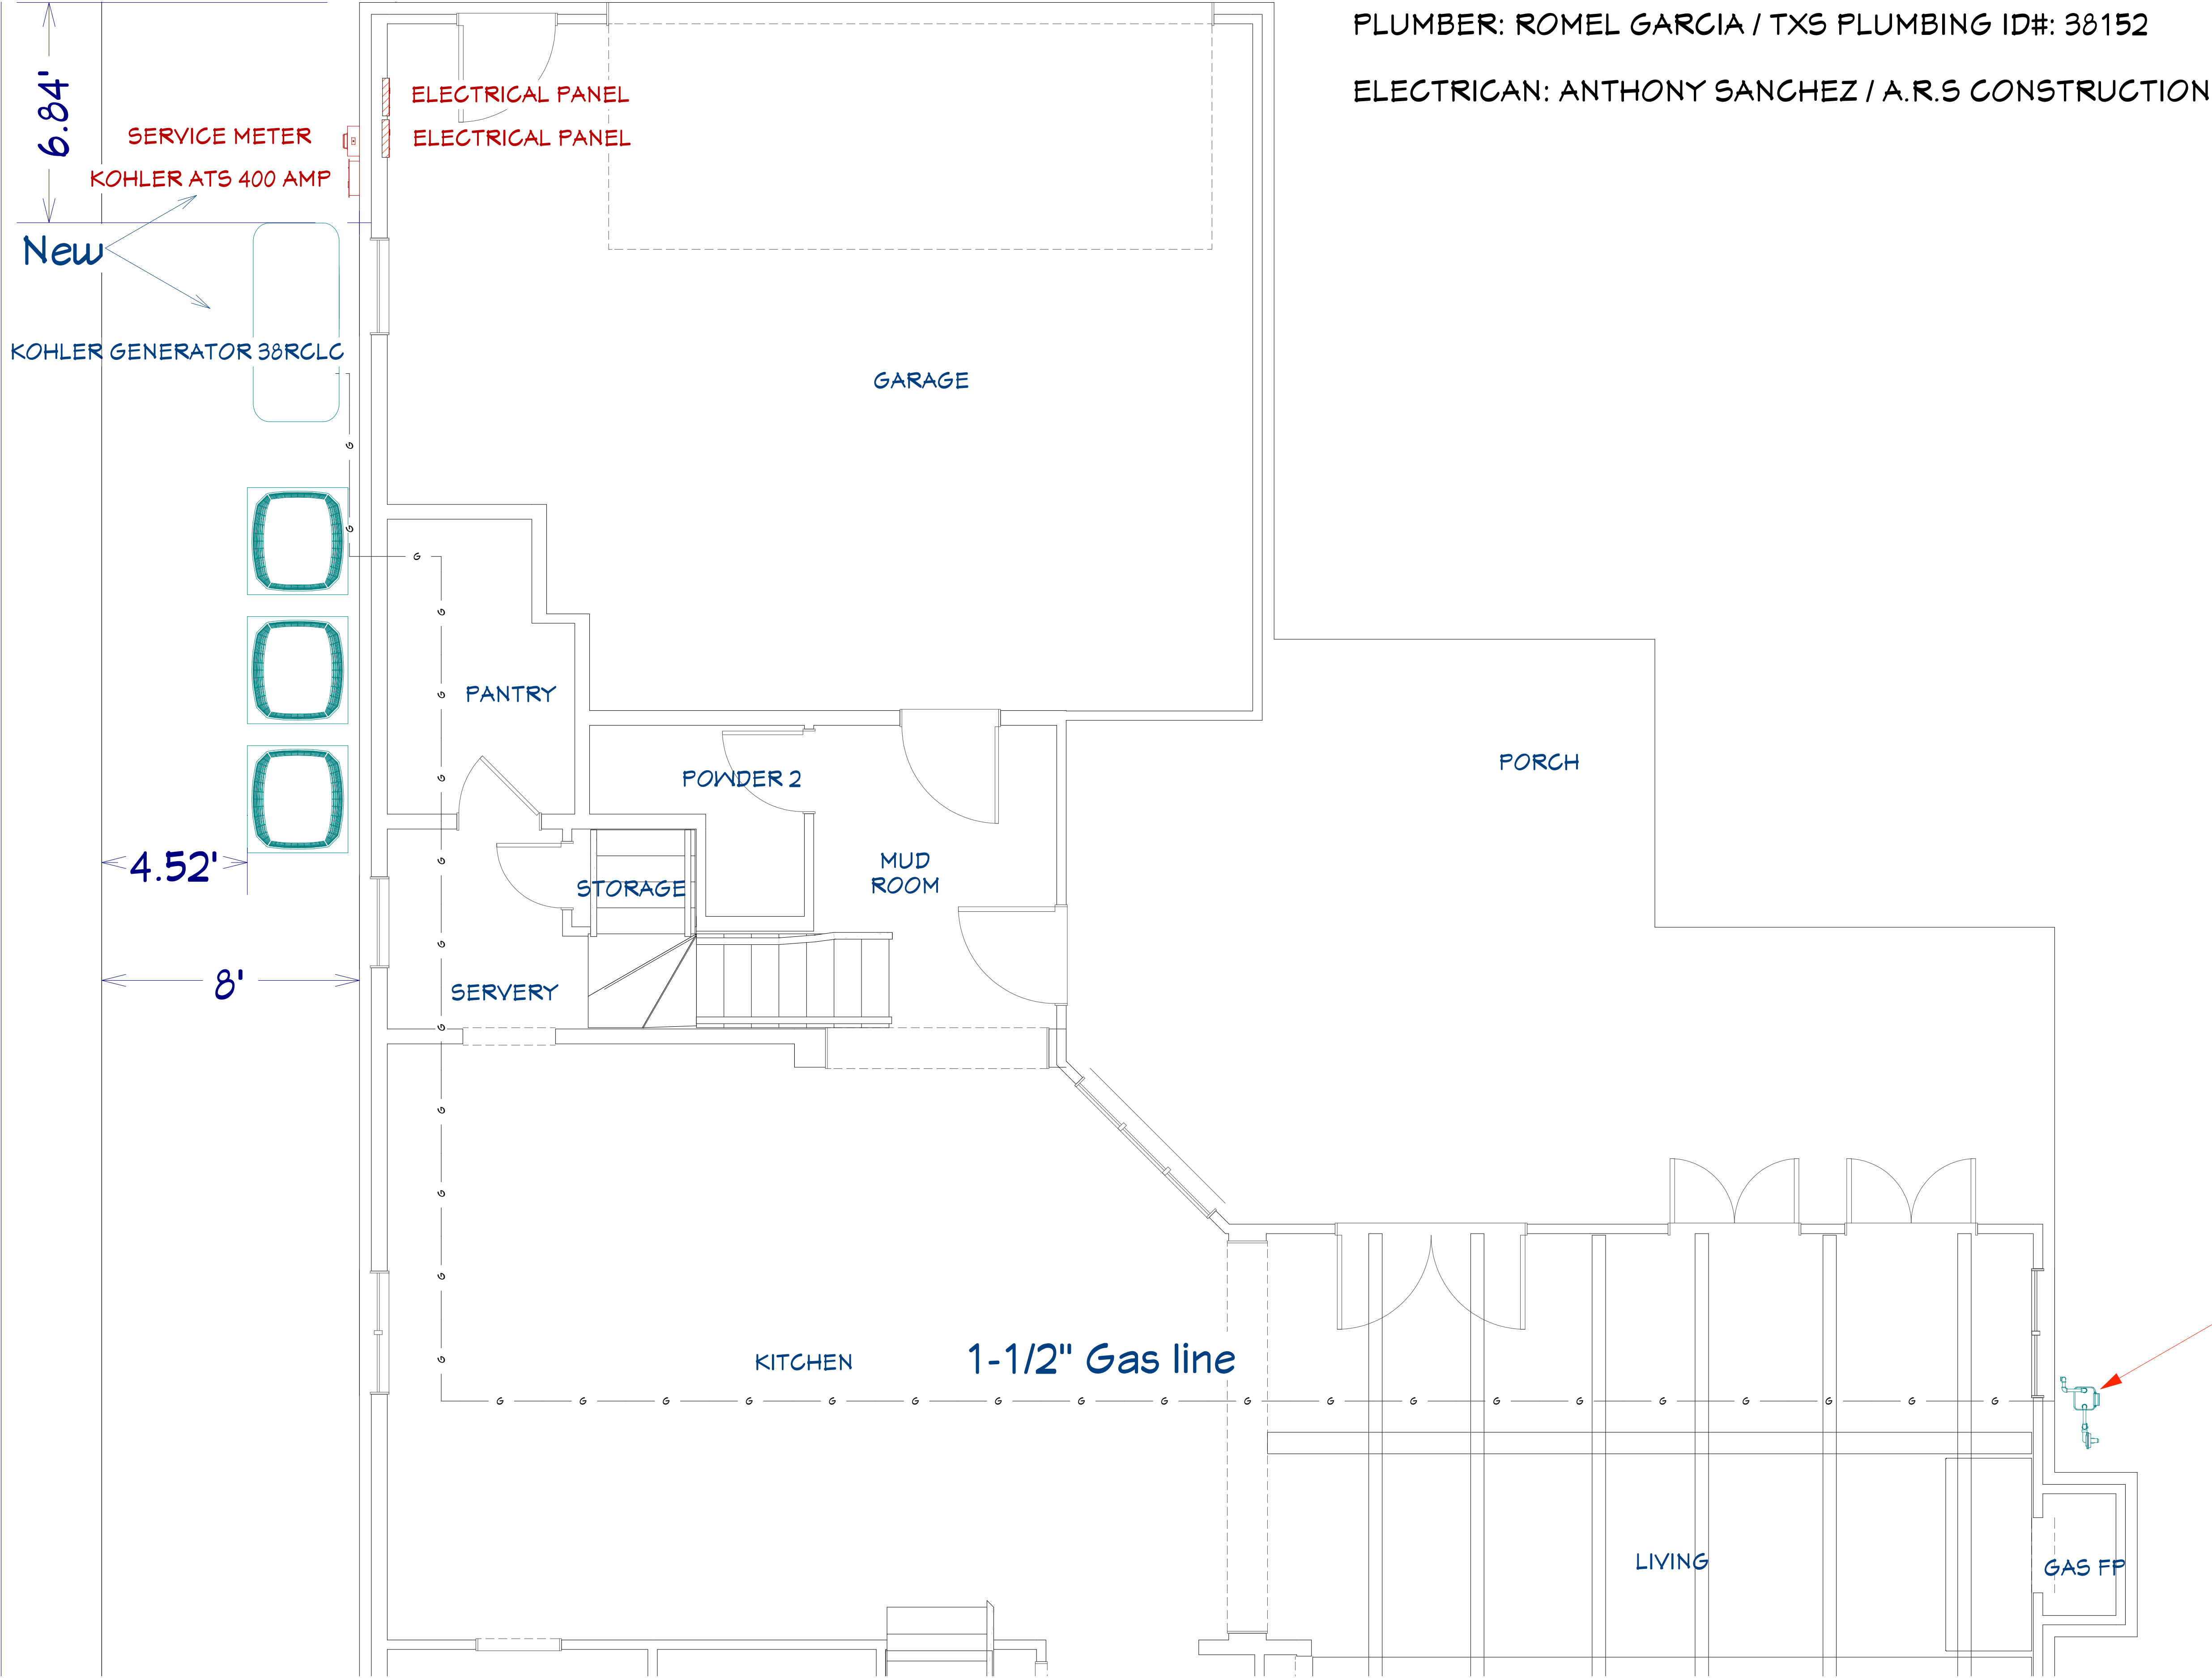

PLUMBER: ROMEL GARCIA / TXS PLUMBING ID#: 38152

ELECTRICIAN: ANTHONY SANCHEZ / A.R.S CONSTRUCTION TECL# 33512

3D VIEWS ARE NOT TO SCALE AND MAY NOT REFLECT EXACTLY WHAT IS AVAILABLE FOR THE PROJECT. RENDER VIEWS ARE REPRESENTATIONS OF WHAT THE VIEW COULD LOOK LIKE, NOT WHAT IT WILL LOOK LIKE. 2D VIEWS ALWAYS SUPERCEDE 3D VIEWS

RENOWNED GROUP

4848 LEMMON AVE, SUITE 106,
DALLAS, TX, 75219

PHONE: 972-232-1122 EMAIL: INFO@RENOWNED-GROUP.COM

LICENSE NUMBER:
BU118842

REMODEL PLANS FOR:
PIASSICK MORTON
3504 VILLANOVA ST
DALLAS, TX, 75225

PAGE TITLE:
SITE PLAN

DRAWN BY:
GW

DATE:
10/31/25

SCALE:
3/8" = 1'

SHEET #:
2

